


ELECTRICAL LEGEND	
[Symbol]	RECEPTACLE
[Symbol]	3-POLE 4-WIRE SWITCH
[Symbol]	2-POLE 4-WIRE SWITCH
[Symbol]	1-POLE 2-WIRE SWITCH
[Symbol]	1-POLE 3-WIRE SWITCH
[Symbol]	1-POLE 4-WIRE SWITCH
[Symbol]	2-POLE 3-WIRE SWITCH
[Symbol]	2-POLE 4-WIRE SWITCH
[Symbol]	3-POLE 4-WIRE SWITCH
[Symbol]	4-POLE 4-WIRE SWITCH
[Symbol]	100-POLE 4-WIRE SWITCH

ALL OUTLETS IN BASE BOARDS

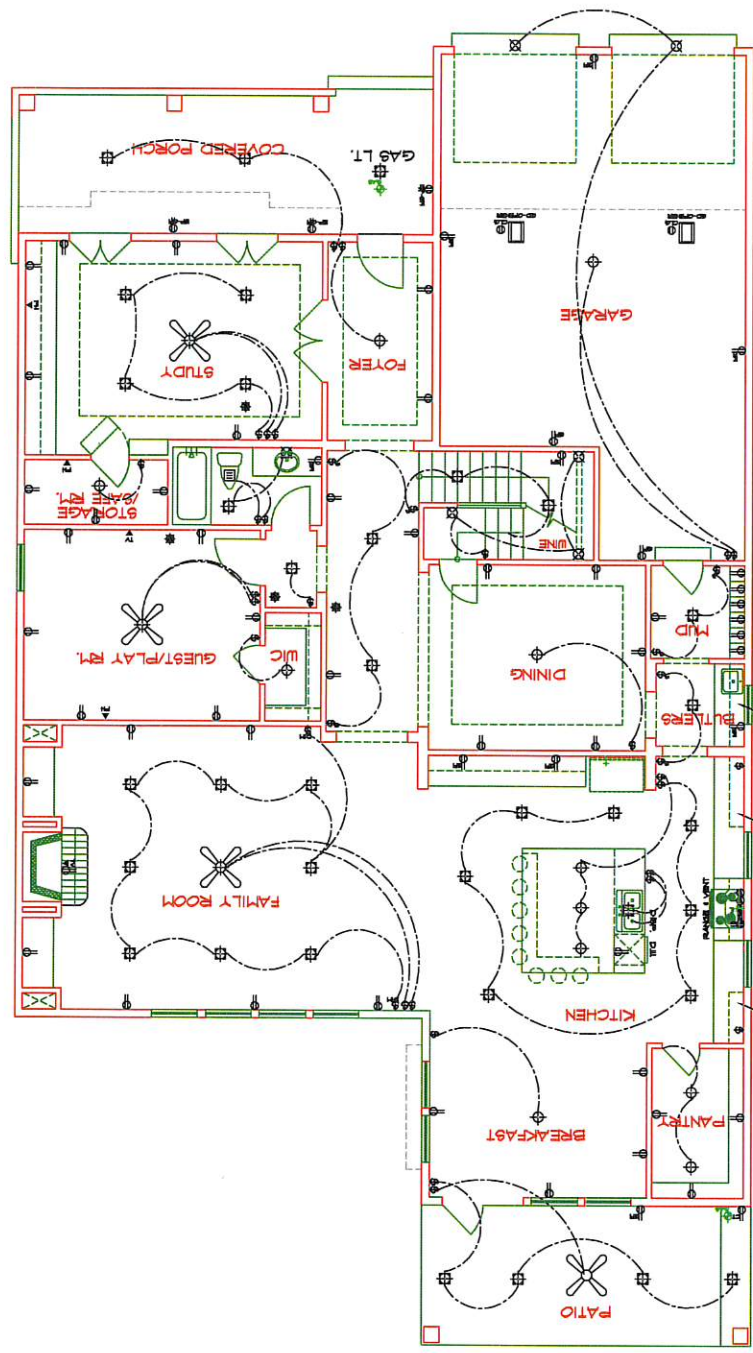

1ST FLOOR ELECTRICAL

SCALE 1/8" = 1'-0"

WOOD CUSTOM HOMES ELEC 1ST PLAN E1	P.L. MURRAY & ASSOCIATES INC. PLANO, TEXAS 972-491-2684		REV DATE: 08/26/18	The measurements, dimensions, and other specifications, shown on this document, are guidelines for construction use only. The actual specifications of the finished structure may vary. All structural design and loads are the responsibility of a registered professional engineer.
	PROJ. NO.: QUICK	JOB NO.: 1795	SCALE: 1/8" = 1'-0"	
LOT: 3	BLOCK: 10	SEC: N/A	DRAWN BY: PLM	

