

DESIGN FOR

CONTEMPORARY COMPANIES, INC.

DARRELL A. HAERTL, A.I.B.D.

CERTIFIED PROFESSIONAL BUILDING DESIGNER

DESIGN CONCEPTS

HOUSTON, TEXAS


713.961.2980

SHEET NO.
EO.1

ISSUE FOR PERMIT
01.29.16

DATE:
08.17.05
REVISED:
09.29.15

PLAN NO.
BRYAM ST.
& MONROE ST.

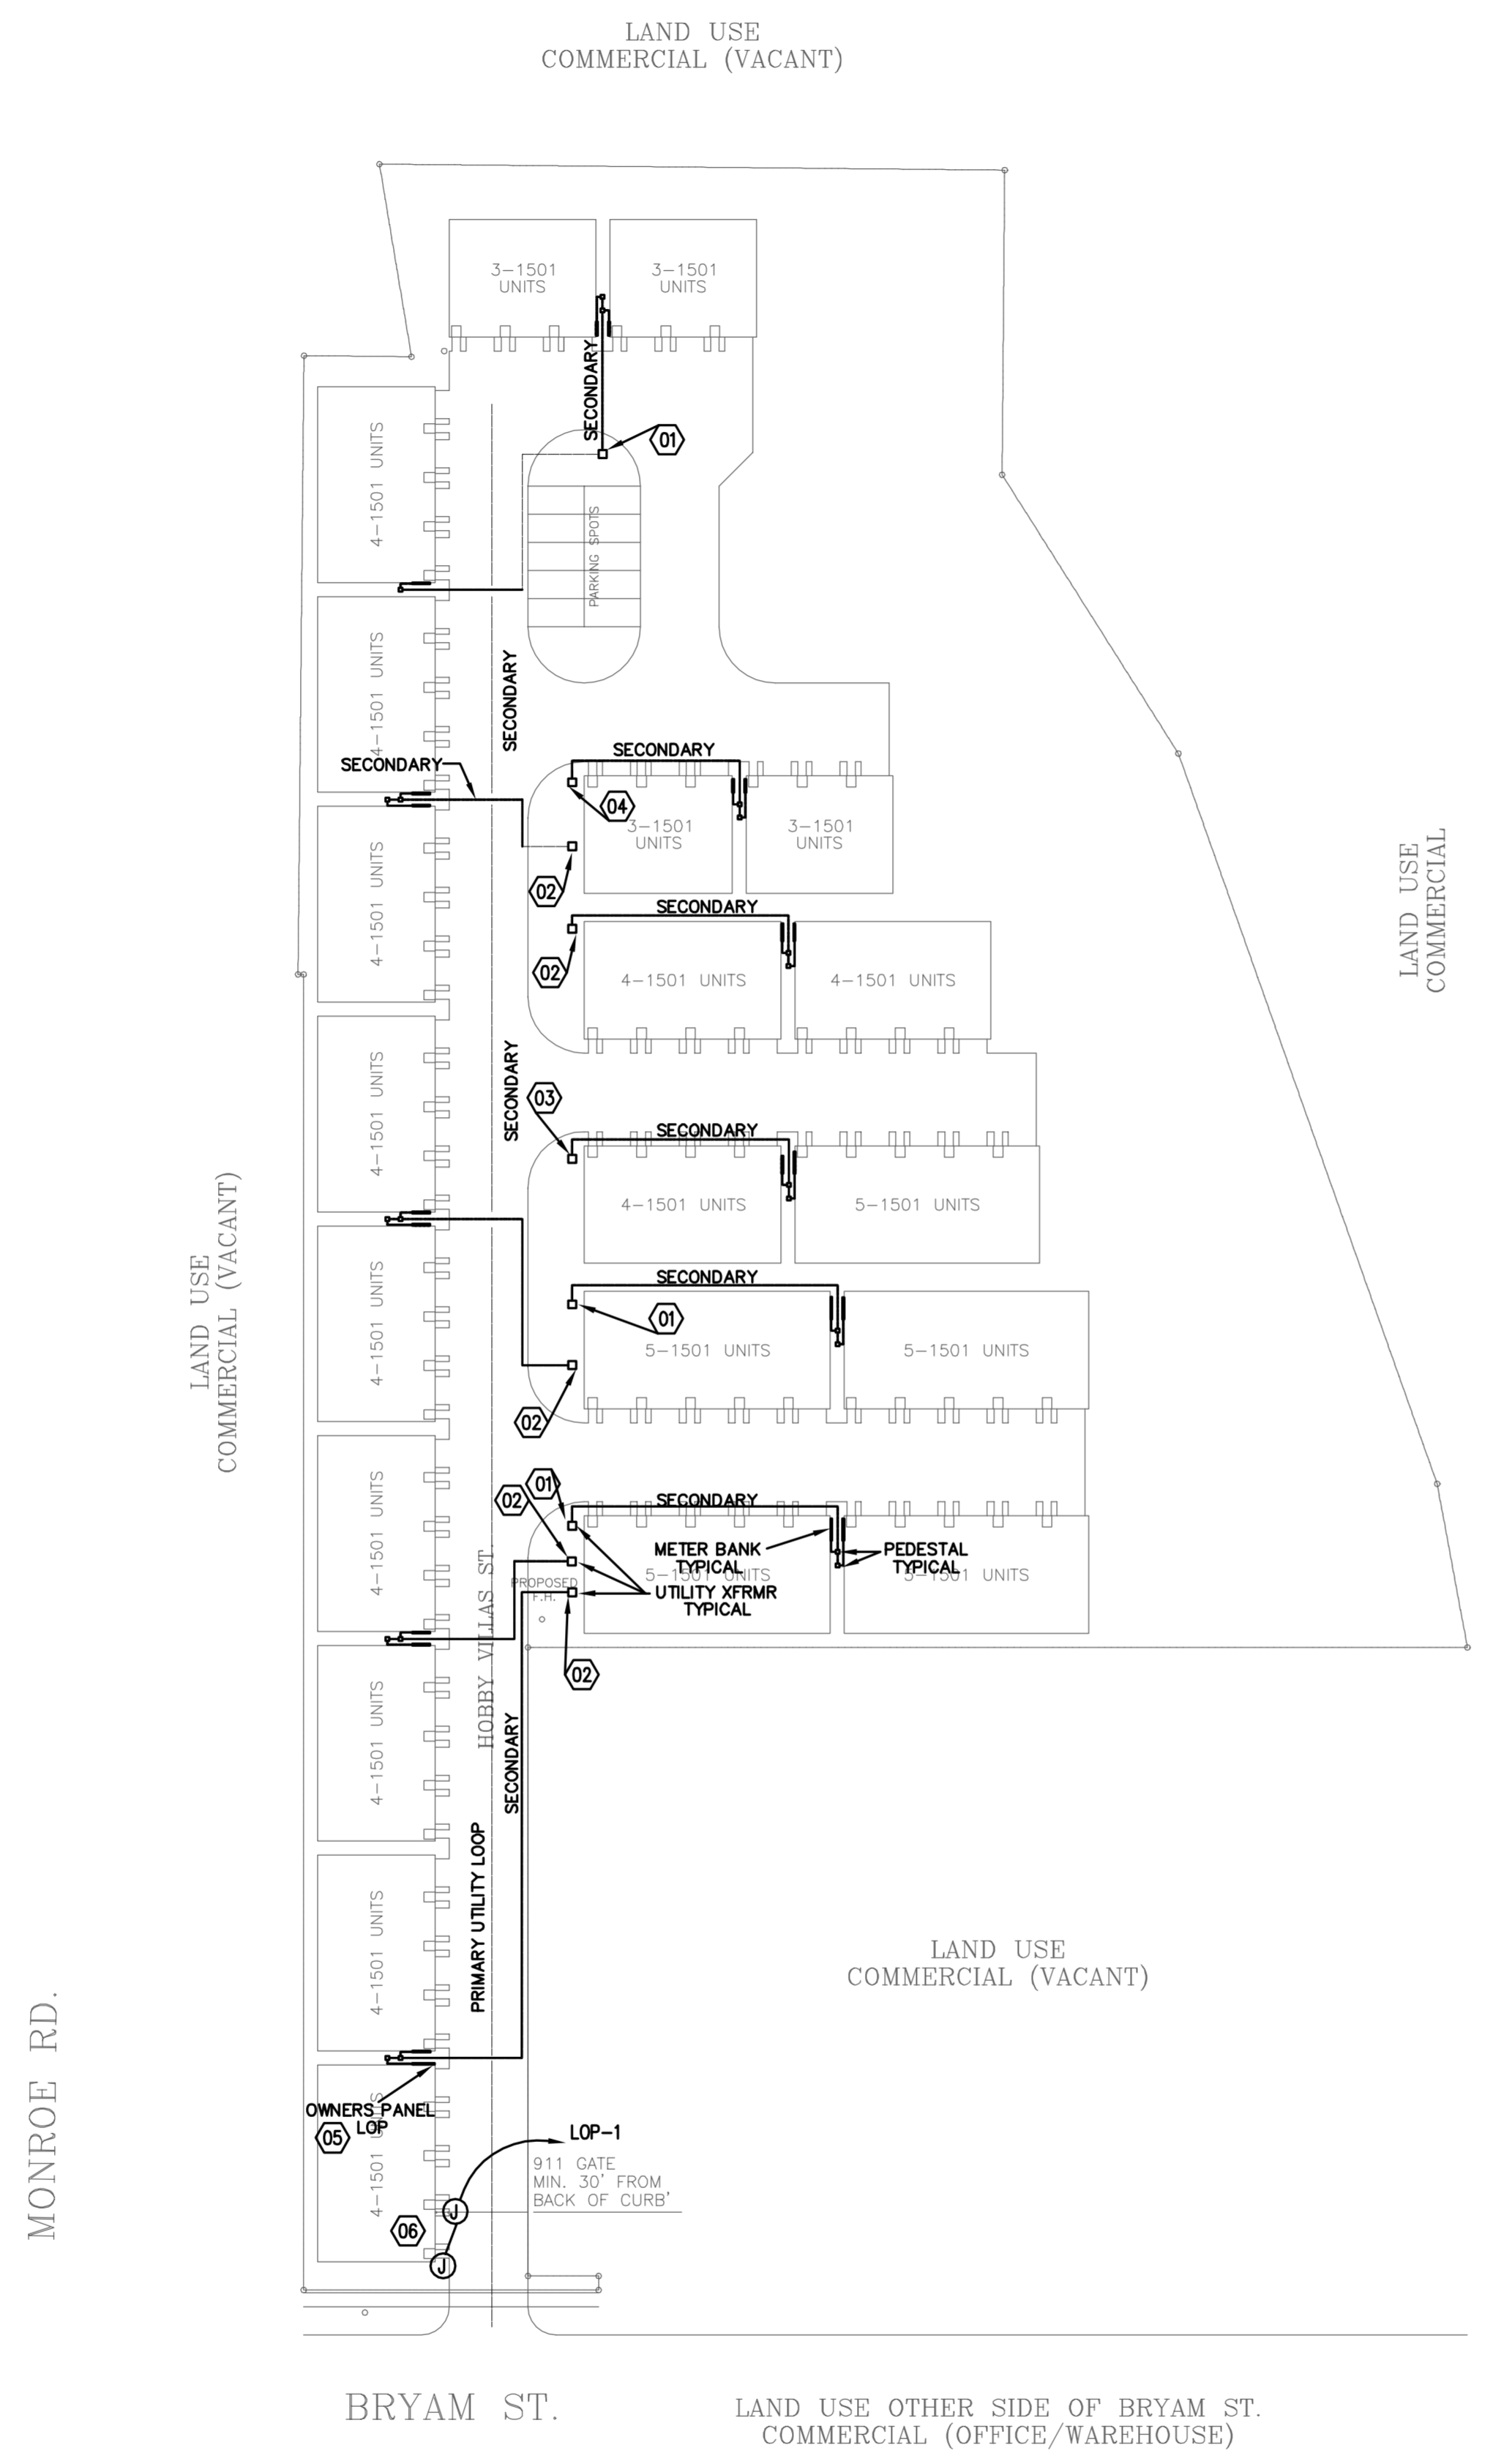

GENERAL NOTES

(A) NONE.

KEYED NOTES

- 01 TRANSFORMER TYPE-1. 10 UNIT LOAD
- 02 TRANSFORMER TYPE-2. 8 UNIT LOAD
- 03 TRANSFORMER TYPE-3. 9 UNIT LOAD
- 04 TRANSFORMER TYPE-4. 6 UNIT LOAD
- 05 OWNERS PANEL TO BE 120/240 1Ø 100A FRAME WITH 50AF. N.R. USED FOR GATE POWER
- 06 PROVIDE CIRCUIT FOR GATE POWER. ADD SECOND J-BOX WHERE INDICATED FOR LOW VOLTAGE WIRING TO GATE CONTROLLER

SITE PLAN
SCALE: 1" = 50'-0"