



PAVILLION BUILDERS

INDEX of DRAWINGS


- C COVER SHEET, SITE PLAN, and ROOF PLAN
- A 1 EXTERIOR ELEVATIONS
- A 2 FLOOR PLANS
- A 3 BUILDING SECTIONS and TYP. WALL SECTION
- A 4 ELECTRICAL PLANS
- A 5 INTERIOR ELEVATIONS
- S 1 FOUNDATION PLAN
- S 2 FIRST FLOOR FRAMING
- S 3 SECOND FLOOR FRAMING
- S 4 ROOF FRAMING
- S 0 FOUNDATION DETAILS and NOTES

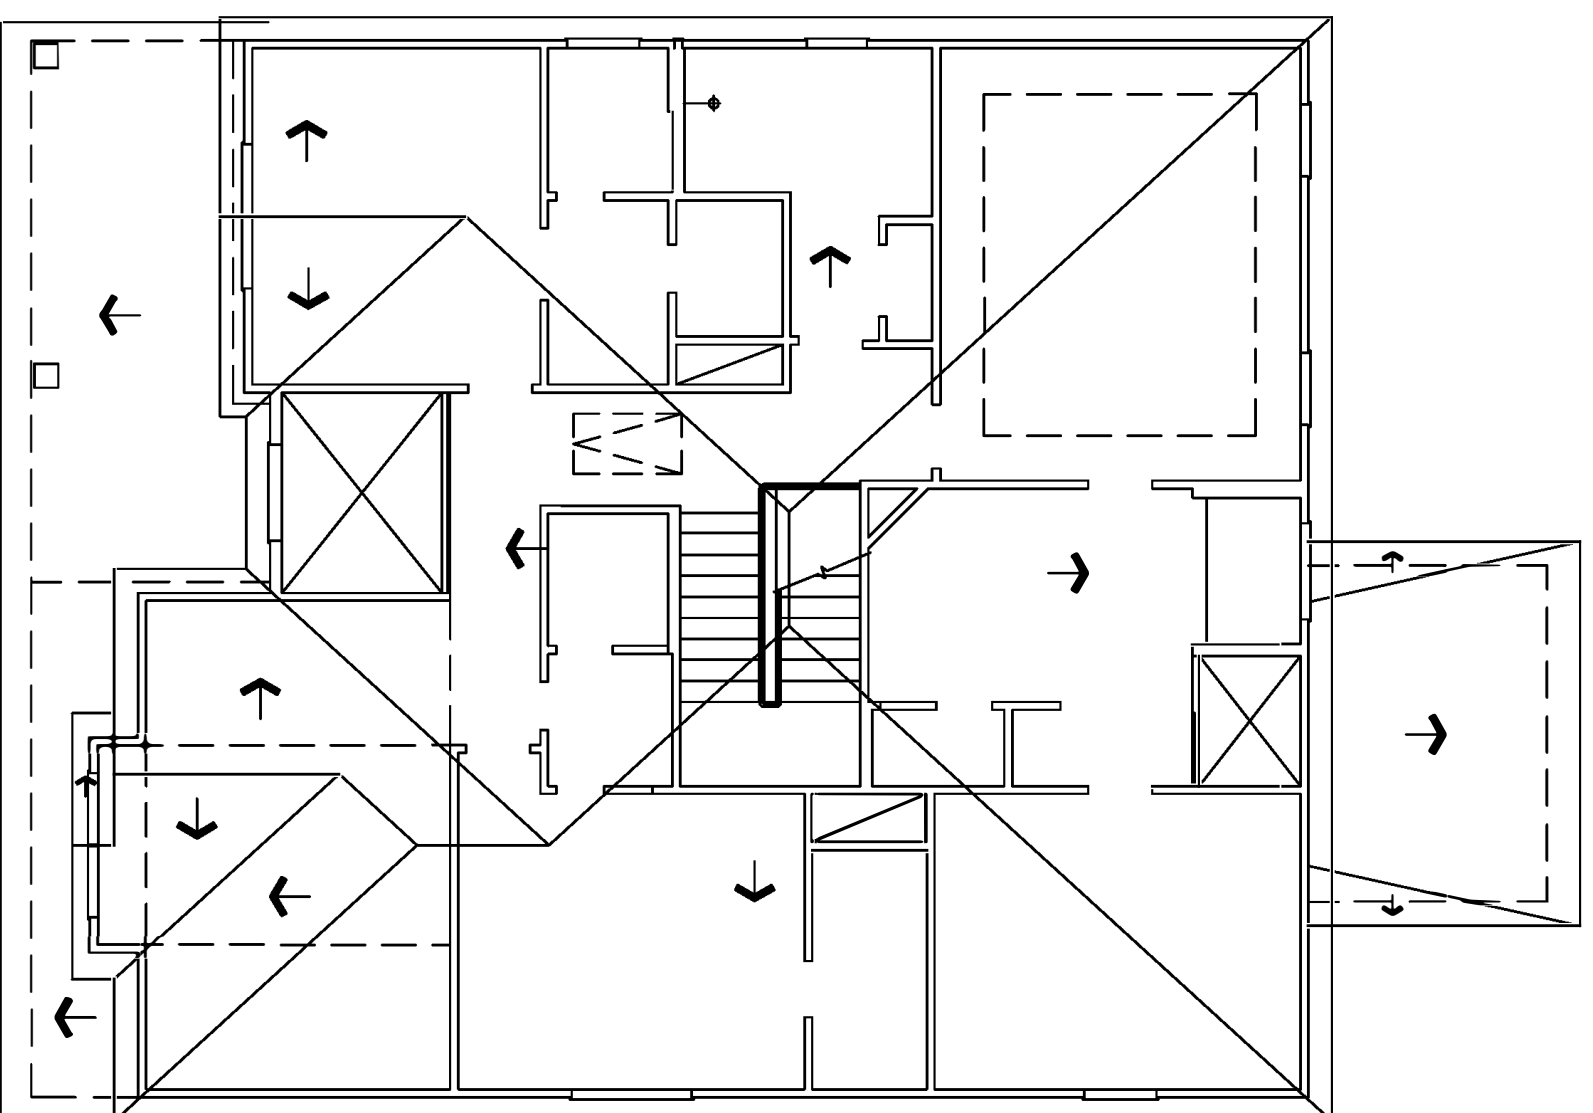

ROOF PLAN
SCALE: 1/8" = 1'-0"

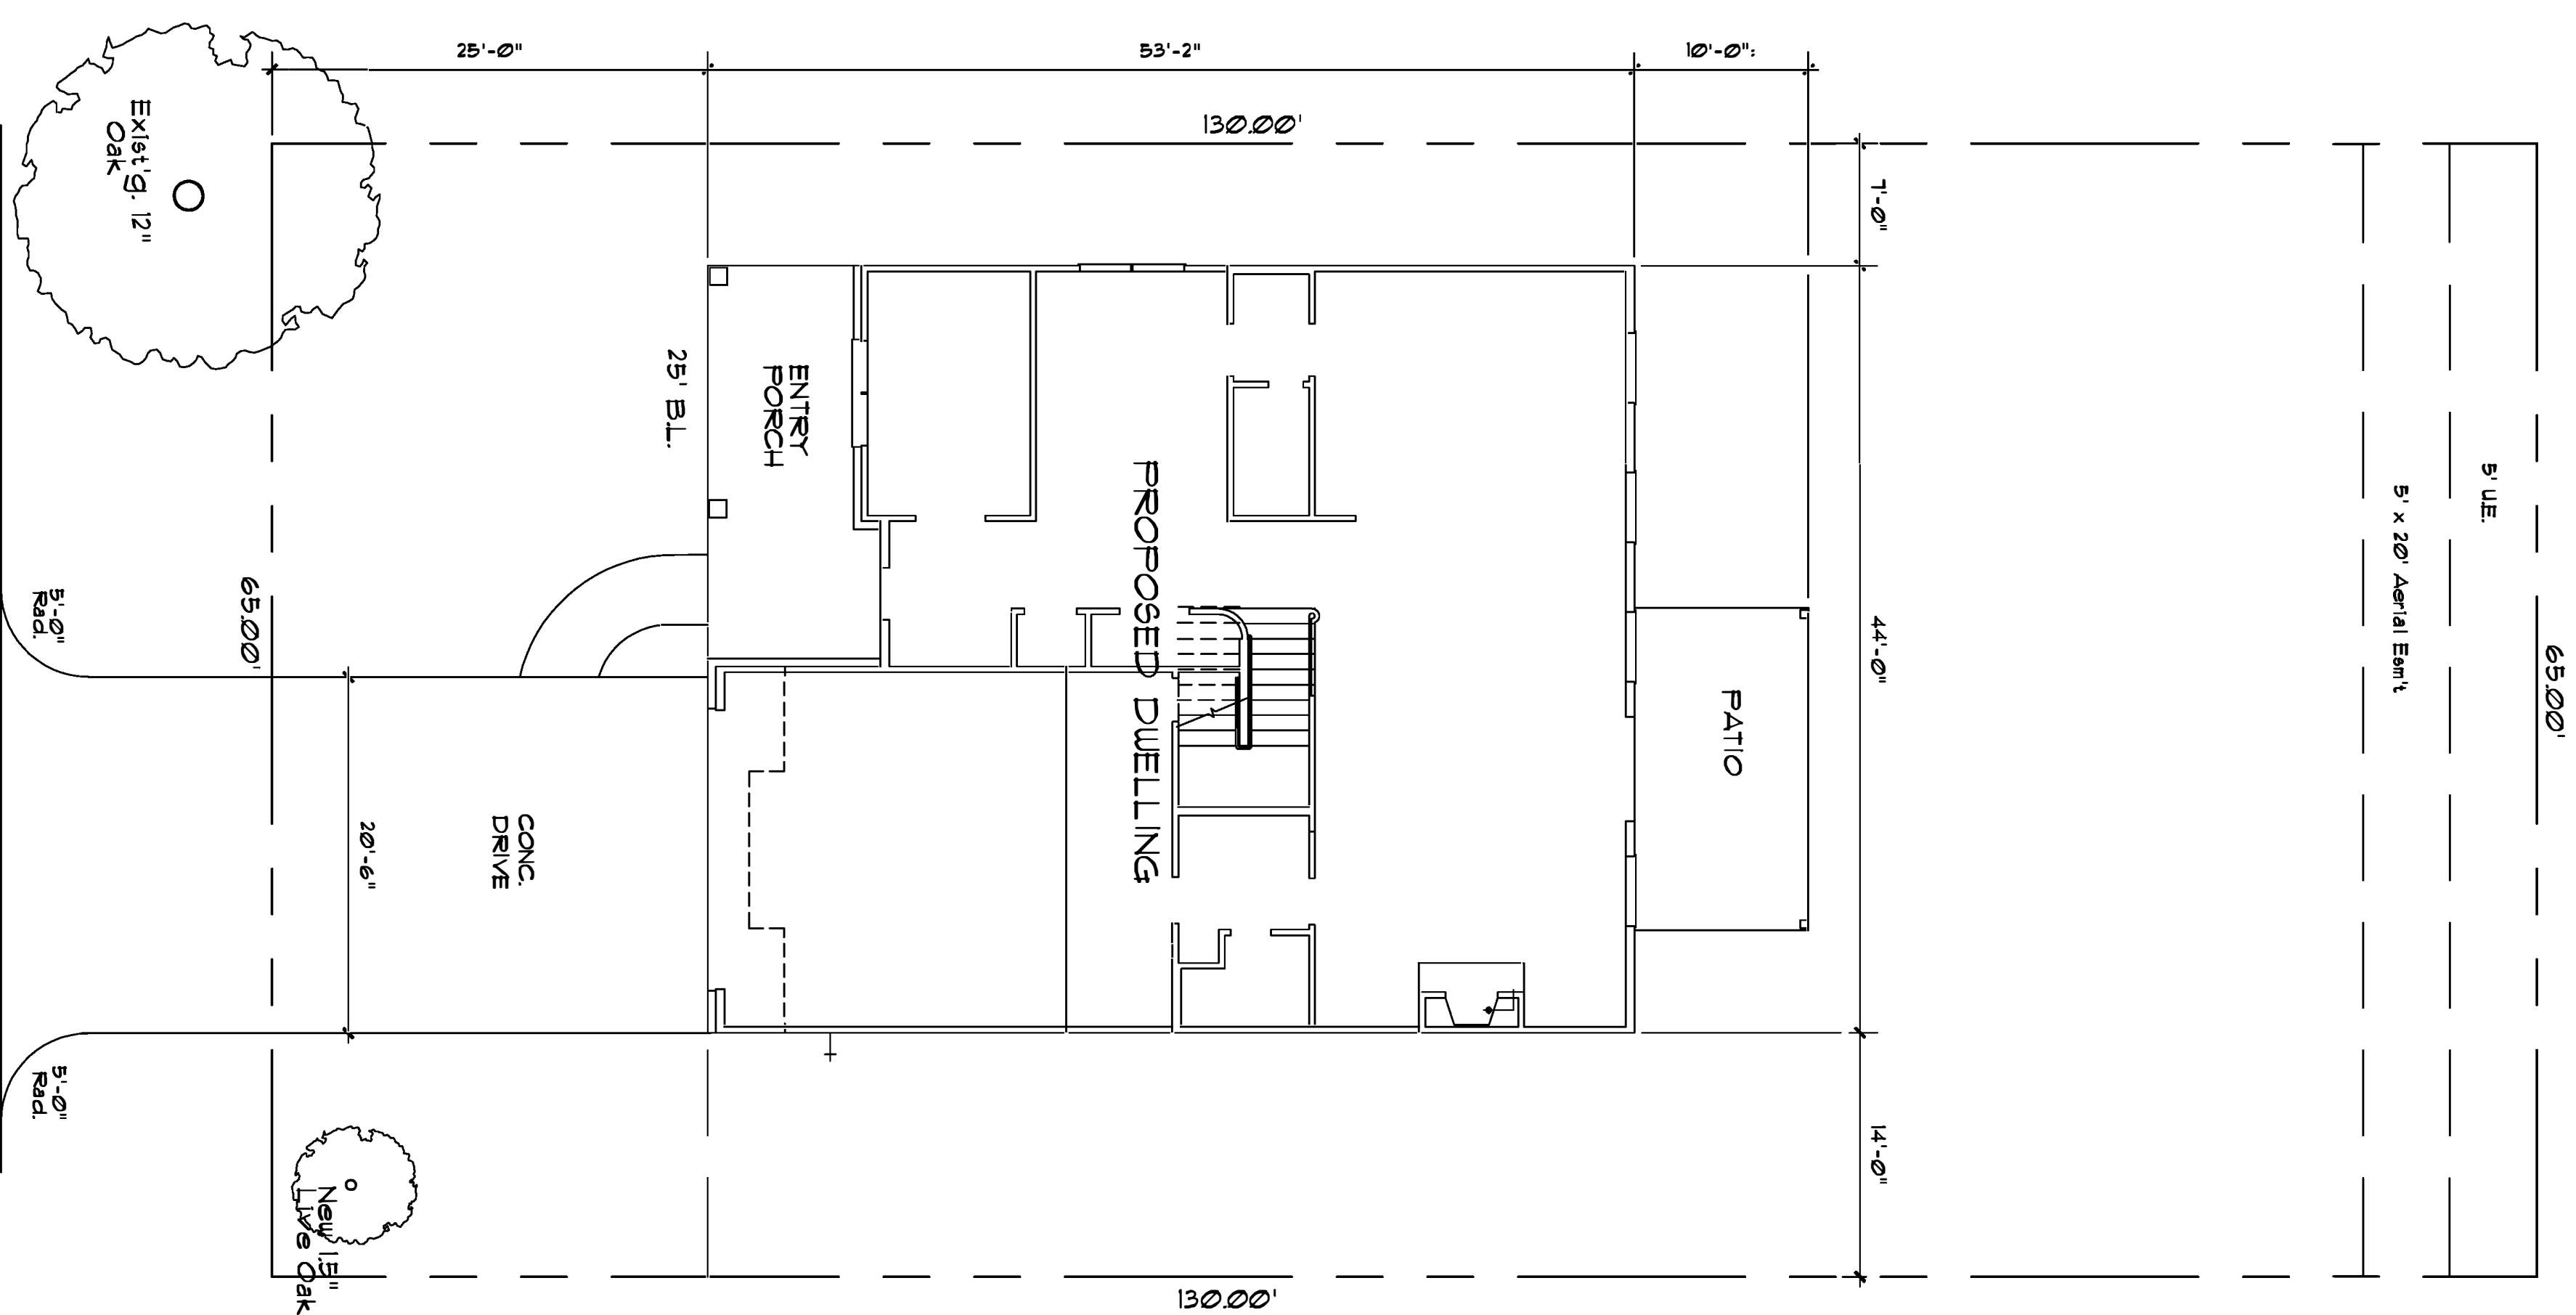


SITE PLAN
SCALE: 1/8" = 1'-0"
9633 CEDARDALE DRIVE
LONG POINT WOODS SUBDIVISION
LOT 2 BLK. 9 SEC. 2
HOUSTON, TX

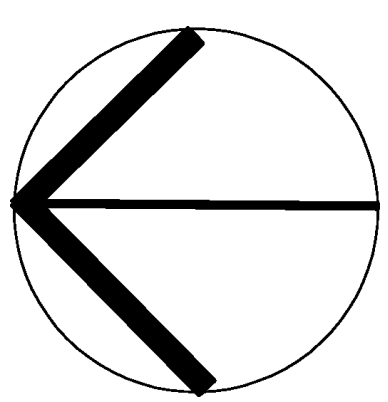

CEDARDALE DRIVE
60' ROW

ADDRESS: 9633 CEDARDALE DRIVE
LOT: 2 BLK: 9 SEC: 2
SUBDIVISION: LONG POINT WOODS

PROJECT: PAVILION BUILDERS
LOCATION: HOUSTON, TEXAS
PRELIM: APPROVED:

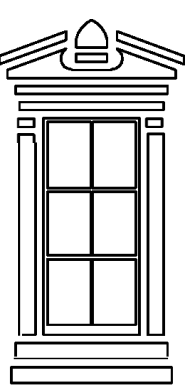

SHEET NO:



DATE: