
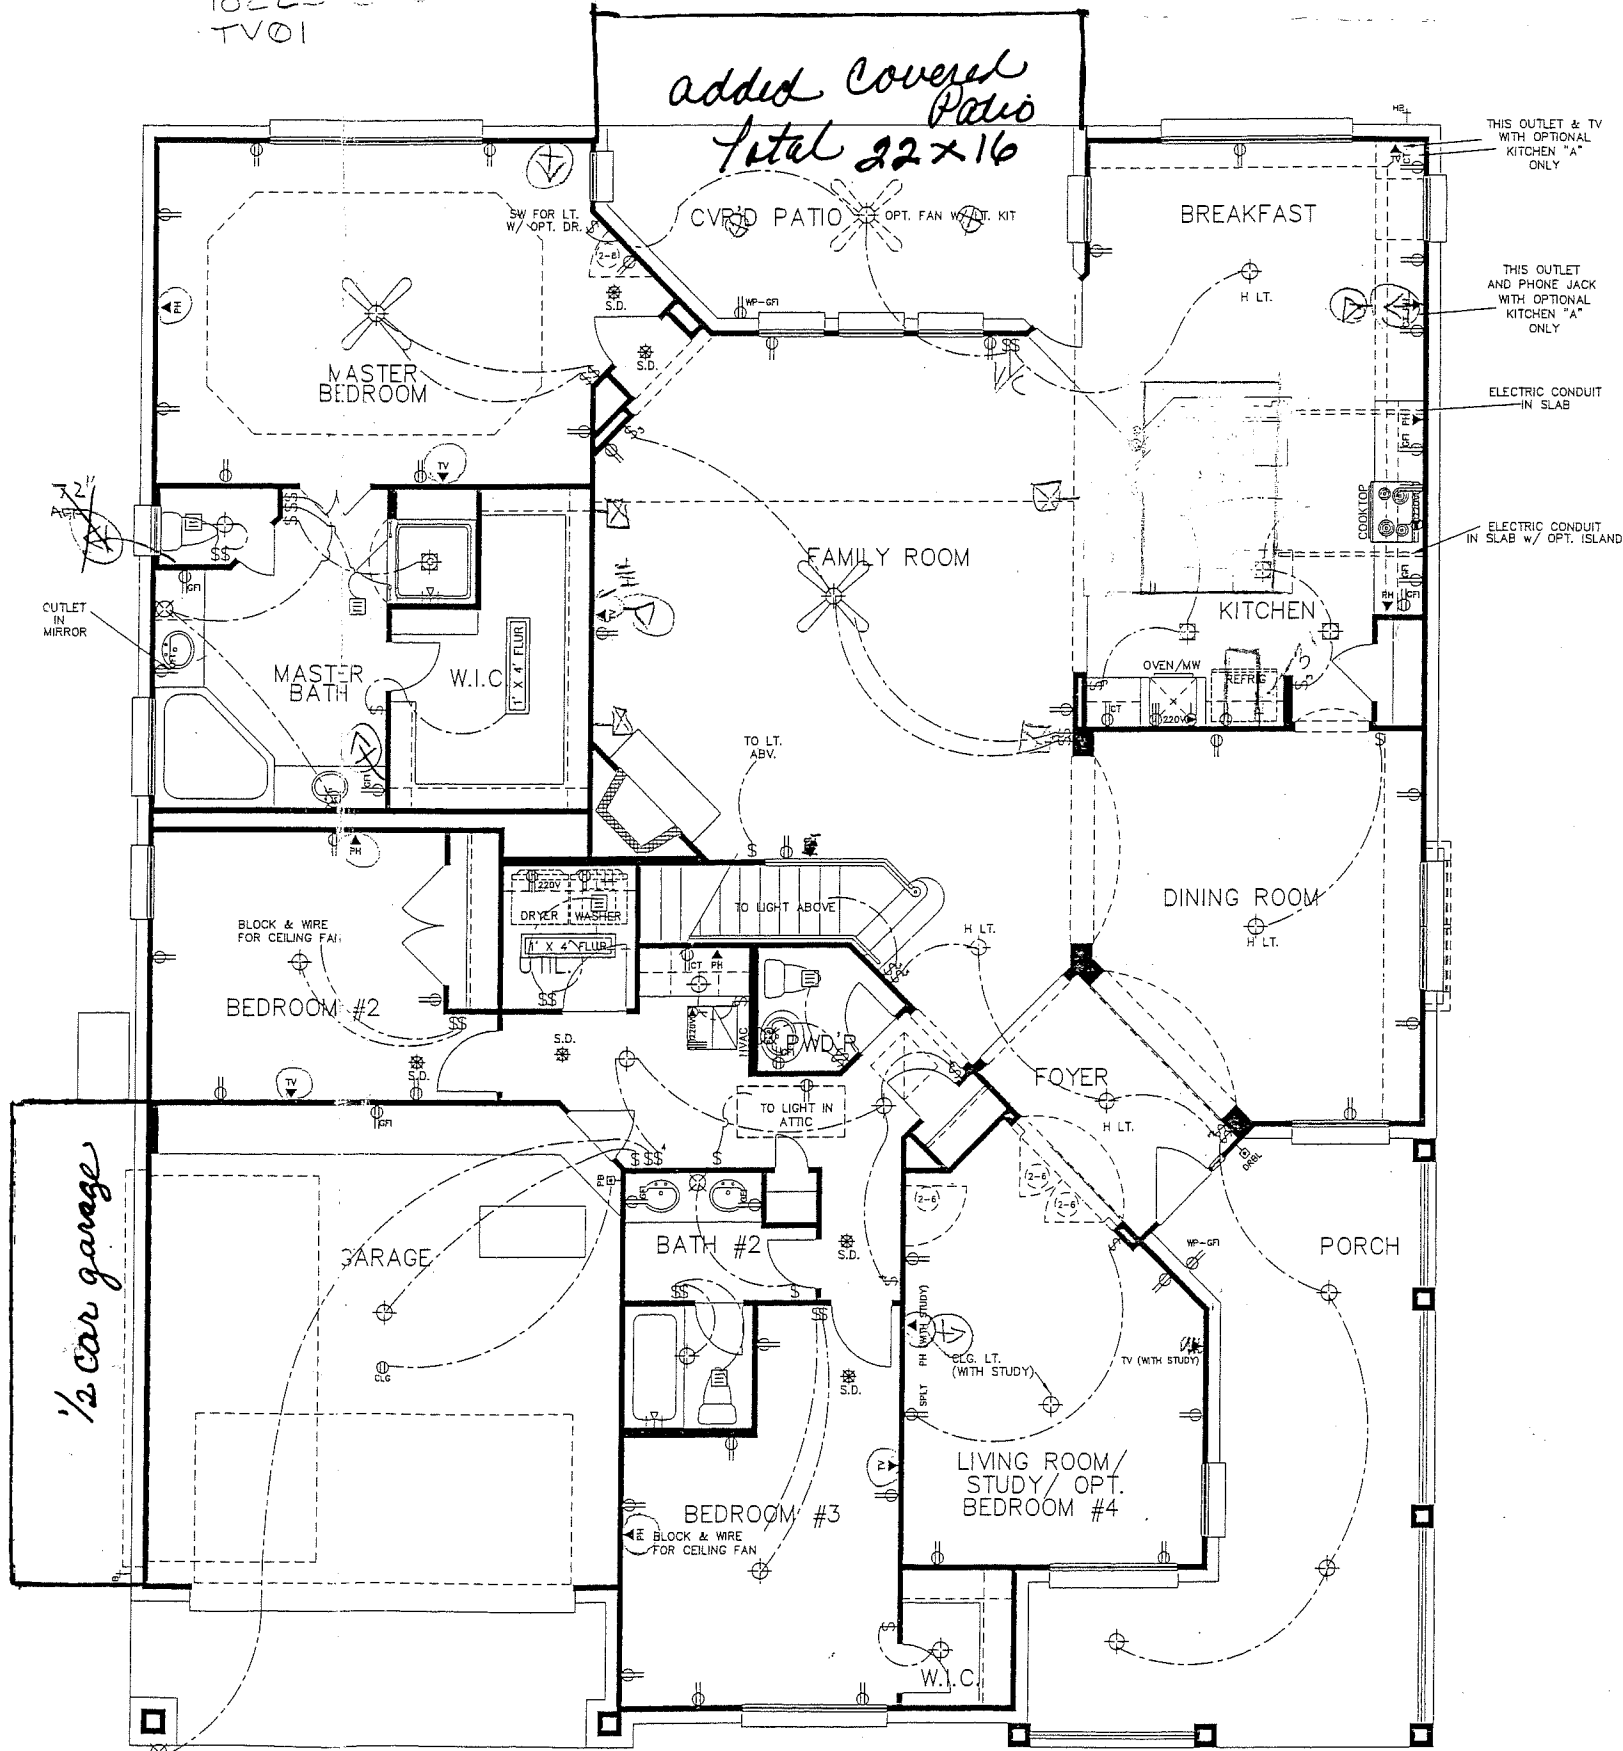
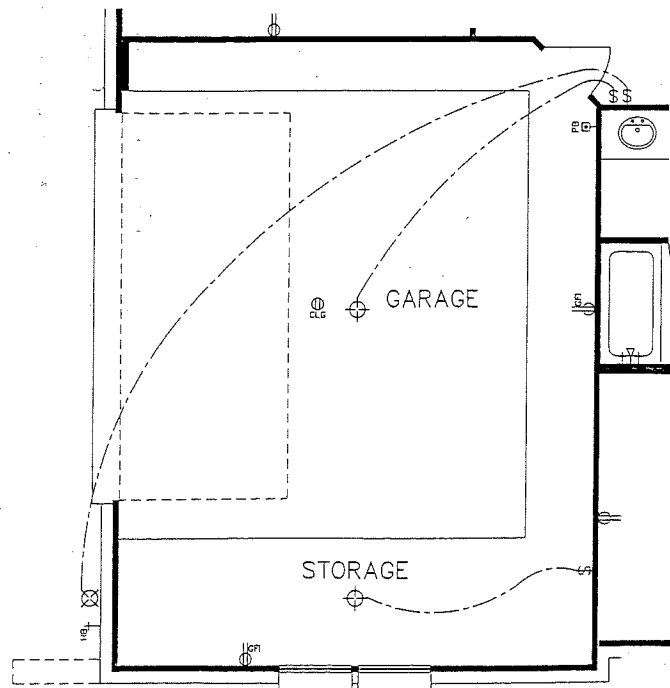
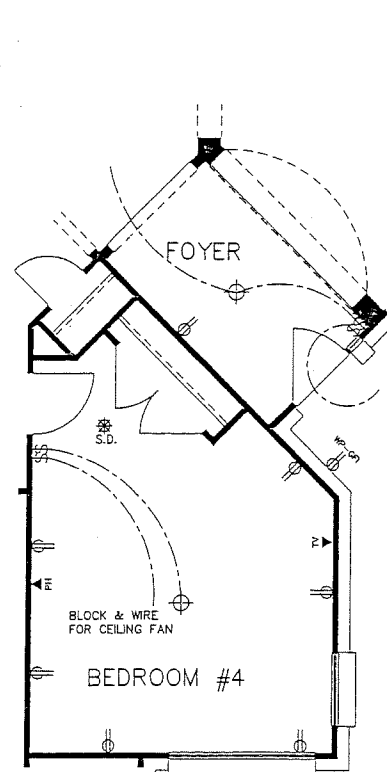
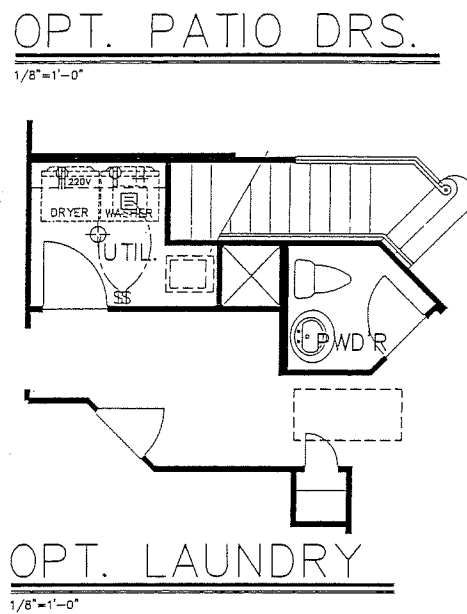


O'TOOLE
18223 STOCKTON
TV01


ELECTRICAL LEGEND	
	SWITCH
	THREE-WAY SWITCH
	FOUR-WAY SWITCH
	RHEOSTAT
	DUPLEX
	COUNTERTOP DUPLEX
	SPLIT WIRED DUPLEX
	QUADRUPLEX
	CEILING DUPLEX
	FLOOR DUPLEX
	PHONE OUTLET
	TV OUTLET
	THERMOSTAT
	SMOKE DETECTOR
	JUNCTION
	220 VOLT OUTLET
	CEILING LIGHT
	RECESSED CEILING LIGHT
	WALL HUNG LIGHT
	EYEBALL LIGHT
	RECESSED EYEBALL LIGHT
	VENT
	VENT AND LIGHT
	HEAT AND LIGHT
	HEAT AND VENT
	HEAT, VENT AND LIGHT
	LANDSCAPING LIGHT
	FLOODLIGHT

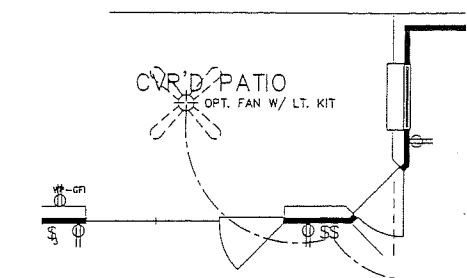

ISSUE DATE	
8-28-01	
REVISIONS	
2.	9-15-01 SS SEE COVER SHT.
3.	1-18-02 DW/SS SEE COVER SHT.
4.	2-4-02 SS SEE COVER SHT.
5.	6-28-02 MN SEE COVER SHT.
6.	9-25-02 EN SEE COVER SHT.
7.	10-2-02 EN SEE COVER SHT.
8.	12-30-02 MN SEE COVER SHT.
9.	5-7-03 GHD SEE COVER SHT.
JOB NO. 2001536-C	
DRAWING NO. 912-A1YA	
DRAWN BY AMERICAD-JE	
AUTOCAD THIRD PARTY SOFTWARE BY AMERICAD THE EXPERTS IN DESIGN	
These drawings are the property of Ashton Woods Homes and are not to be utilized for construction, or copied in part or in whole, without permission from the builder.	
ASHTON WOODS HOMES	
912	
TABULATIONS	
1st FLR. LIV.	2708 S.F.
2nd FLR. LIV.	508 S.F.
TOTAL LIV.	3216 S.F.
GARAGE	419 S.F.
PORCH	553 S.F.
TOTAL COVD.	4188 S.F.
SHEET	
3	
OF	
9	
PLAN NUMBER	
912	

ELECTRICAL
1ST FLOOR PLAN
1/8"=1'-0"

STOCKTON

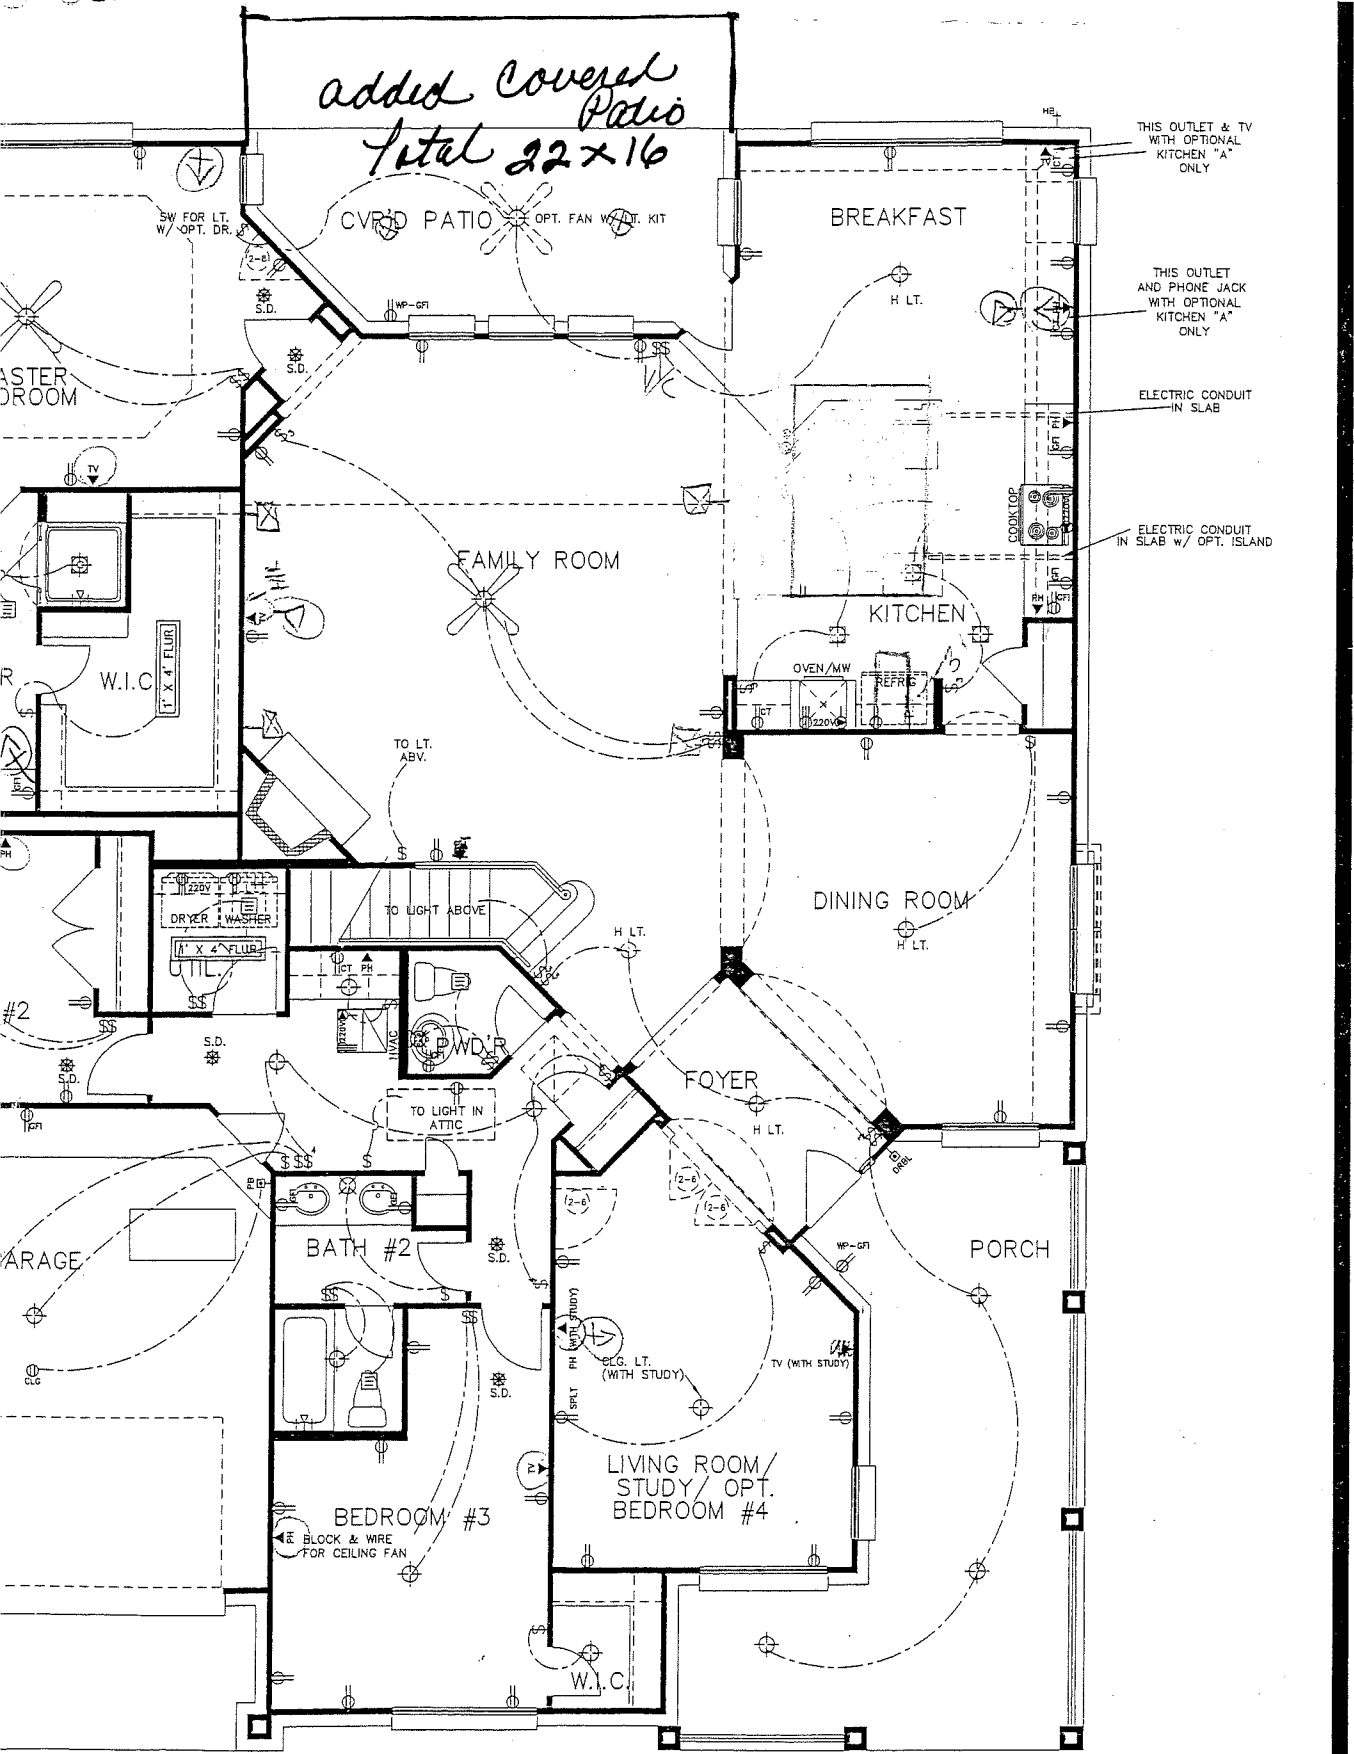

ISSUE DATE
8-28-01

REVISIONS


2.	9-19-01 SS	SEE COVER SHT.
3.	1-18-02 DW/SS	SEE COVER SHT.
4.	2-4-02 SS	SEE COVER SHT.
5.	6-28-02 MN	SEE COVER SHT.
6.	9-25-02 EN	SEE COVER SHT.
7.	10-2-02 EN	SEE COVER SHT.
8.	12-30-02 MN	SEE COVER SHT.
9.	5-7-03 GHD	SEE COVER SHT.

JOB NO.
2001536-C
DRAWING NO.
912-A1YA
DRAWN BY
AMERICAD-JE

AUTOCAD THIRD PARTY SOFTWARE BY
AMERICAD
THE EXPERTISE OF BUILDERS

These drawings are the property of Ashton Woods Homes and are not to be utilized for construction, or copied in part or in whole, without permission from the builder.

**ASHTON
WOODS
HOMES**

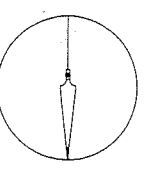

912

TABULATIONS

1st FLR. LIV:	2708 S.F.
2nd FLR. LIV:	508 S.F.
TOTAL LIV:	3216 S.F.
GARAGE:	419 S.F.
PORCH:	553 S.F.
TOTAL COVD:	4188 S.F.

SHEET
3
OF
9
PLAN NUMBER

912

**ELECTRICAL
1ST FLOOR PLAN**

1/8"=1'-0"