




1 KITCHEN

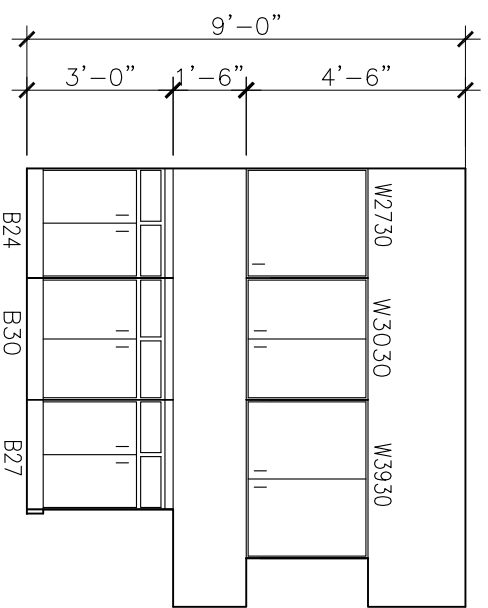


2 KITCHEN ISLAND

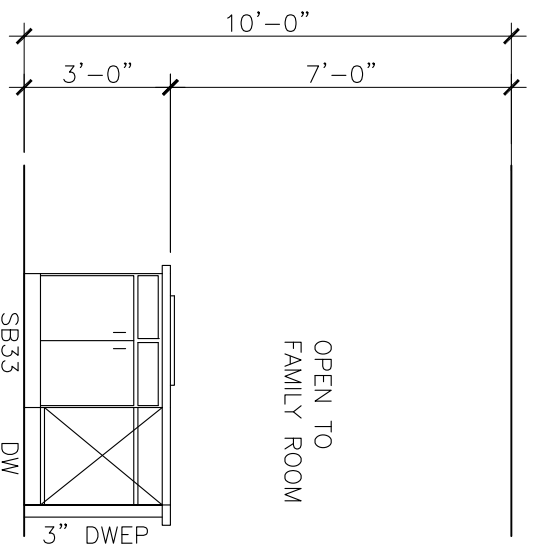

4 KITCHEN

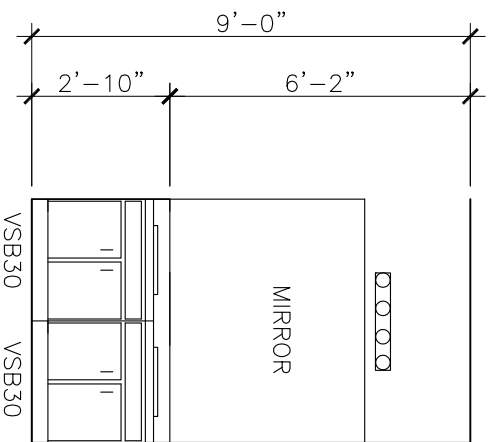

6 M. BATH

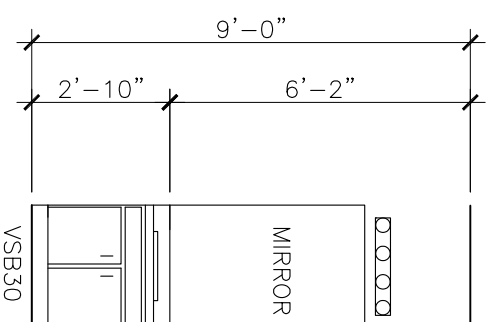


5 BATH 2

# INTERIOR ELEVATIONS



|                     |  |                       |
|---------------------|--|-----------------------|
| <b>CENSEO HOMES</b> |  | Scale<br>1/4" = 1'-0" |
| INTERIOR ELEVATIONS |  | Date<br>01/14/19      |
| Drawing No. 4505    |  | Sheet<br>2 OF 12      |
|                     |  | Rev.<br>1             |


E-MAIL: DESIGN@BRANCO.COM  
PHONE: 713-629-9937

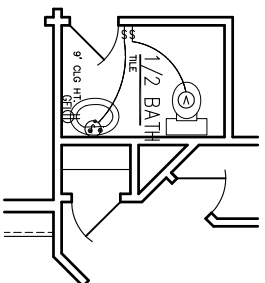

## 1/2 BATH ELECTRICAL PLAN

| LIGHTING FIXTURE SCHEDULE |  |
|---------------------------|--|
| SYMBOL                    | FIXTURE  |
| A                         | SURFACE MOUNTED DISH                               |
| B                         | PORCELAIN SOCKET EXPOSED BULB                      |
| C                         | CEILING MOUNTED ENCLOSED FIXTURE                   |
| D                         | HANGING FIXTURE                                    |
| E                         | 2'-x4' FLUOR. FIXTURE                              |
| F                         | EXTERIOR WALL MOUNTED BRACKET                      |
| G                         | EXTERIOR CEILING MOUNTED FIXTURE                   |
| H                         | BATHROOM FOUR BULB STRIP FIXTURE                   |
| J                         | BATHROOM THREE BULB STRIP FIXTURE                  |
| K                         | RECESSED CAN                                       |
| L                         | FLOOD LIGHTS                                       |
| M                         | EXH FAN/LIGHT COMBO                                |
| N                         | WALL WASHER FIXTURE                                |
| P                         | PORCELAIN SOCKET EXPOSED BULB, WALL MTD.           |
| Q                         | WATERPROOF RECESSED CAN                            |
| R                         | 1'-x4' FLUOR FIXTURE                               |
| S                         | EXTERIOR RECESSED CAN                              |
| T                         | INTERIOR WALL MOUNTED BRACKET                      |
| U                         | CHANDELIER   |
| V                         | EXHAUST FAN  |
| X                         | BATHROOM FIVE BULB STRIP FIXTURE UNDER THE COUNTER |
| Z                         |  |

| ELECTRICAL LEGEND |   |
|-------------------|---|
|                   | SWITCH                                    |
|                   | 3-POLE SWITCH                             |
|                   | 4-POLE SWITCH                             |
|                   | LIGHT FIXTURE                             |
|                   | RE. FIXTURE SCHEDULE                      |
|                   | SMOKE DETECTOR                            |
|                   | CHIMES                                    |
|                   | PUSH BUTTON                               |
|                   | PHONE JACK                                |
|                   | TELEVISION JACK                           |
|                   | GAS                                       |
|                   | EXHAUST FAN                               |
|                   | HOSE BIBB                                 |
|                   | CEILING FAN WITH LIGHT KIT                |
|                   | CEILING FAN                               |
|                   | SWITCH TOP POLE ONLY                      |
|                   | 120V RECEPTACLE                           |
|                   | 220V RECEPTACLE                           |
|                   | GROUND FAULT INTERRUPTOR                  |
|                   | WEATHER PROOF W/ GROUND FAULT INTERRUPTOR |

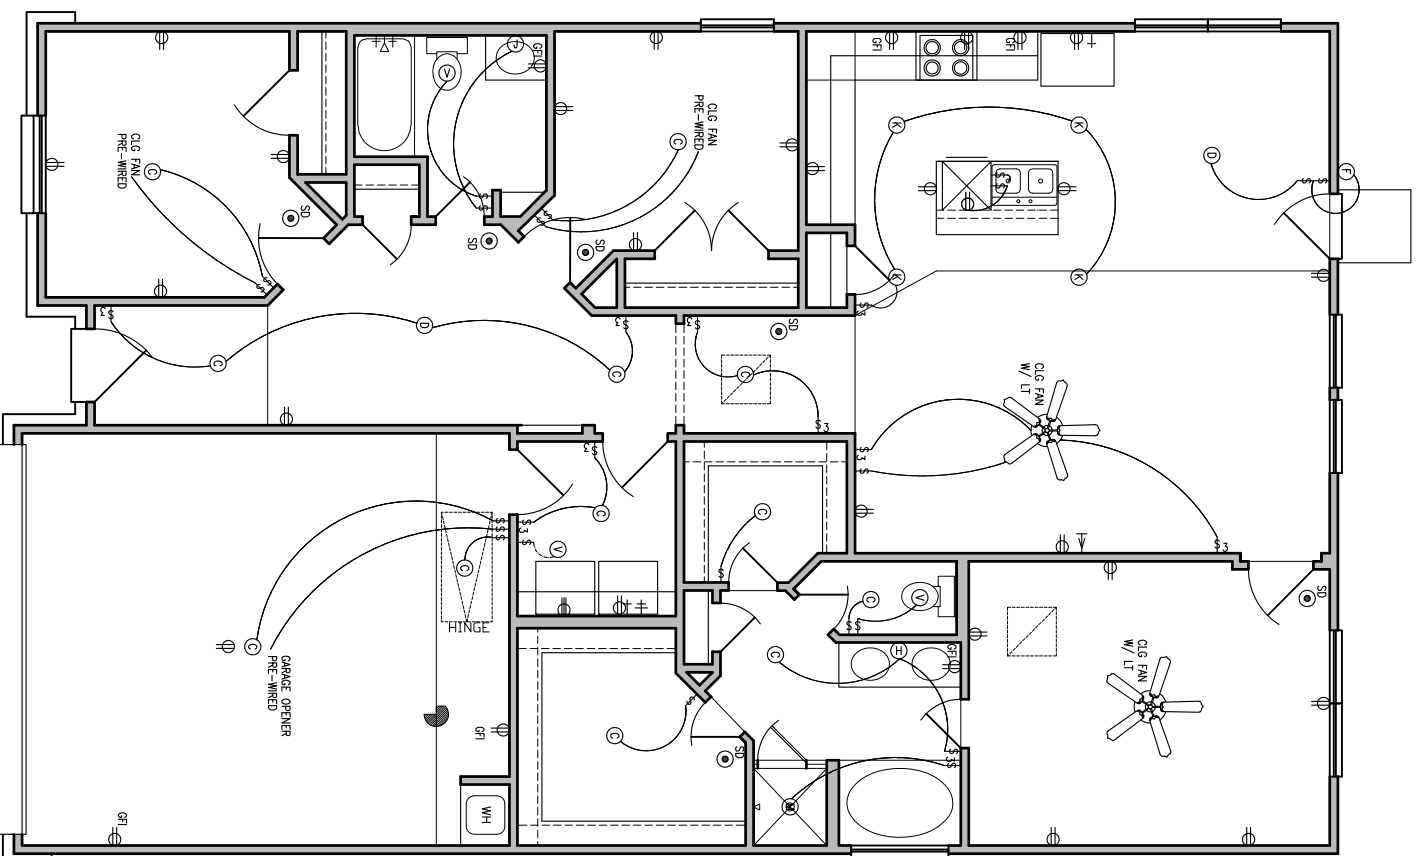


## ELECTRICAL PLAN




|                     |  |              |
|---------------------|--|--------------|
| <b>CENSEO HOMES</b> |  | Scale        |
| ELECTRICAL PLAN     |  | 1/8" = 1'-0" |
| Date                |  | 01/14/19     |
| Sheet               |  | 3 OF 12      |
| Drawing No.         |  | Rev.         |
| 4505                |  | 1            |



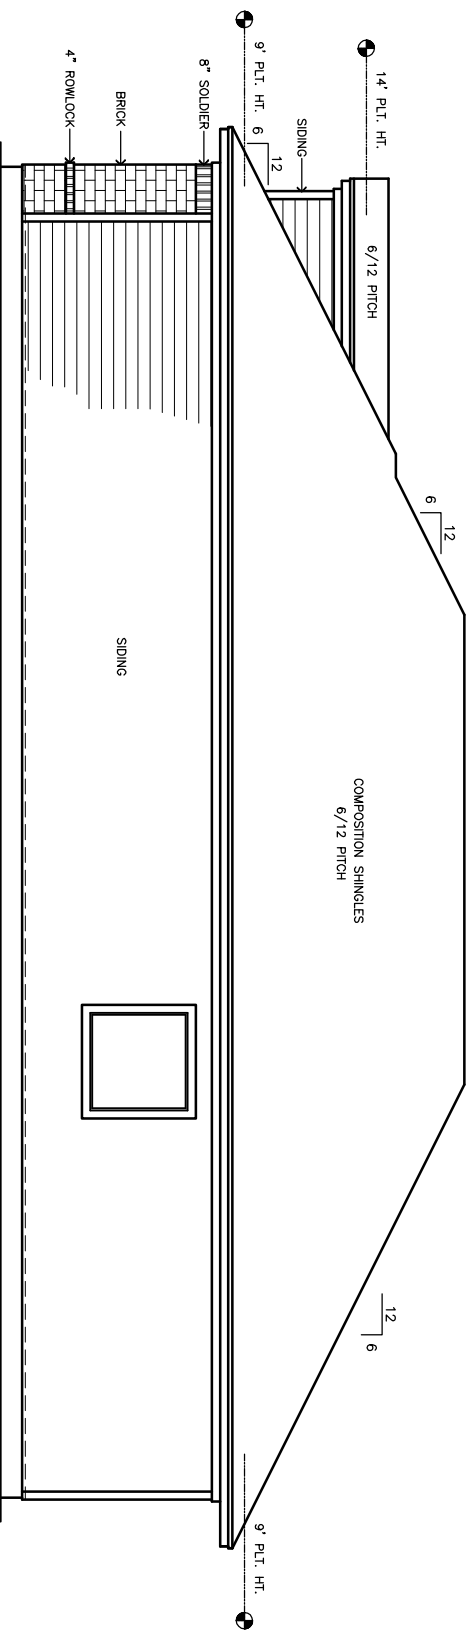

RIGHT ELEVATION A

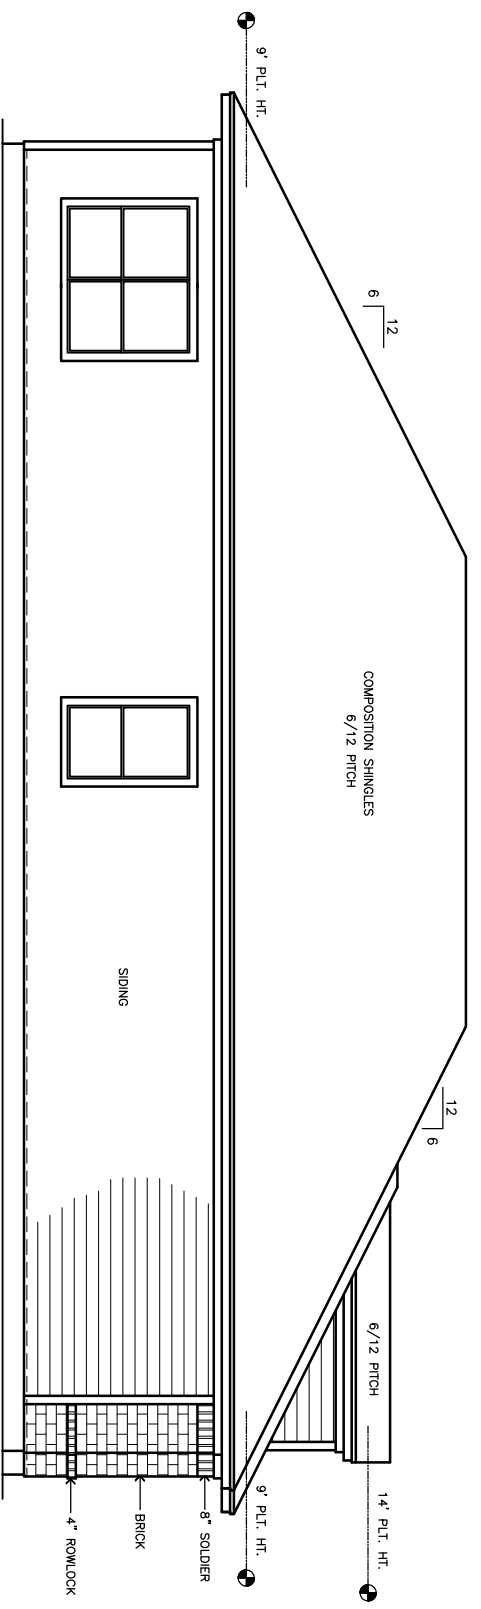


LEFT ELEVATION A



E-MAIL: DESIGN@BRANCODESIGN.COM  
PHONE: 713-928-9937

|  |              |
|--|--------------|
| <b>CENSO HOMES</b>                     |              |
| ELEVATION A<br>RIGHT & LEFT ELEVATIONS |              |
| Scale                                  | 1/8" = 1'-0" |
| Date                                   | 01/14/19     |
| Sheet                                  | 5 OF 12      |
| Rev.                                   | 1            |
| Drawing No.                            | 4505         |

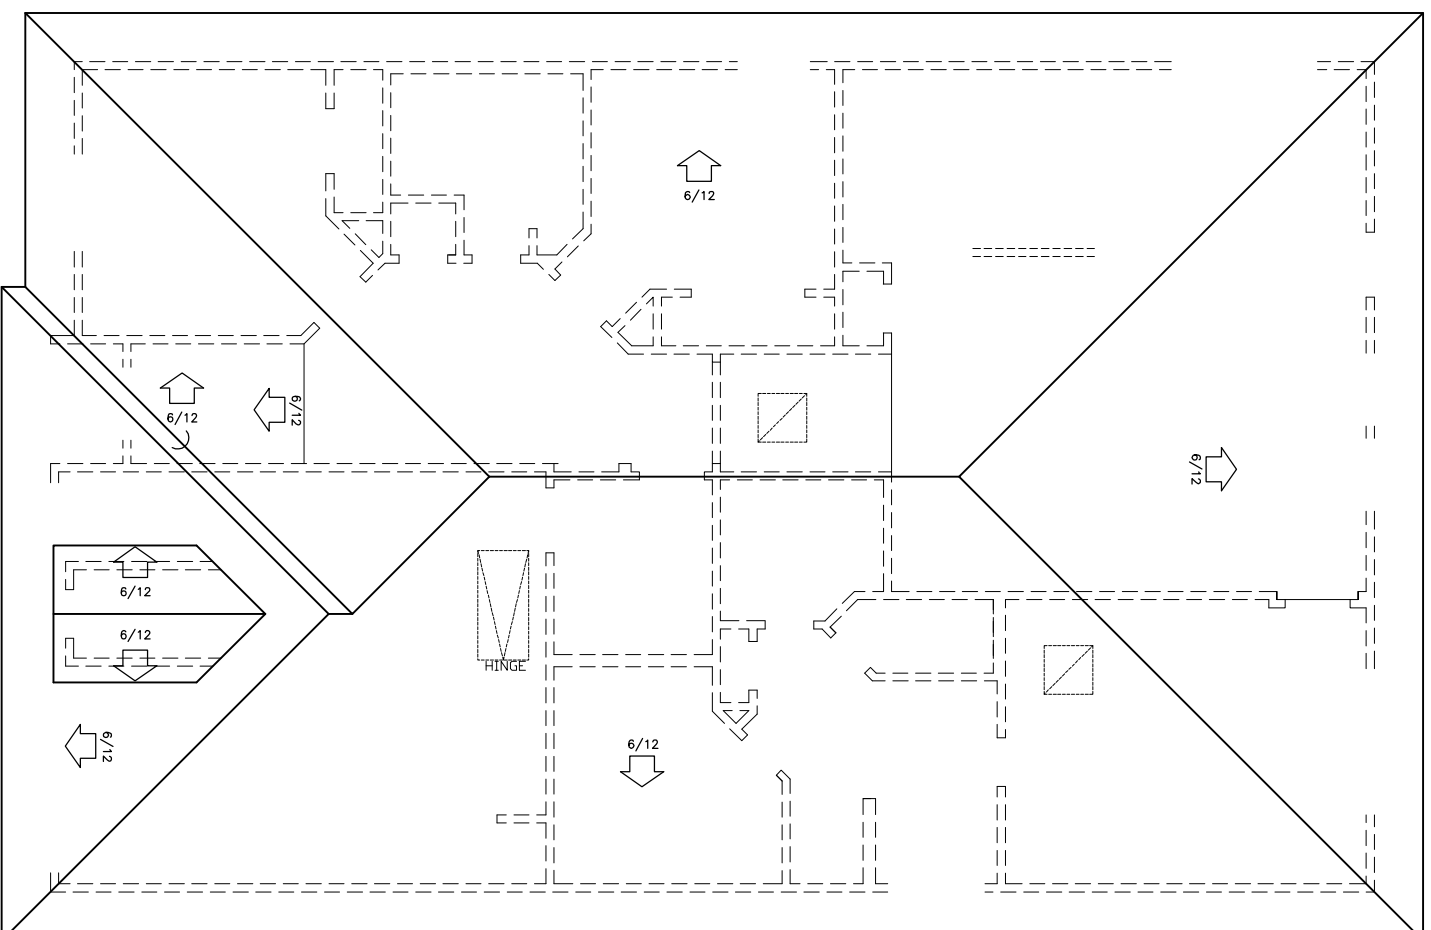


**ELEVATION A  
ROOF PLAN**

NOTES:  
6/12 PITCH = 1'-6" OAK (TP)


**BRANCO  
DESIGN**

E-MAIL: DESIGN@BRANCODESIGN.COM  
PHONE: 713-525-9937

|                                  |       |              |
|----------------------------------|-------|--------------|
| <b>CENSO HOMES</b>               | Scale | 1/8" = 1'-0" |
| <b>ELEVATION A<br/>ROOF PLAN</b> | Date  | 01/14/19     |
|                                  | Sheet | 6 OF 12      |
| Drawing No. 4505                 | Rev.  | 1            |

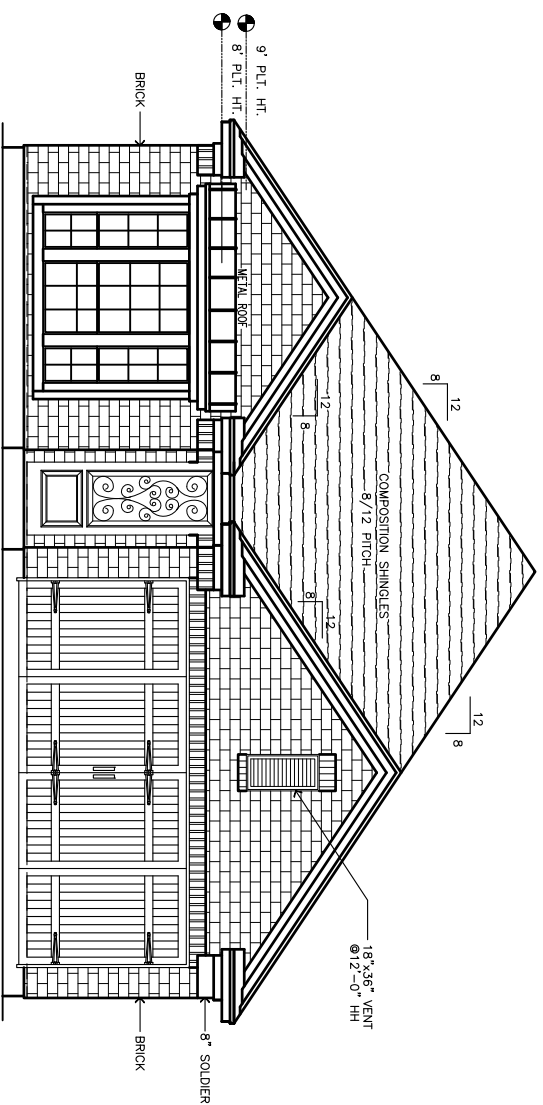


**FRONT ELEVATION B**

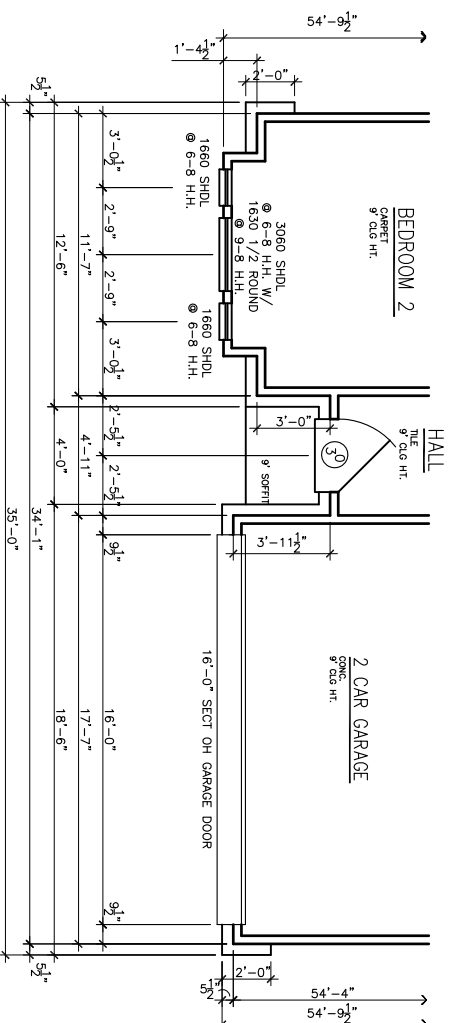

**ELEVATION B  
PARTIAL FLOOR PLAN**

9'-0" NOM. P.L.T. HT. TYP. UNO  
6'-8" WINDOW HEADER HEIGHT TYP. UNO.

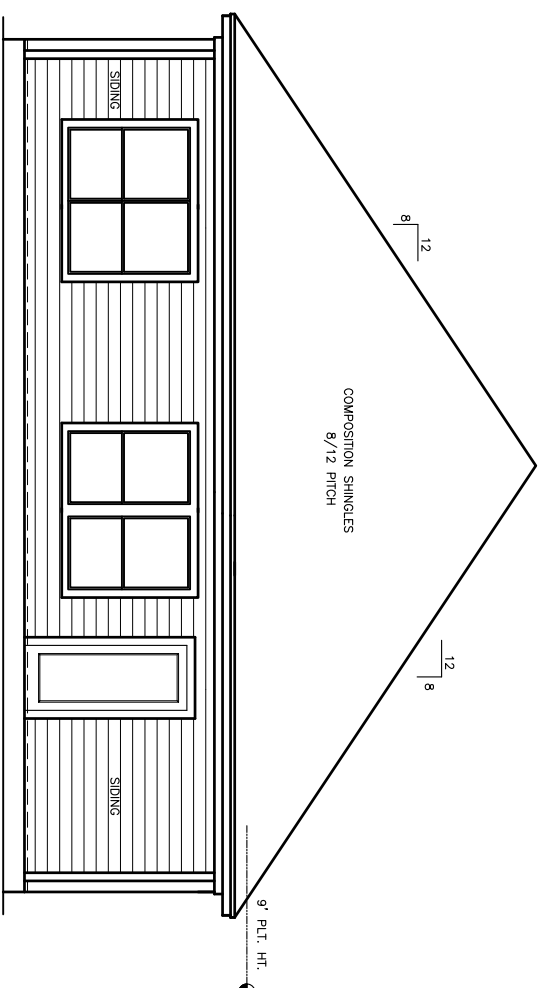


**REAR**




|  |              |
|--|--------------|
| <b>CENSEO HOMES</b>                    |              |
| ELEVATION B<br>FRONT & REAR ELEVATIONS |              |
| Scale                                  | 1/8" = 1'-0" |
| Date                                   | 01/14/19     |
| Sheet                                  | 7 OF 12      |
| Rev.                                   | 1            |

E-MAIL: DESIGN@BRANCO.COM  
PHONE: 713-629-9937

Drawing No. 4505

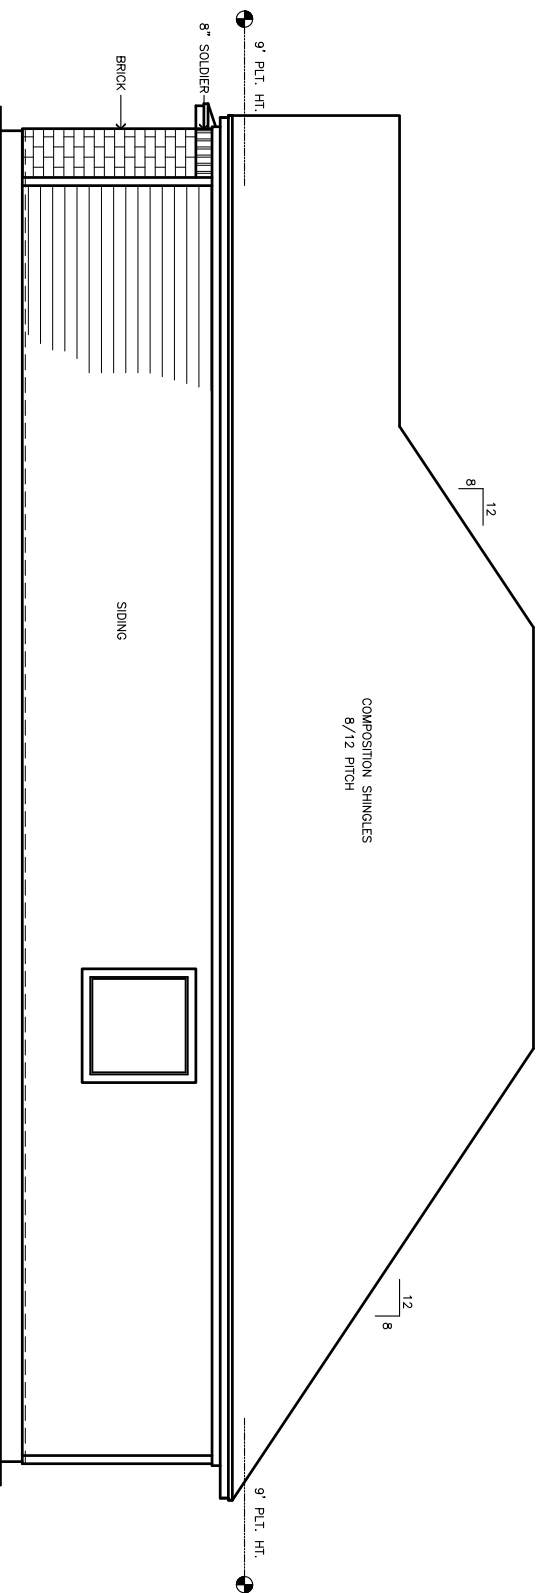

RIGHT ELEVATION B

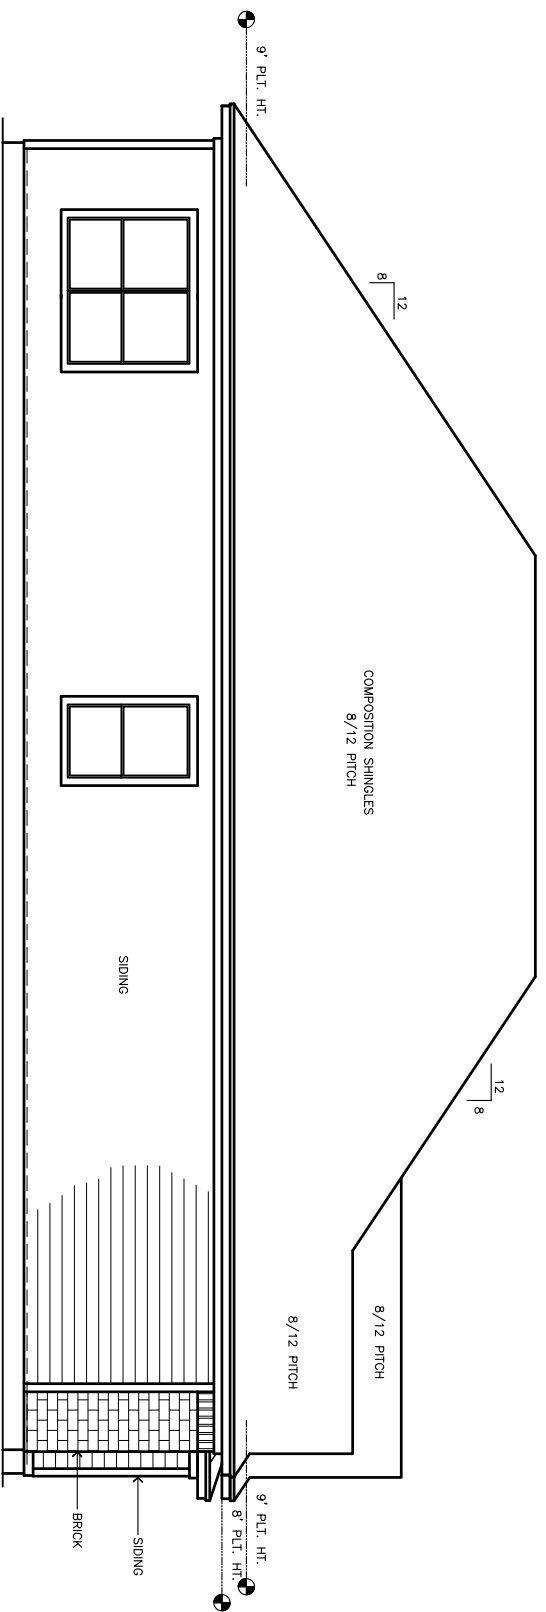


LEFT ELEVATION B



|                         |  |              |
|-------------------------|--|--------------|
| <b>CENSEO HOMES</b>     |  | Scale        |
| ELEVATION B             |  | 1/8" = 1'-0" |
| RIGHT & LEFT ELEVATIONS |  | Date         |
| Drawing No. 4505        |  | 01/14/19     |
|                         |  | Sheet        |
|                         |  | 8 OF 12      |
|                         |  | Rev.         |
|                         |  | 1            |



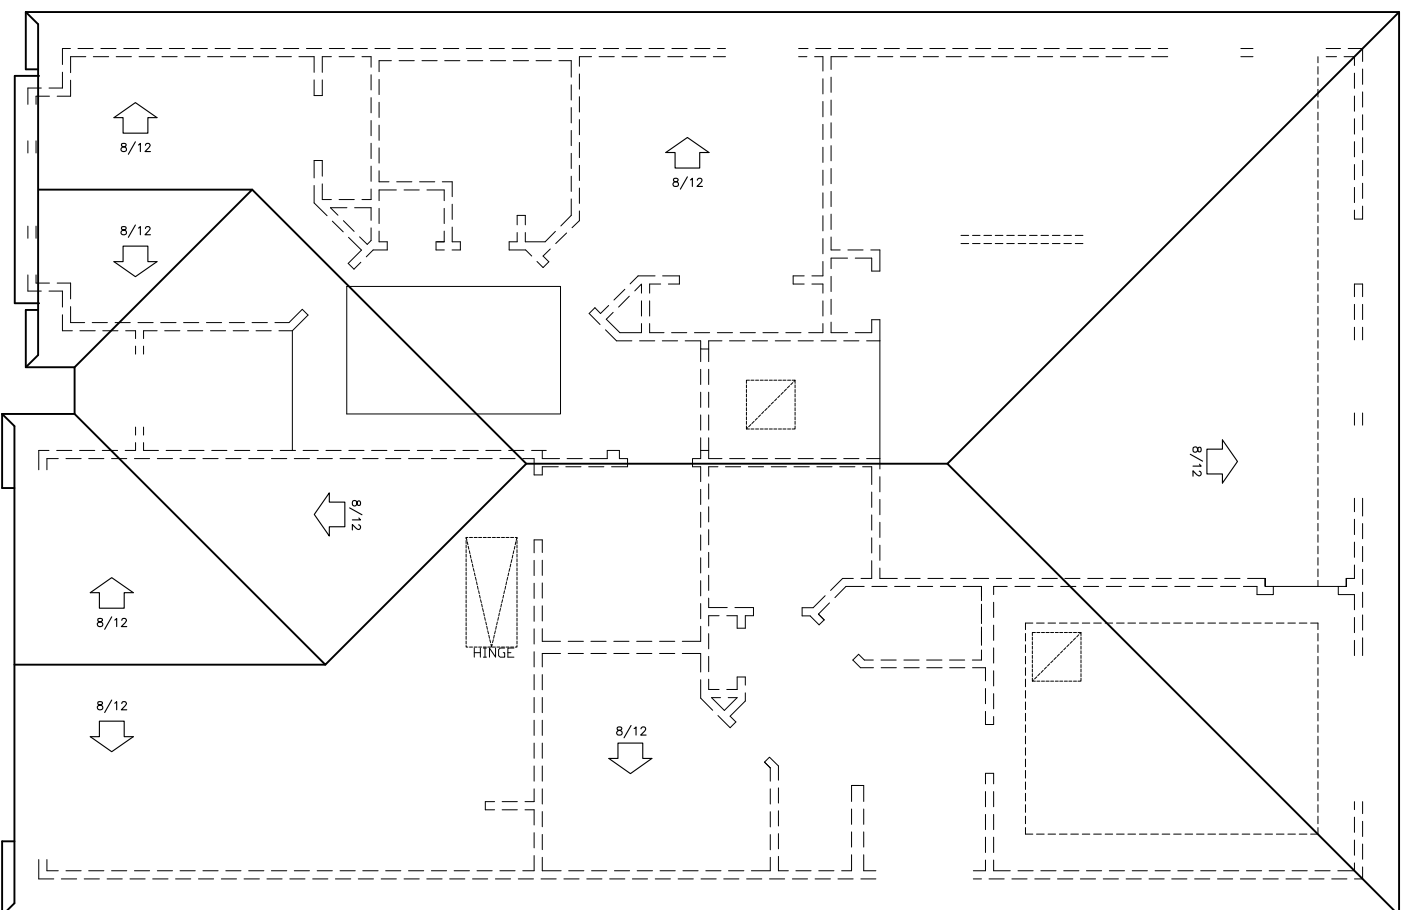


**ELEVATION B  
ROOF PLAN**

NOTES:  
8/12 PITCH = 1'-6" O.A. (TP)


**BRANCO  
DESIGN**

E-MAIL: DESIGN@BRANCO.COM  
PHONE: 713-629-9937

|                          |                       |
|--------------------------|-----------------------|
| <b>CENSEO HOMES</b>      | Scale<br>1/8" = 1'-0" |
| ELEVATION B<br>ROOF PLAN | Date<br>01/14/19      |
| Drawing No.<br>4505      | Sheet<br>9 OF 12      |
|                          | Rev.<br>1             |

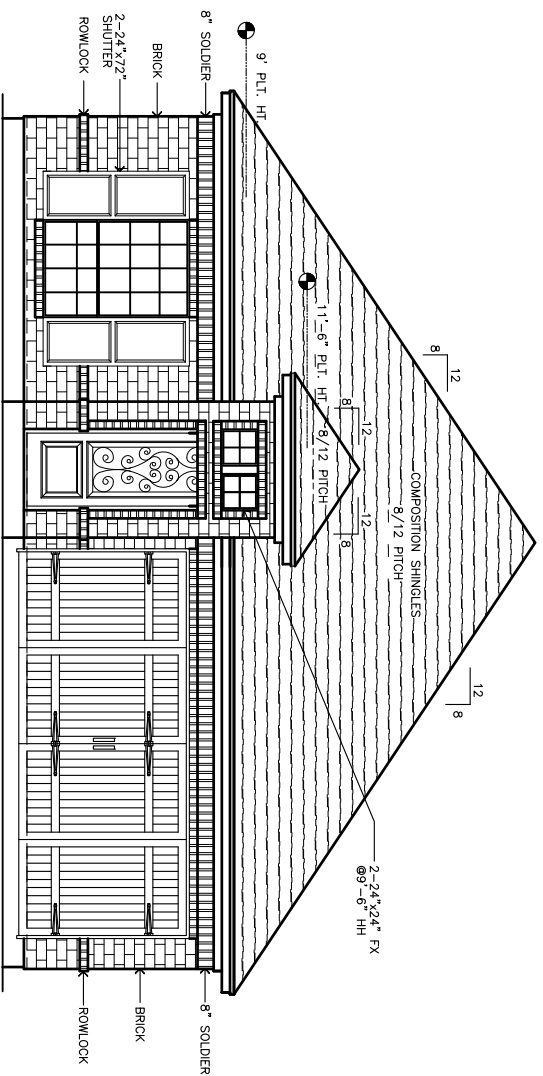


FRONT ELEVATION C

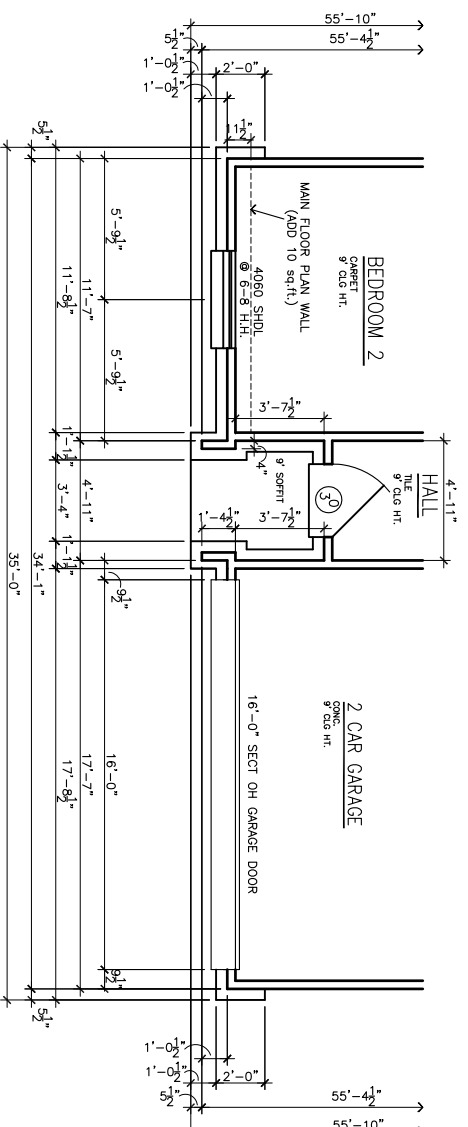

ELEVATION C  
PARTIAL FLOOR PLAN

9'-0" NOOK. P.L.T. HT. TYP. UNO  
6'-8" WINDOW HEADER HEIGHT TYP. UNO.

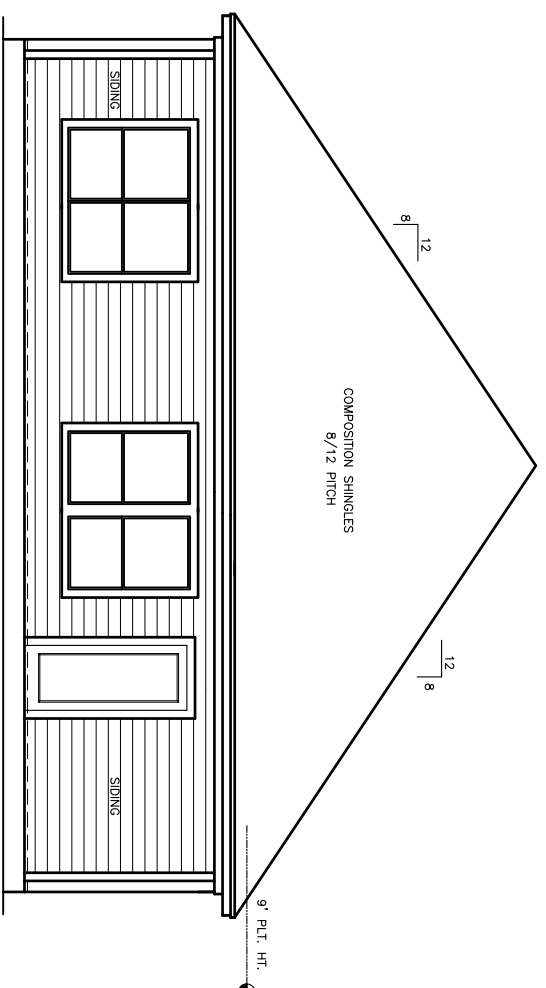


REAR




|                         |      |       |              |
|-------------------------|------|-------|--------------|
| <b>CENSEO HOMES</b>     |      | Scale | 1/8" = 1'-0" |
| ELEVATION C             |      | Date  | 01/14/19     |
| FRONT & REAR ELEVATIONS |      | Sheet | 10 OF 12     |
| Drawing No.             | 4505 | Rev.  | 1            |


E-MAIL: DESIGN@BRANCO.COM  
PHONE: 713-629-9937

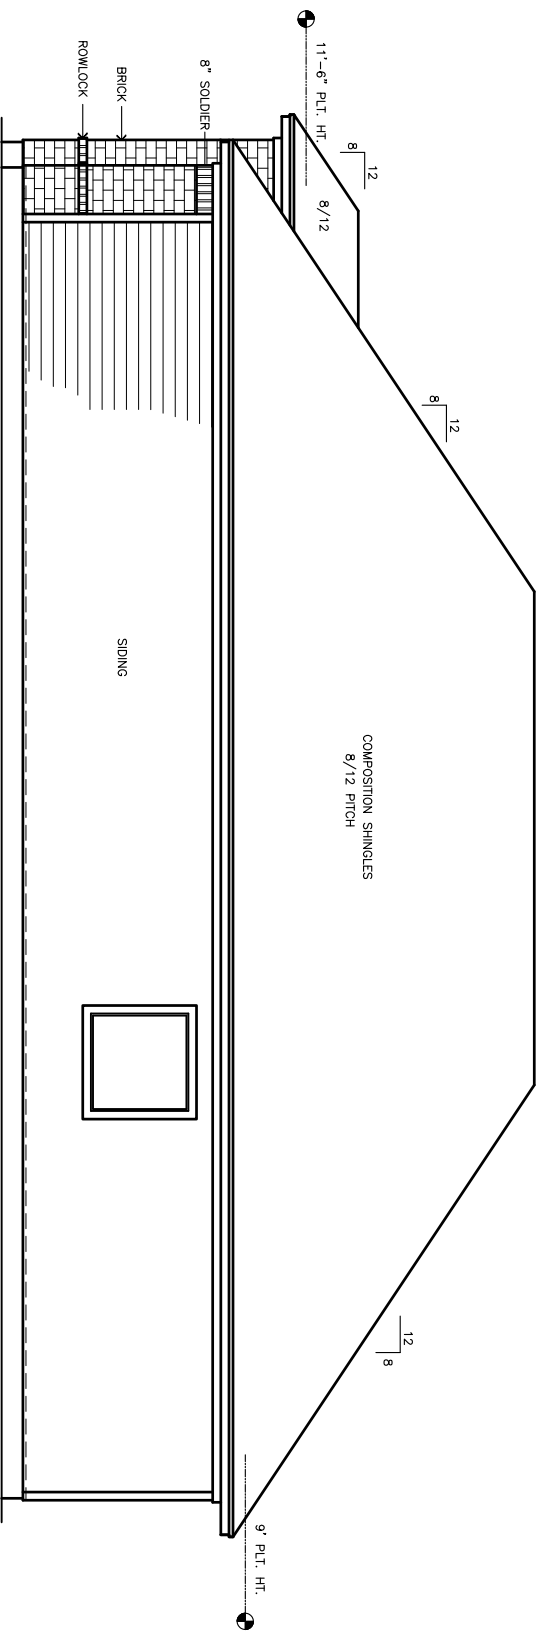


RIGHT ELEVATION C

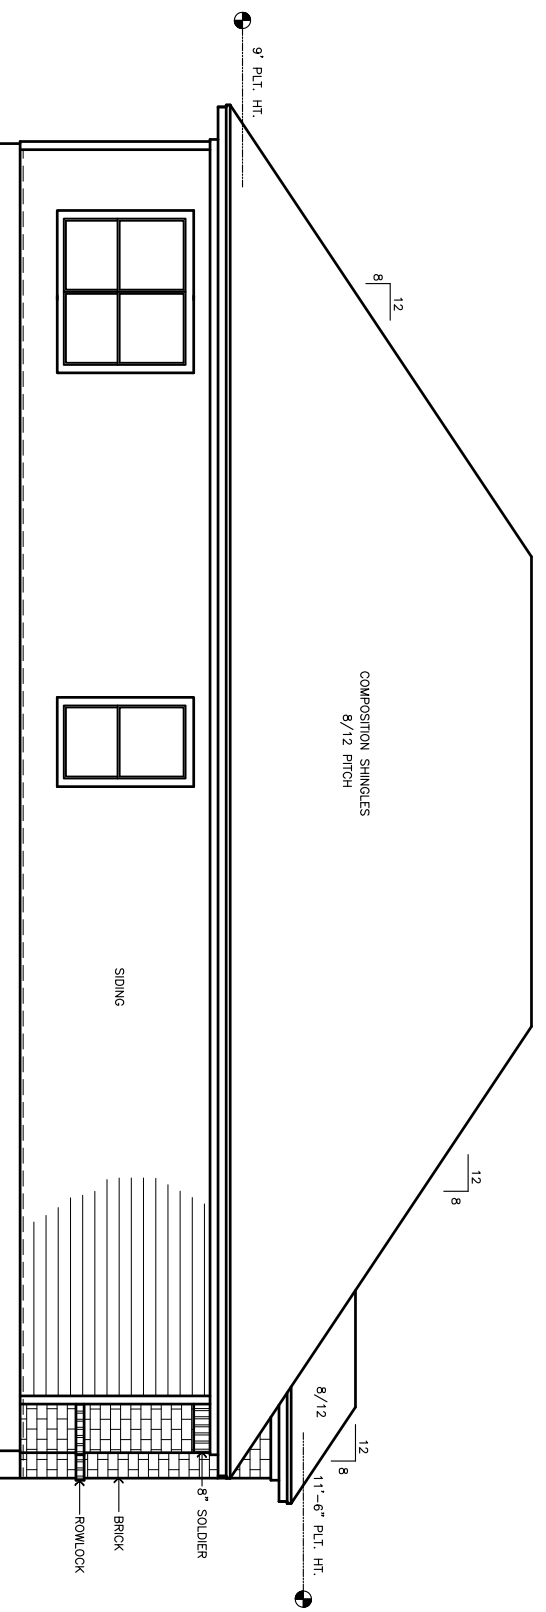


LEFT ELEVATION C

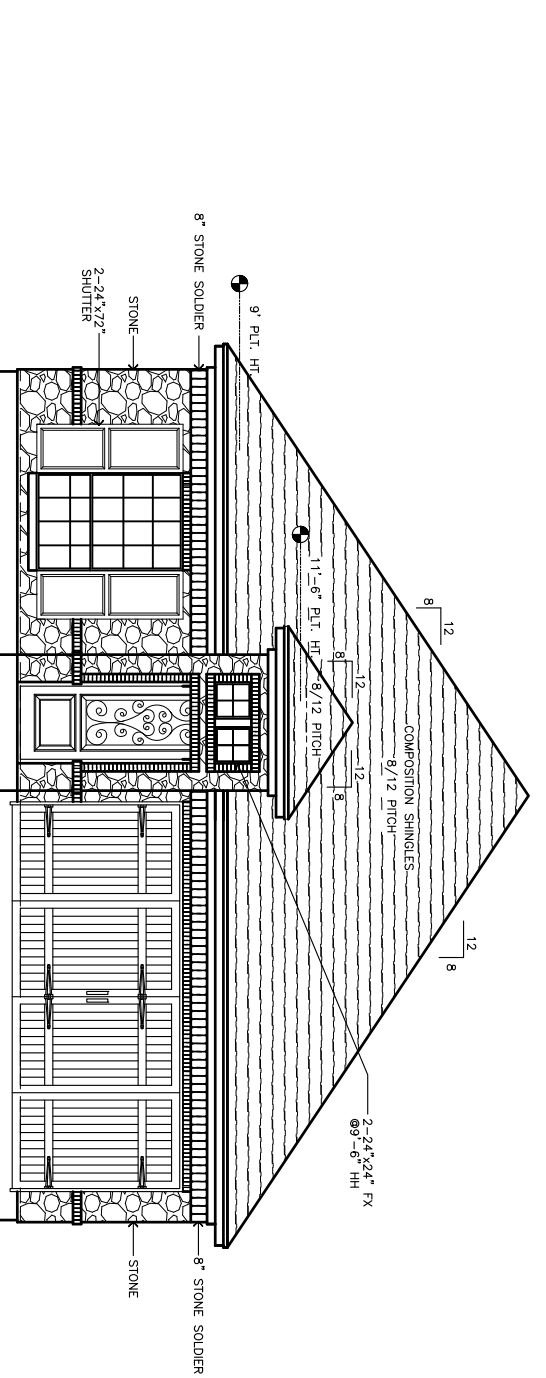

ELEVATION C  
STONE OPTION

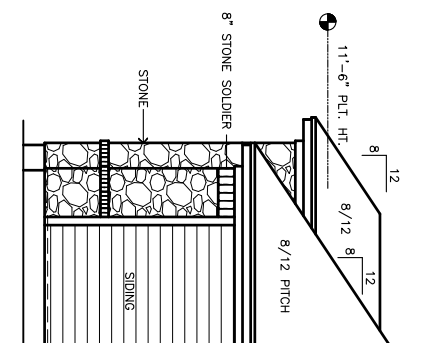

RIGHT ELEVATION C

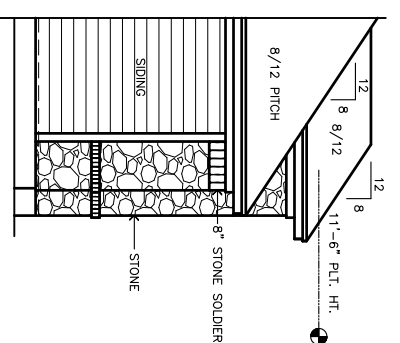


LEFT ELEVATION C

STONE OPTION



|                         |      |                       |
|-------------------------|------|-----------------------|
| <b>CENSEO HOMES</b>     |      | Scale<br>1/8" = 1'-0" |
| ELEVATION C             |      | Date<br>01/14/19      |
| RIGHT & LEFT ELEVATIONS |      | Sheet<br>11 OF 12     |
| STONE OPTION            |      | Rev.<br>1             |
| Drawing No.             | 4505 |                       |

E-MAIL: DESIGN@BRANCODESIGN.COM  
PHONE: 713-629-9937

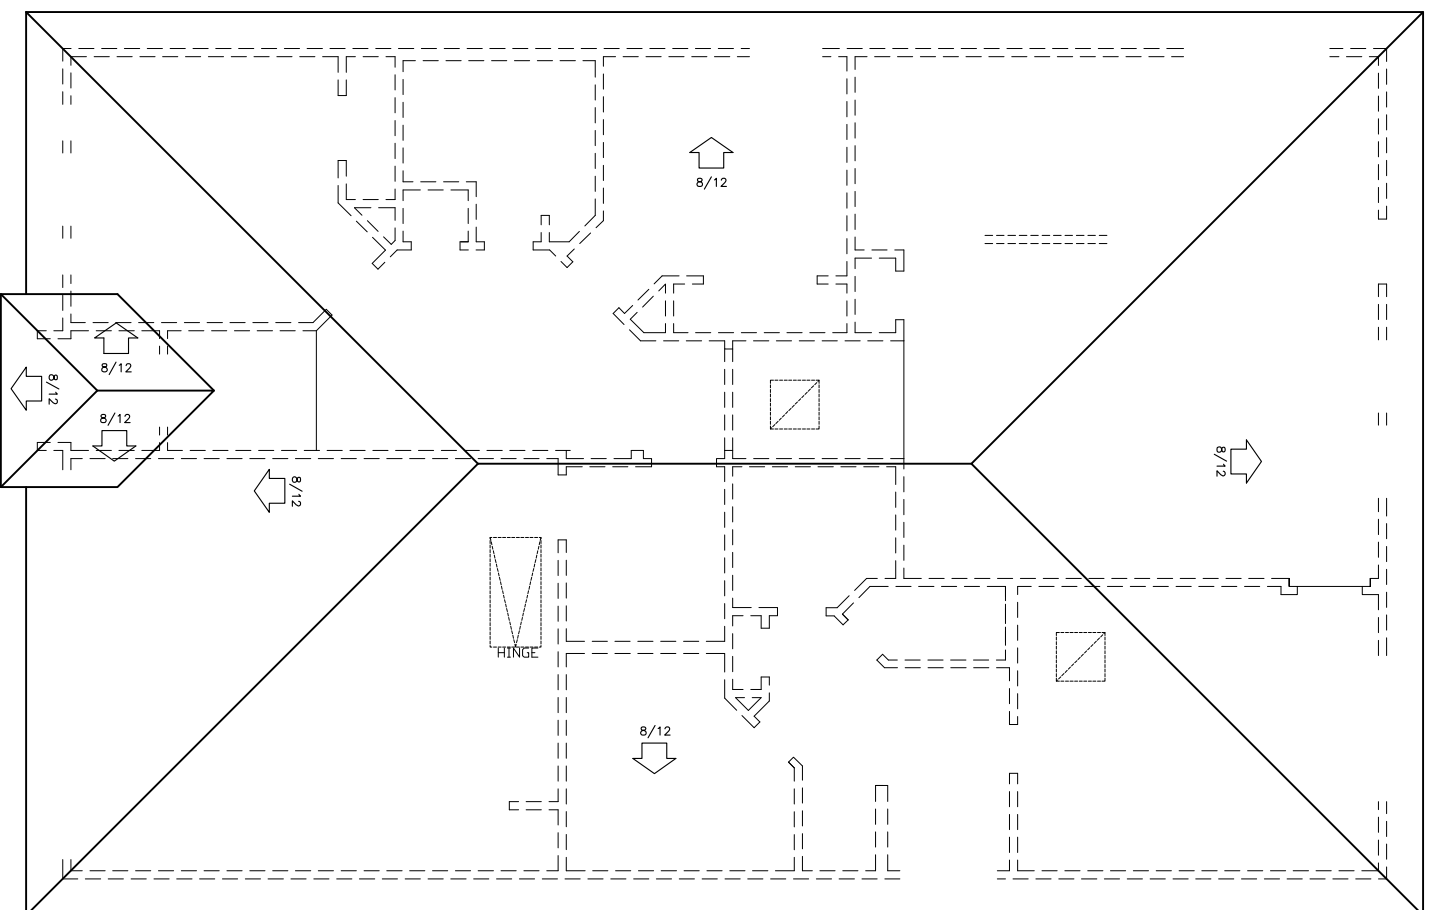

**ELEVATION C  
ROOF PLAN**

NOTES:  
8/12 PITCH = 1'-6" O.H. (MP)

**BRANCO  
DESIGN**  
E-MAIL: DESIGN@BRANCO.COM  
PHONE: 713-629-9937

|                          |                       |
|--------------------------|-----------------------|
| <b>CENSEO HOMES</b>      | Scale<br>1/8" = 1'-0" |
| ELEVATION C<br>ROOF PLAN | Date<br>01/14/19      |
| Drawing No.<br>4505      | Sheet<br>12 OF 12     |
|                          | Rev.<br>1             |