


ABBREVIATIONS							
SH	SINGLE HUNG	EB	EYE BROW	PAN	PANTRY	M.I.C.	WALK-IN CLOSET
DL	DIVIDED LIGHTS	PKT	POCKET	RM	ROOM	DBL	DOUBLE
HD	HEADER	DR	DOOR	CLST	CLOSET	SNK	SINK
HT	HEIGHT	FG	FIXED GLASS	SHLVS	SHELVES	DW	DISH WASHER
OH	OVERHEAD	OBSSG	OBSCURED GLASS	CW	COLD WATER TAP	MSTR	MASTER
SECT	SECTIONAL	/ BTH	HALF BATH	CLG	CEILING		

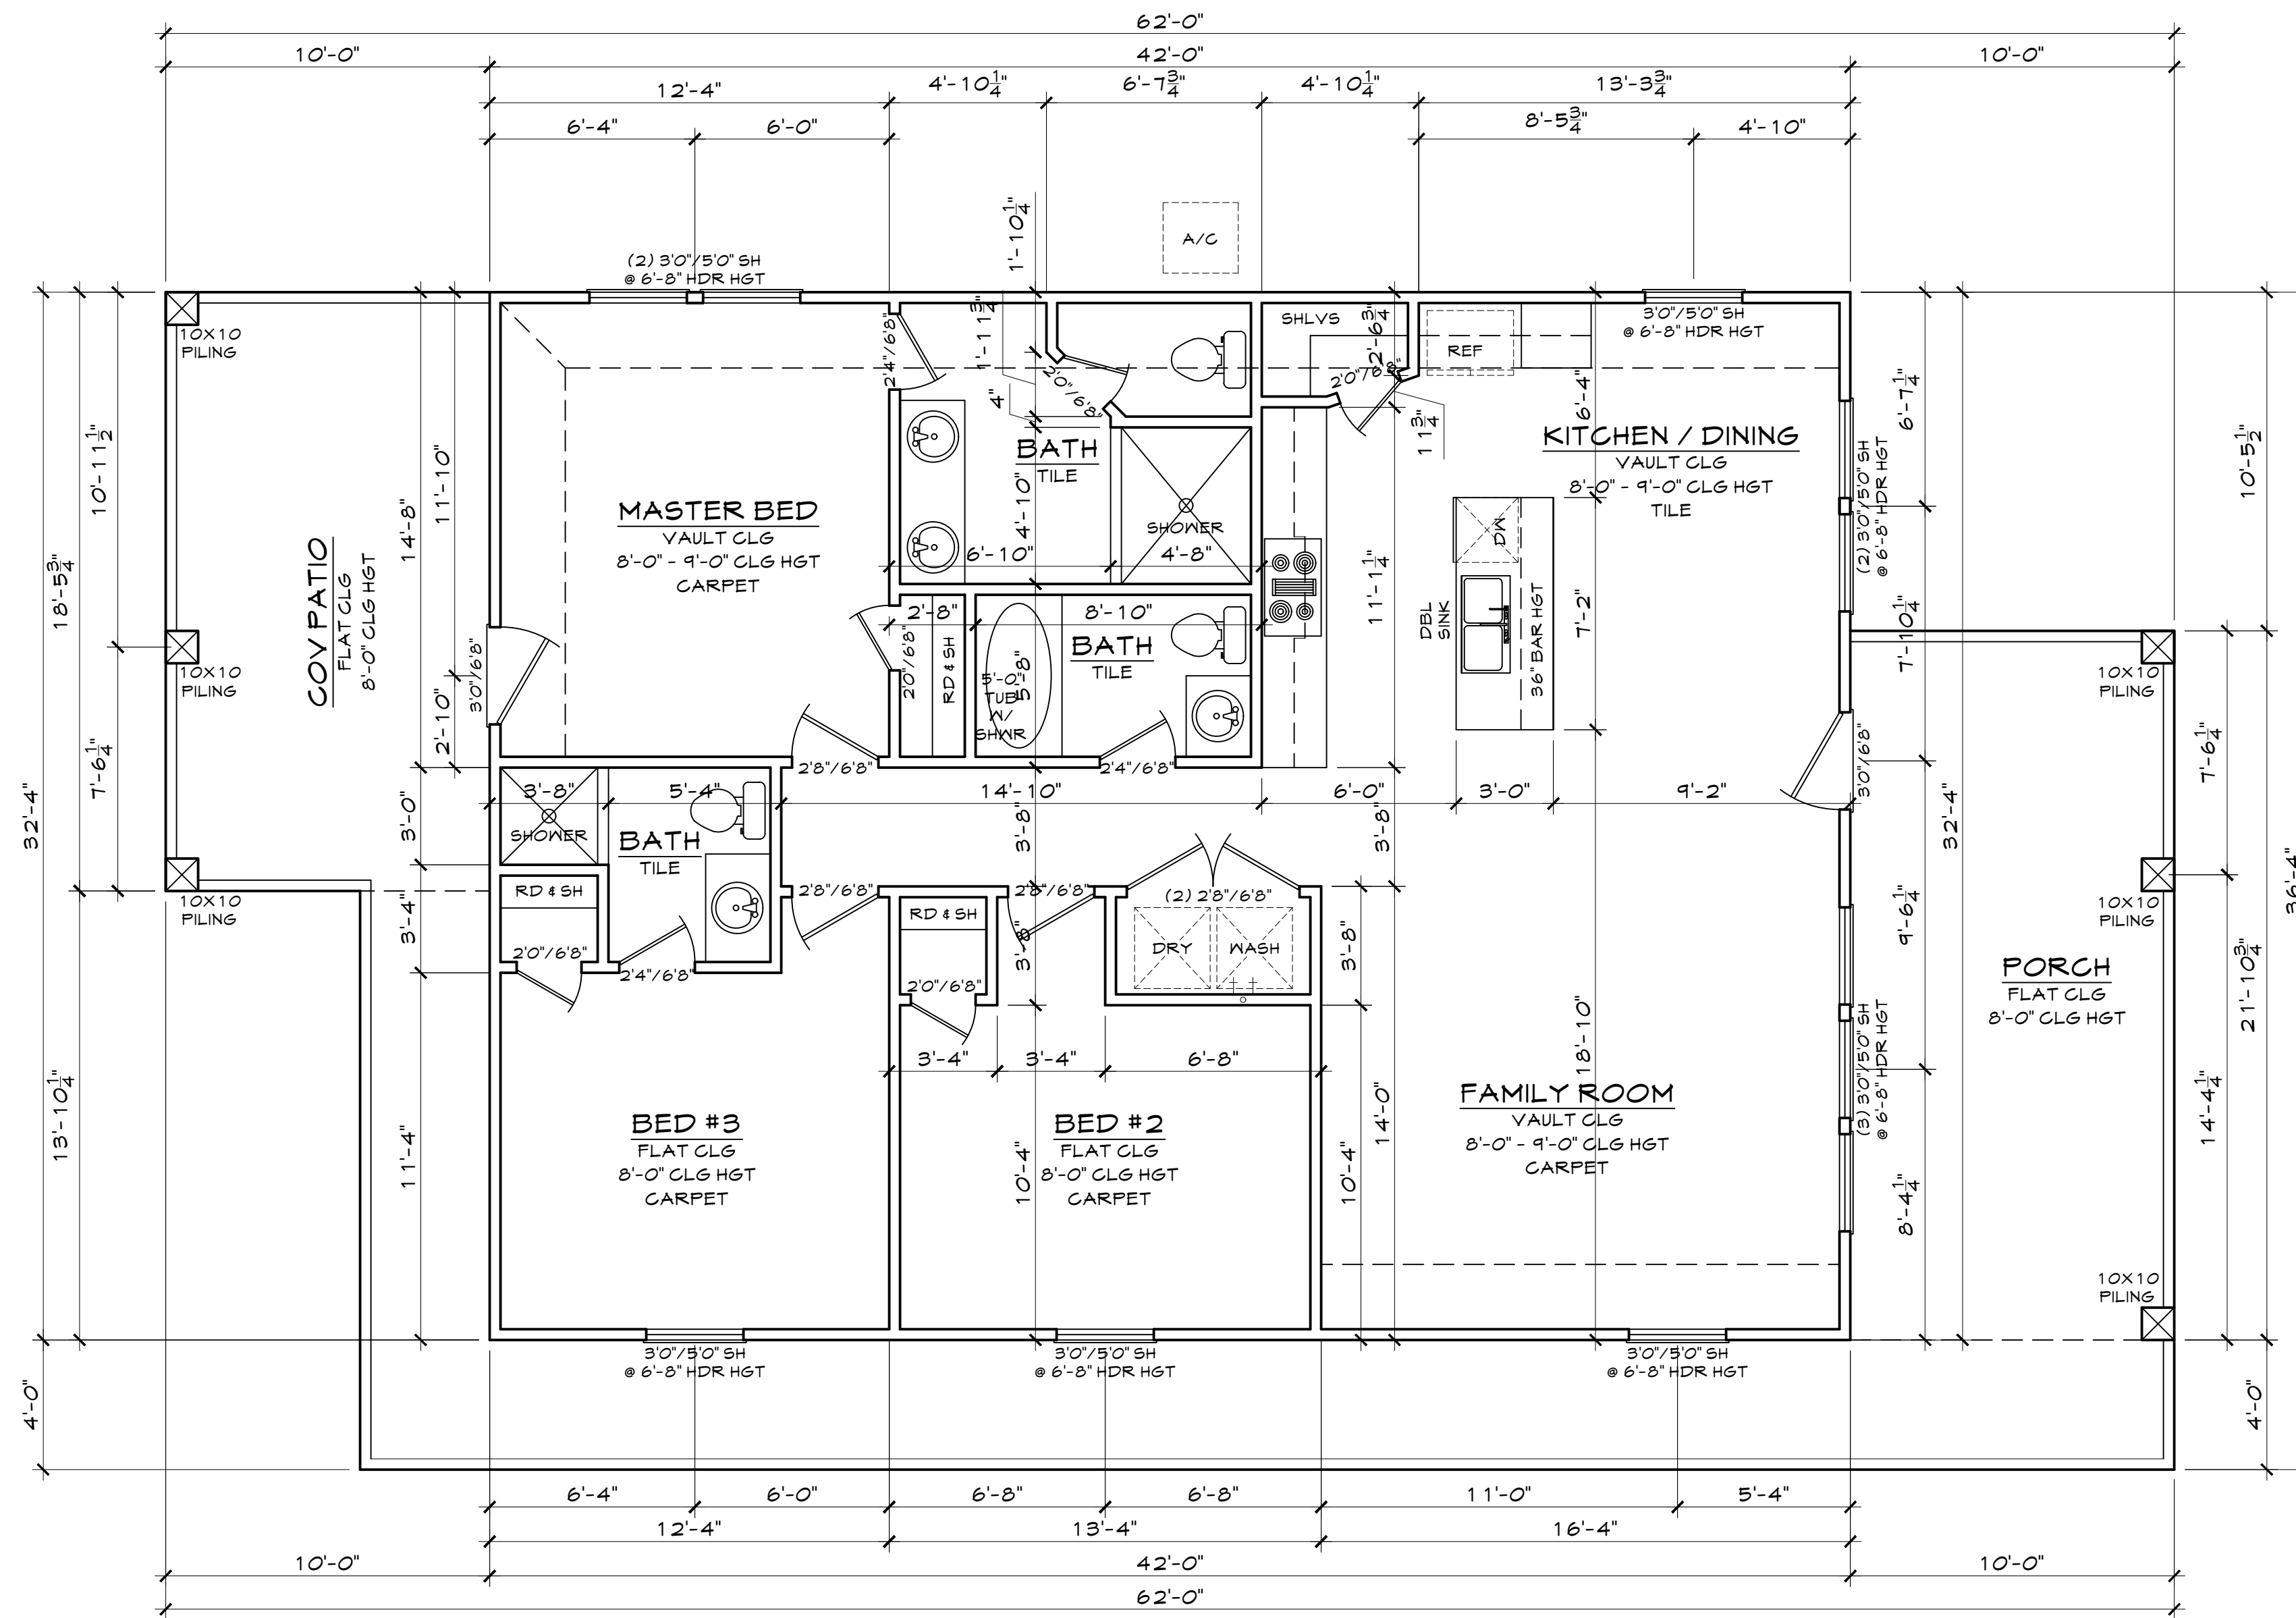

1 FLOOR PLAN
A2 SCALE: 1/4" = 1'

- ELECTRICAL NOTES:**
- SMOKE DETECTORS IN ALL BED ROOMS, REQUIRE 110V TO HOUSE WIRING, BATTERY BACKUP & INTERCONNECT
 - VENT ALL EXHAUST FANS TO OUTSIDE
 - PROVIDE G.F.I. PROTECTION ON BATH PLUGS
 - PROVIDE LIGHT FIXTURE & SMOKE DETECTORS AT WATER HEATER & A/C UNIT
 - PROVIDE ELECTRIC DISCONNECT AT A/C UNIT

MOONLIGHT HOUSE PLANS IS A DRAFTING FIRM, NOT AN ENGINEERING OR ARCHITECTURAL FIRM. THESE PRINTS ARE NOT TO BE USED FOR CONSTRUCTION OR FOR ANY OTHER PURPOSES WITHOUT THE WRITTEN PERMISSION OF MOONLIGHT HOUSE PLANS. MOONLIGHT HOUSE PLANS IS NOT RESPONSIBLE FOR ANY STRUCTURAL OR DESIGN MISTAKES, DIMENSIONS, DETAILS & SPECIFICATIONS. DESIGNER WILL NOT BE LIABLE FOR HUMAN ERROR AFTER CONSTRUCTION IS STARTED. THESE DRAWINGS, SPECIFICATIONS AND REVISIONS ARE THE PROPERTY OF MOONLIGHT HOUSE PLANS, AND SHALL NOT BE REUSED, REPRODUCED, OR ALTERED IN ANY WAY.

Moonlight House Plans
979-482-1967

REVISION HISTORY	DATE
NUMBER	

DWG. SCALE: 1/4" = 1'-0"

FLOOR PLAN
WINNARD HOMES
18315 WARRIOR DRIVE - GALVESTON, TEXAS
JOB #: 20203360

12-10-20

A2