




OPT. FIREPLACE
 SCALE: 11x17 1/8" = 1'-0"
 34x22 1/4" = 1'-0"

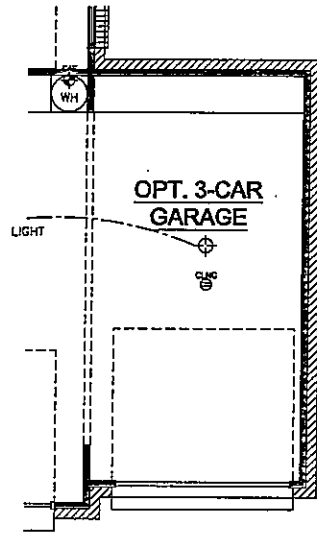

OPT. 3-CAR GARAGE
 SCALE: 11x17 1/8" = 1'-0"
 34x22 1/4" = 1'-0"

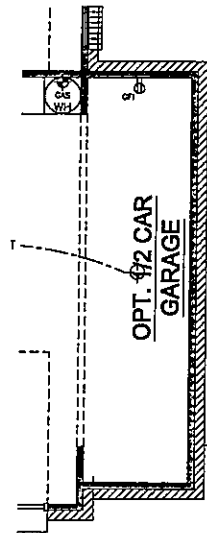


OPT: 1/2 CAR GARAGE
 SCALE: 11x17 1/8" = 1'-0"
 34x22 1/4" = 1'-0"

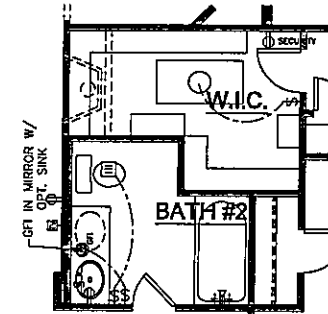

OPT: BATH #2
 SCALE: 11x17 1/8" = 1'-0"
 34x22 1/4" = 1'-0"

**Window Sensors*
**Post Tubes*
**Provide for pendant over island*
**Move Cans*

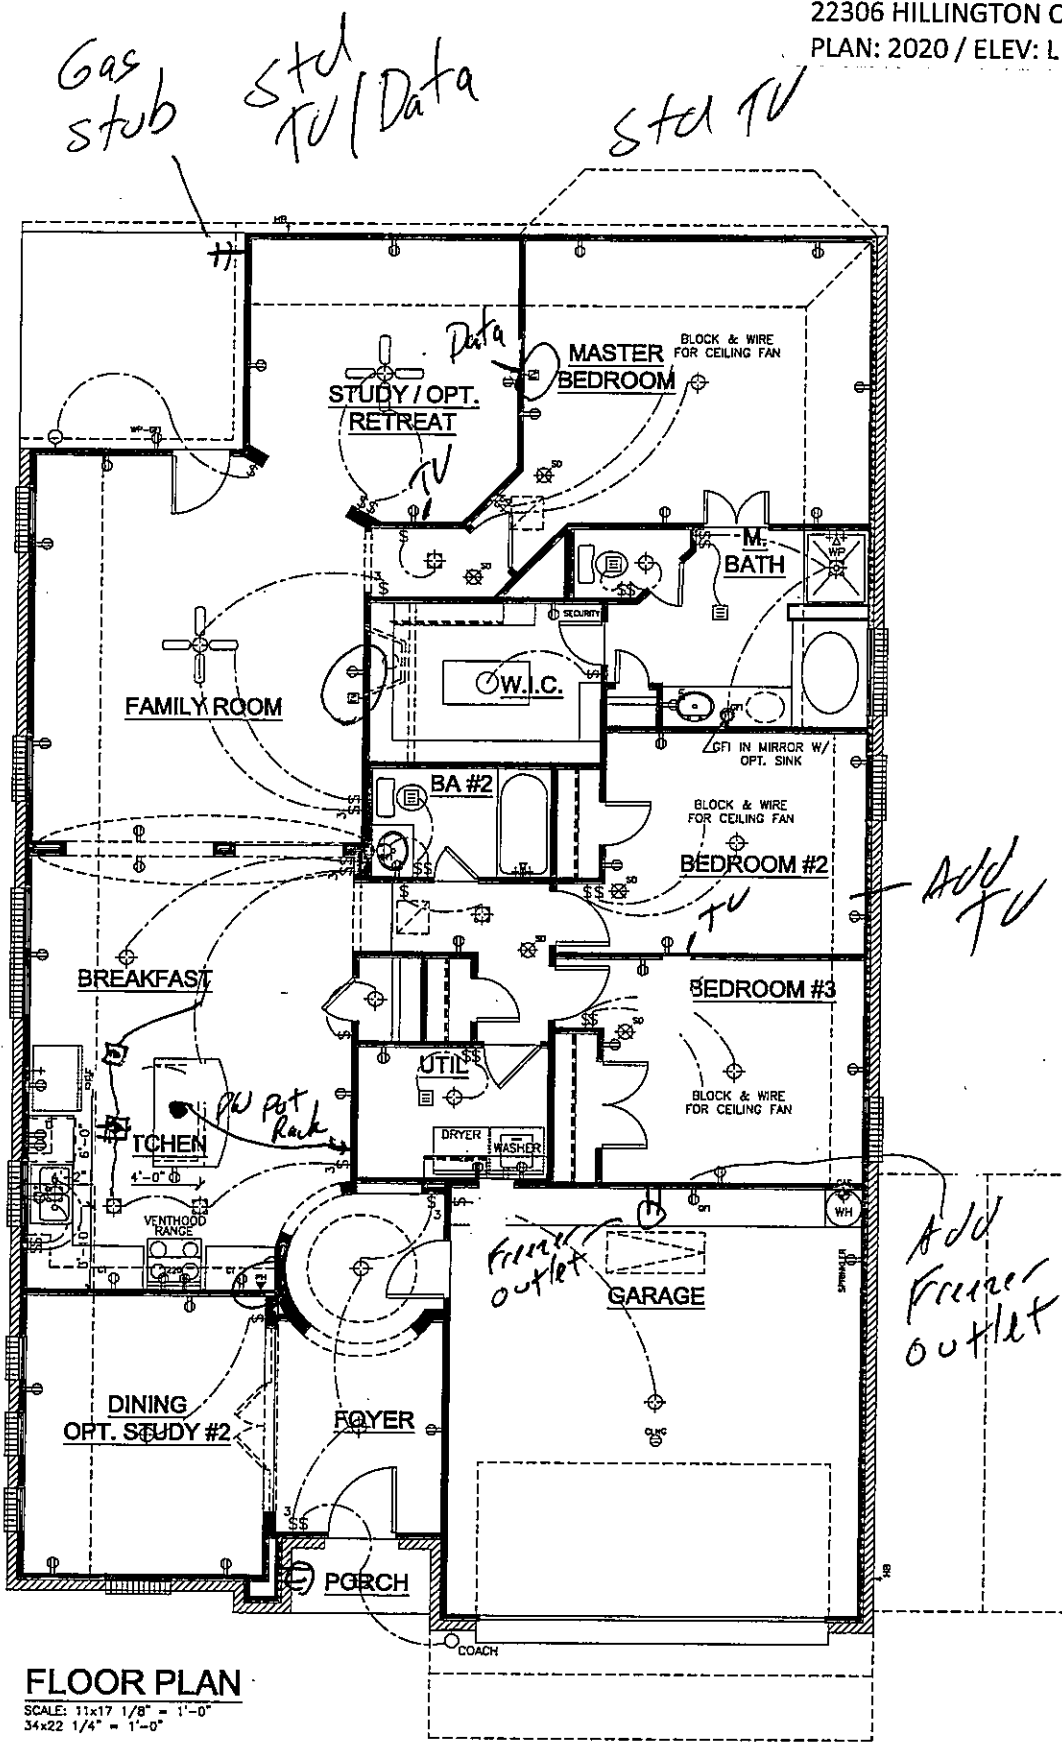

FLOOR PLAN
 SCALE: 11x17 1/8" = 1'-0"
 34x22 1/4" = 1'-0"

ELECTRICAL LEGEND			
⊠	SWITCH	⊙	SPEAKER
⊠	THREE-WAY SWITCH	⊙	THERMOSTAT
⊠	FOUR-WAY SWITCH	⊙	SMOKE DETECTOR
⊠	RHEOSTAT	⊙	CARBON MONOXIDE DETECTOR
⊠	DUPLEX	⊙	CEILING LIGHT
⊠	GFCI DUPLEX	⊙	RECESSED CEILING LIGHT
⊠	COUNTERTOP DUPLEX	⊙	RECESSED EYEBALL LIGHT
⊠	SPLIT WIRED DUPLEX	⊙	WALL HUNG LIGHT
⊠	220 VOLT OUTLET	⊙	EYEBALL LIGHT
⊠	QUADRUPLEX	⊙	LANDSCAPING LIGHT
⊠	CEILING DUPLEX	⊙	FLOODLIGHT
⊠	FLOOR DUPLEX	⊙	VENT
⊠	JUNCTION	⊙	VENT AND LIGHT
⊠	DOOR BELL	⊙	HEAT AND LIGHT
⊠	GARAGE DOOR	⊙	HEAT AND VENT
⊠	PHONE OUTLET	⊙	HEAT, VENT AND LIGHT
⊠	TV OUTLET		

BSB DESIGN
 www.bsbdesign.com
 17885 Dallas Parkway, Suite 105
 Dallas, Texas 75287
 972.720.1778

REVISIONS
 NO. DATE / DESCRIPT.


JOB NO.
 DATE
 7/22/2012
 DRAWN BY
 PHF
 DRAWING NO.

Gehan HOMES
 Designed for Your Life.
 18723 North Dallas Parkway, Suite 300
 Addison, Texas 76001 (972) 388-4800


COPYRIGHT © 2012

PLAN 2020 RIGHT


SHEET NO.
2
 OF
16

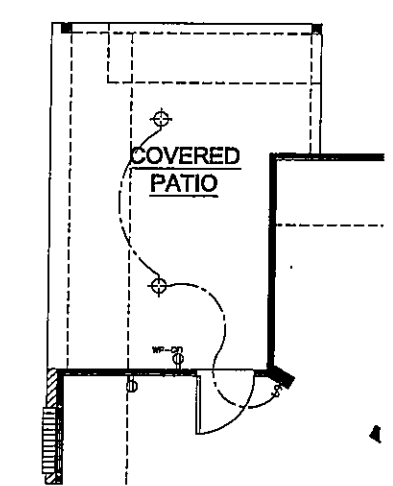


OPT: PATIO #2
SCALE: 11x17 1/8" = 1'-0"
34x22 1/4" = 1'-0" OPT: PATIO2

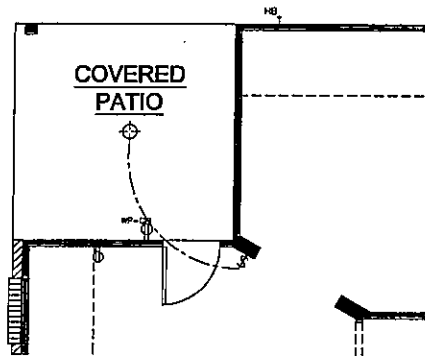


OPT: COVERED PATIO #1
SCALE: 11x17 1/8" = 1'-0"
34x22 1/4" = 1'-0" OPT: PATIO1

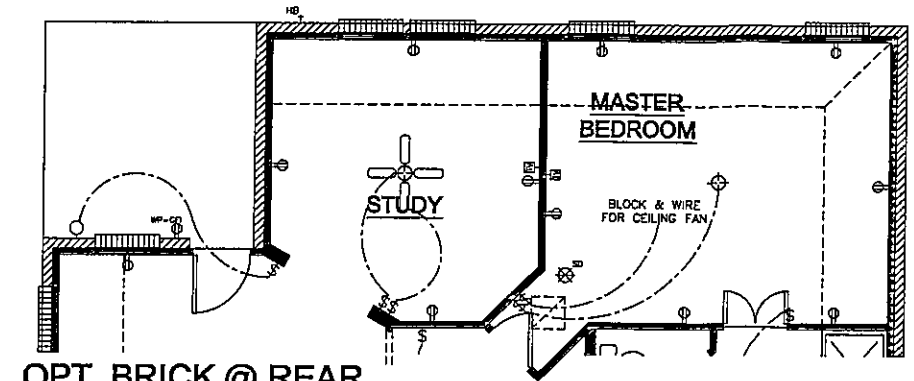


OPT. BRICK @ REAR
SCALE: 11x17 1/8" = 1'-0" OPT: BRKREAR
34x22 1/4" = 1'-0"

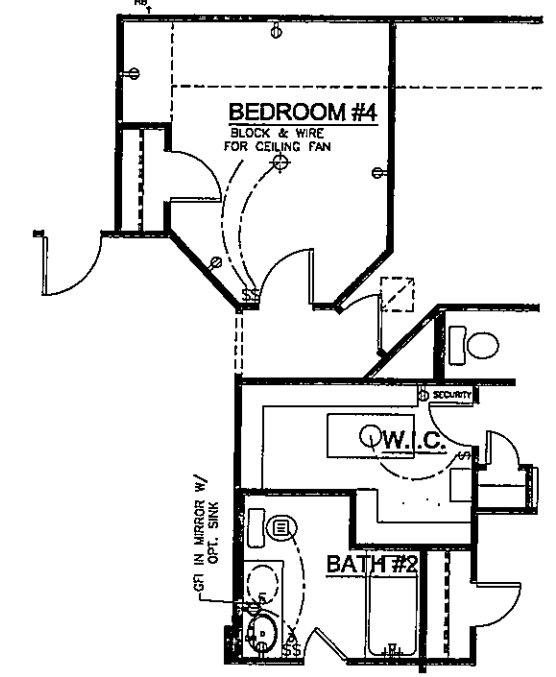


OPT. BEDROOM #4
SCALE: 11x17 1/8" = 1'-0" OPT: BED4
34x22 1/4" = 1'-0"

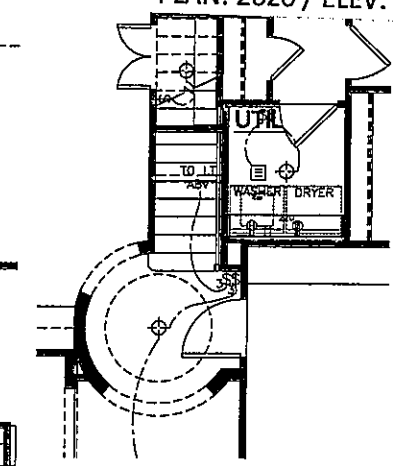


OPT 1ST FLOOR STAIRS
SCALE: 11x17 1/8" = 1'-0"
34x22 1/4" = 1'-0"

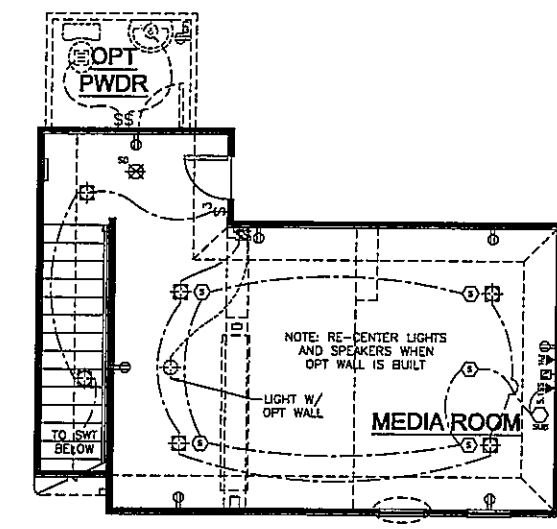

OPT. MEDIA
SCALE: 11x17 1/8" = 1'-0" MEDIA ADDS 325 SQ FT OPT: MEDIA
34x22 1/4" = 1'-0" POWDER ADDS 37 SQ FT OPT: POWDER

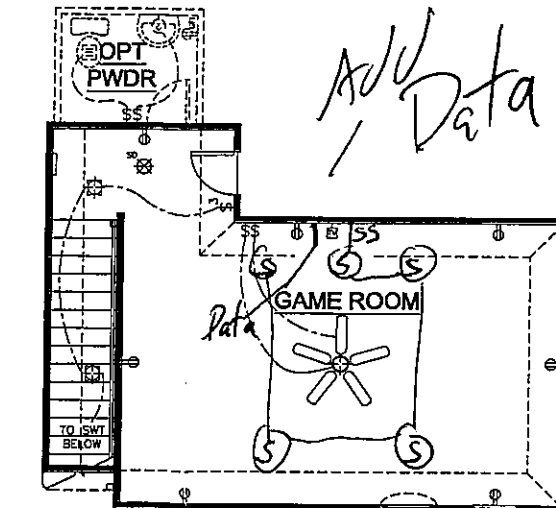

OPT. GAME ROOM
SCALE: 11x17 1/8" = 1'-0" GAMERM ADDS 325 SQ FT OPT: GAMERM
34x22 1/4" = 1'-0" POWDER ADDS 37 SQ FT OPT: POWDER
**Add 5.1 Surround Prewired w/center NO sub*

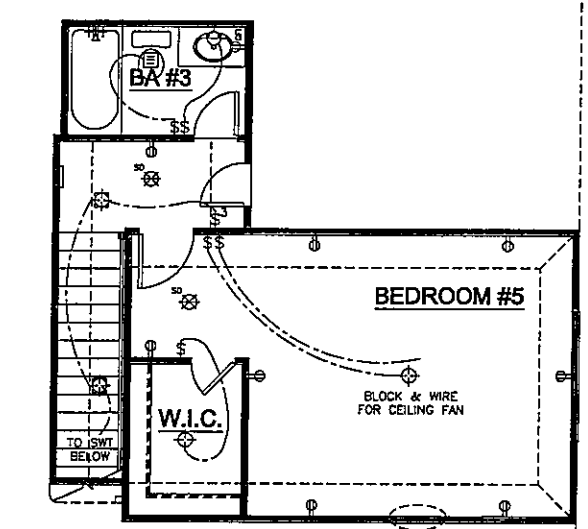

OPT: BEDROOM #5/BATH #3
SCALE: 11x17 1/8" = 1'-0" ADDS 371 SQ FT OPT: BED5BTH3
34x22 1/4" = 1'-0"

BSB DESIGN
www.bsbdesign.com
17855 Dallas Parkway, Suite 105
Dallas, Texas 75247
872 720-1778

REVISIONS	
NO.	DATE / DESCRIPT.

JOB NO.
DATE
7/22/2012
DRAWN BY
PHF
DRAWING NO.

Gehan Homes
Designed for Your Life.
1923 North Dallas Parkway, Suite 300
Addicks, Texas 75001 (972) 883-4300

COPYRIGHT
© 2012

PLAN 2020
RIGHT

SHEET NO.
4
OF
16