


① FIRST FLOOR PLAN ELEC. PLAN - TRL
 SCALE: 1/8"=1'-0" (11"x17" SHEET SIZE)
 SCALE: 1/4"=1'-0" (24"x36" SHEET SIZE)

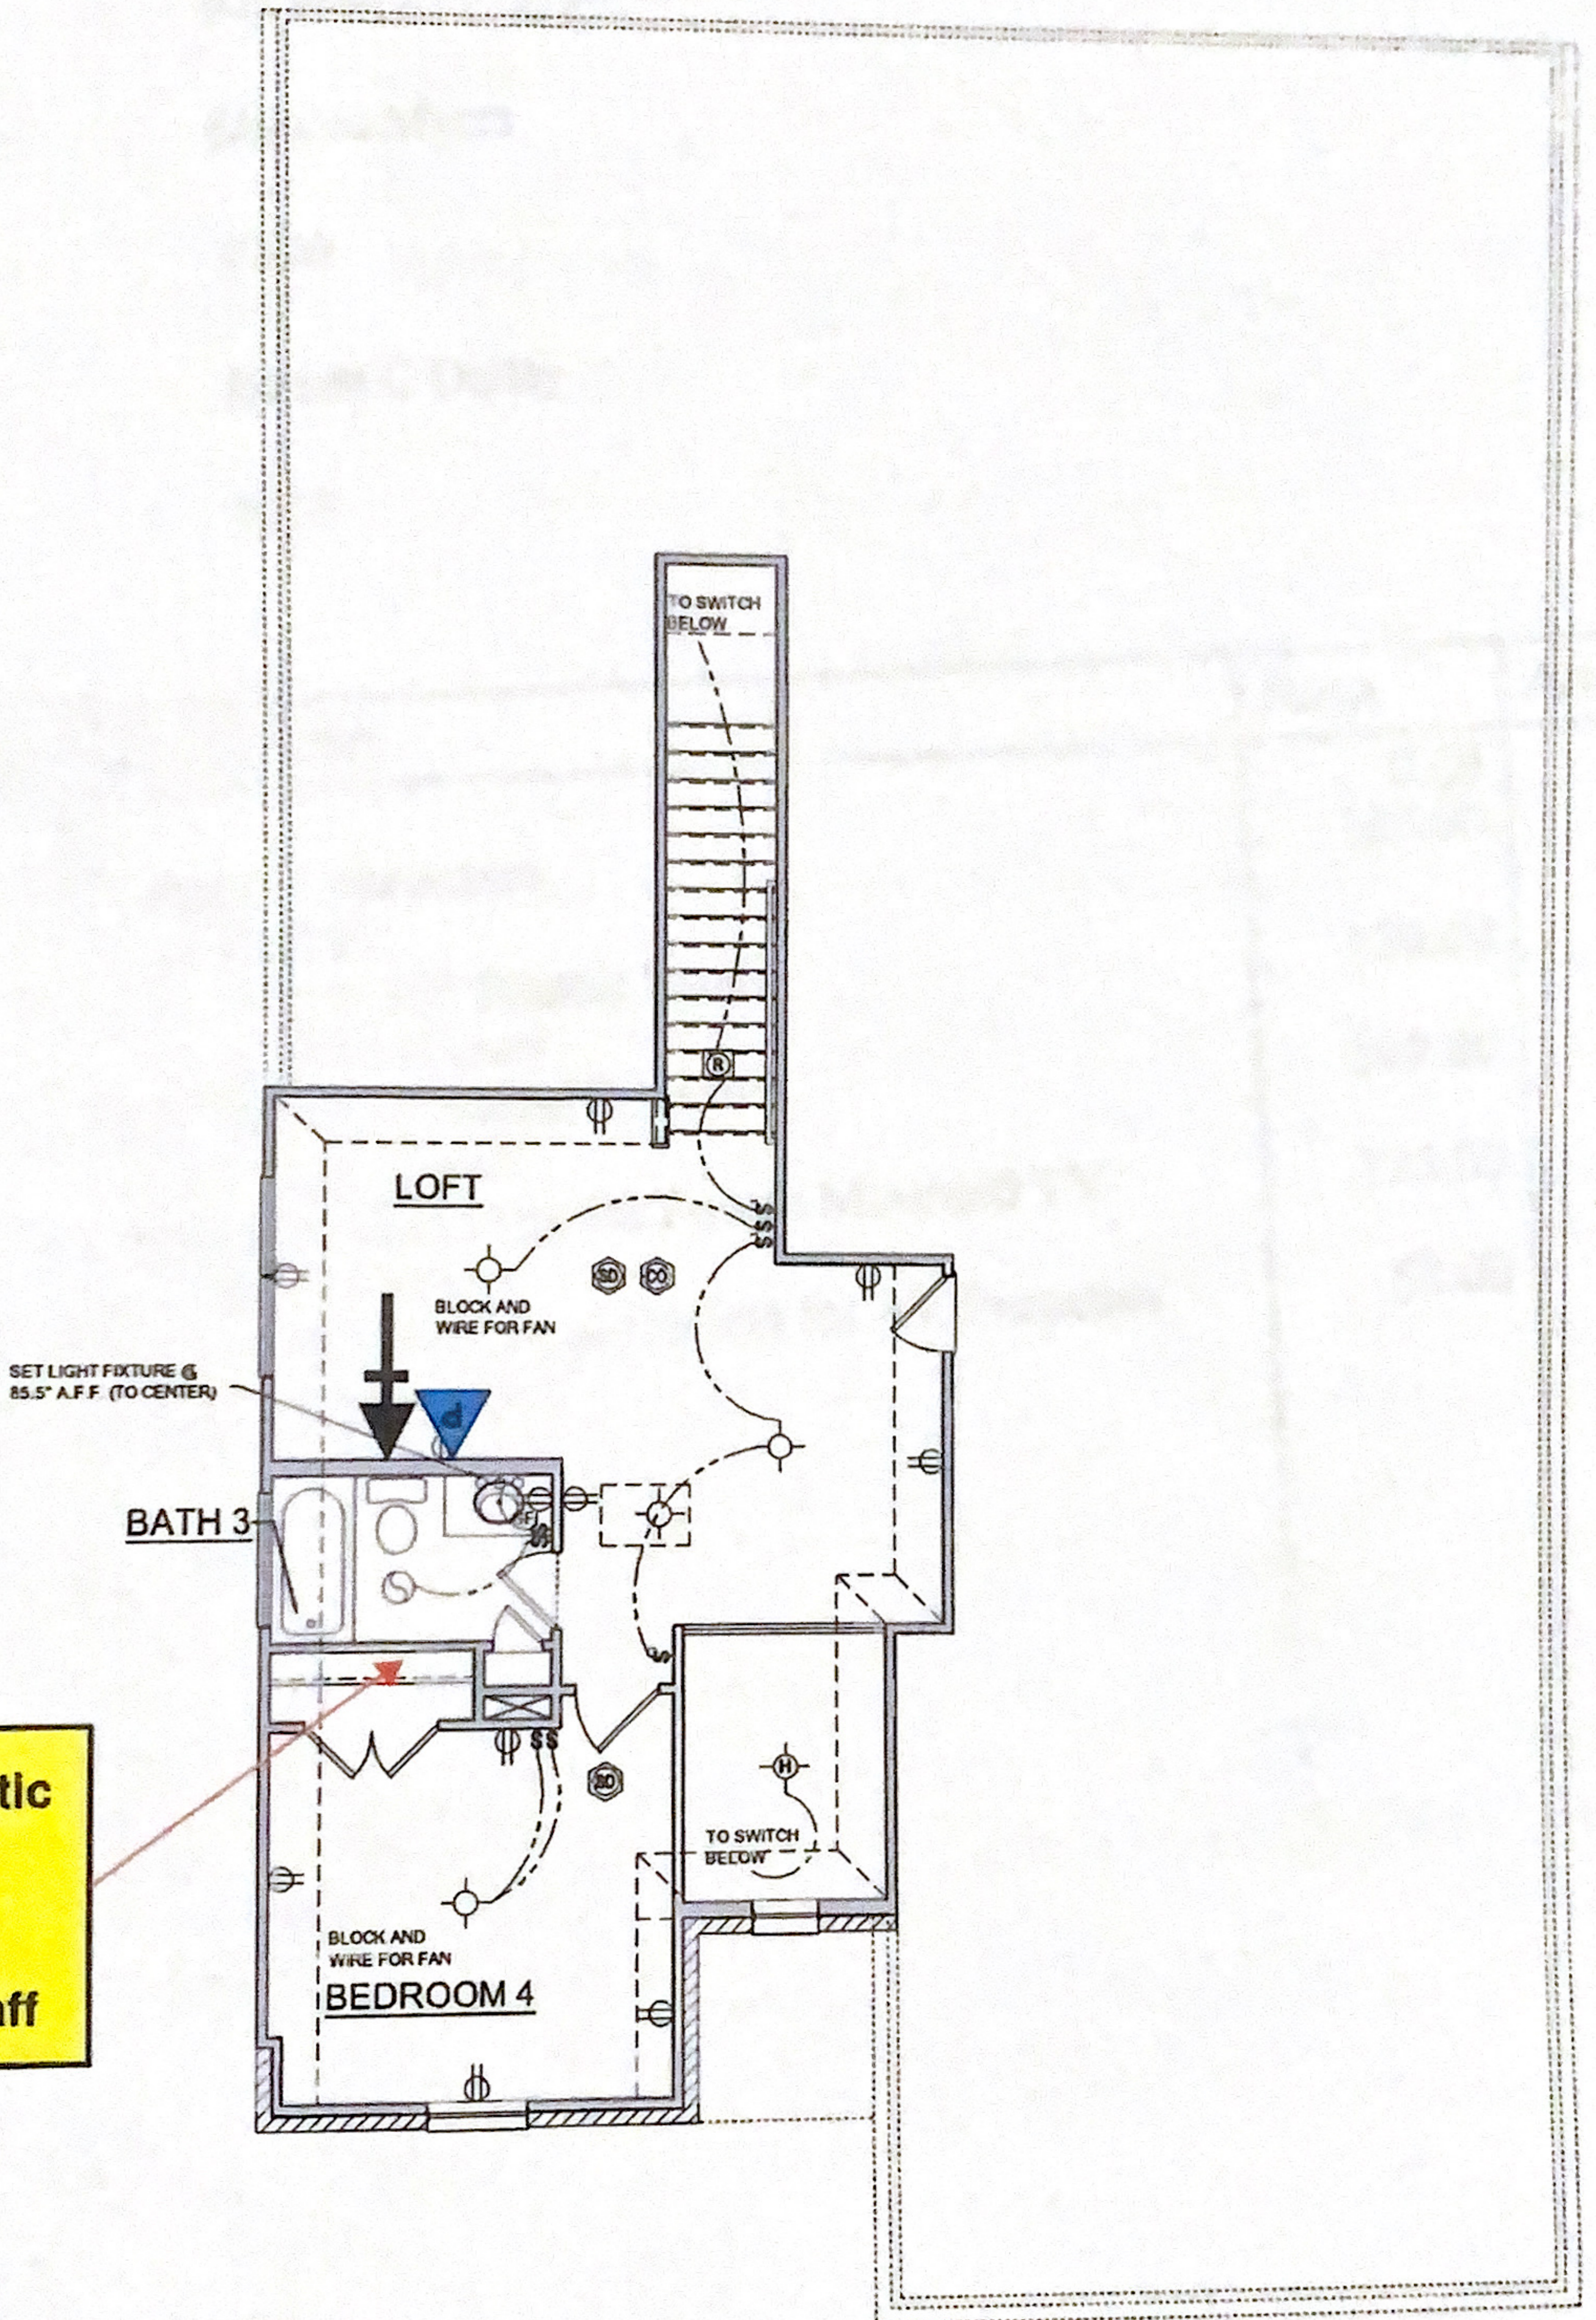

30" OnQ Plastic Structured Wiring Panel
Panel @ 34" aff

1 SECOND FLOOR PLAN ELEC. PLAN
SCALE: 1/8"=1'-0" (11"x17" SHEET SIZE)
SCALE: 1/4"=1'-0" (24"x36" SHEET SIZE)