


MOONLIGHT HOUSE PLANS

324 AZALEA, LAKE JACKSON, TX. 77566
979-482-1967

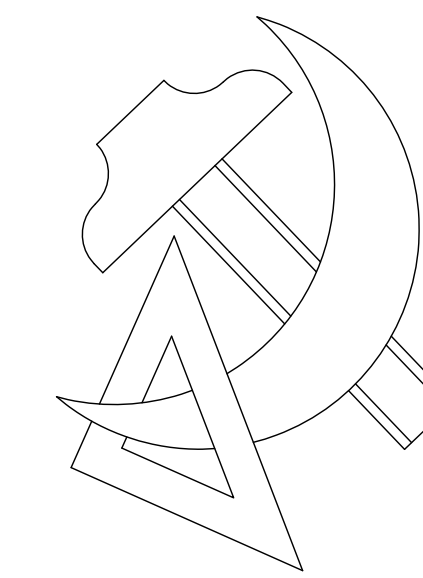


LAKE JACKSON MANAGEMENT
216 SHANNON STREET – ANGLETON, TEXAS

PLAN#:	20213935
LIVING:	1702 SQ.FT.
GARAGE:	520 SQ.FT.
PORCH:	65 SQ.FT.
COV PATIO:	187 SQ.FT.
TOTAL:	2474 SQ.FT.


MOONLIGHT HOUSE PLANS IS A DRAFTING FIRM, NOT AN ENGINEERING, OR ARCHITECTURAL FIRM. THESE PRINTS ARE TO BE APPROVED BY A LOCAL ENGINEER FOR ALL STRUCTURAL BEINGS. MOONLIGHT HOUSE PLANS IS NOT RESPONSIBLE FOR ANY STRUCTURAL OR DESIGN MISTAKES. ALL SUBCONTRACTORS SHALL VERIFY ANY & ALL DIMENSIONS, DETAILS & SPECIFICATIONS.

DESIGNER WILL NOT BE LIABLE FOR HUMAN ERROR AFTER CONSTRUCTION IS STARTED.


THESE DRAWINGS, SPECIFICATIONS AND IDEAS ARE THE PROPERTY OF MOONLIGHT HOUSE PLANS. AND SHALL NOT BE REUSED, REPRODUCED, OR ALTERED IN ANY WAY.

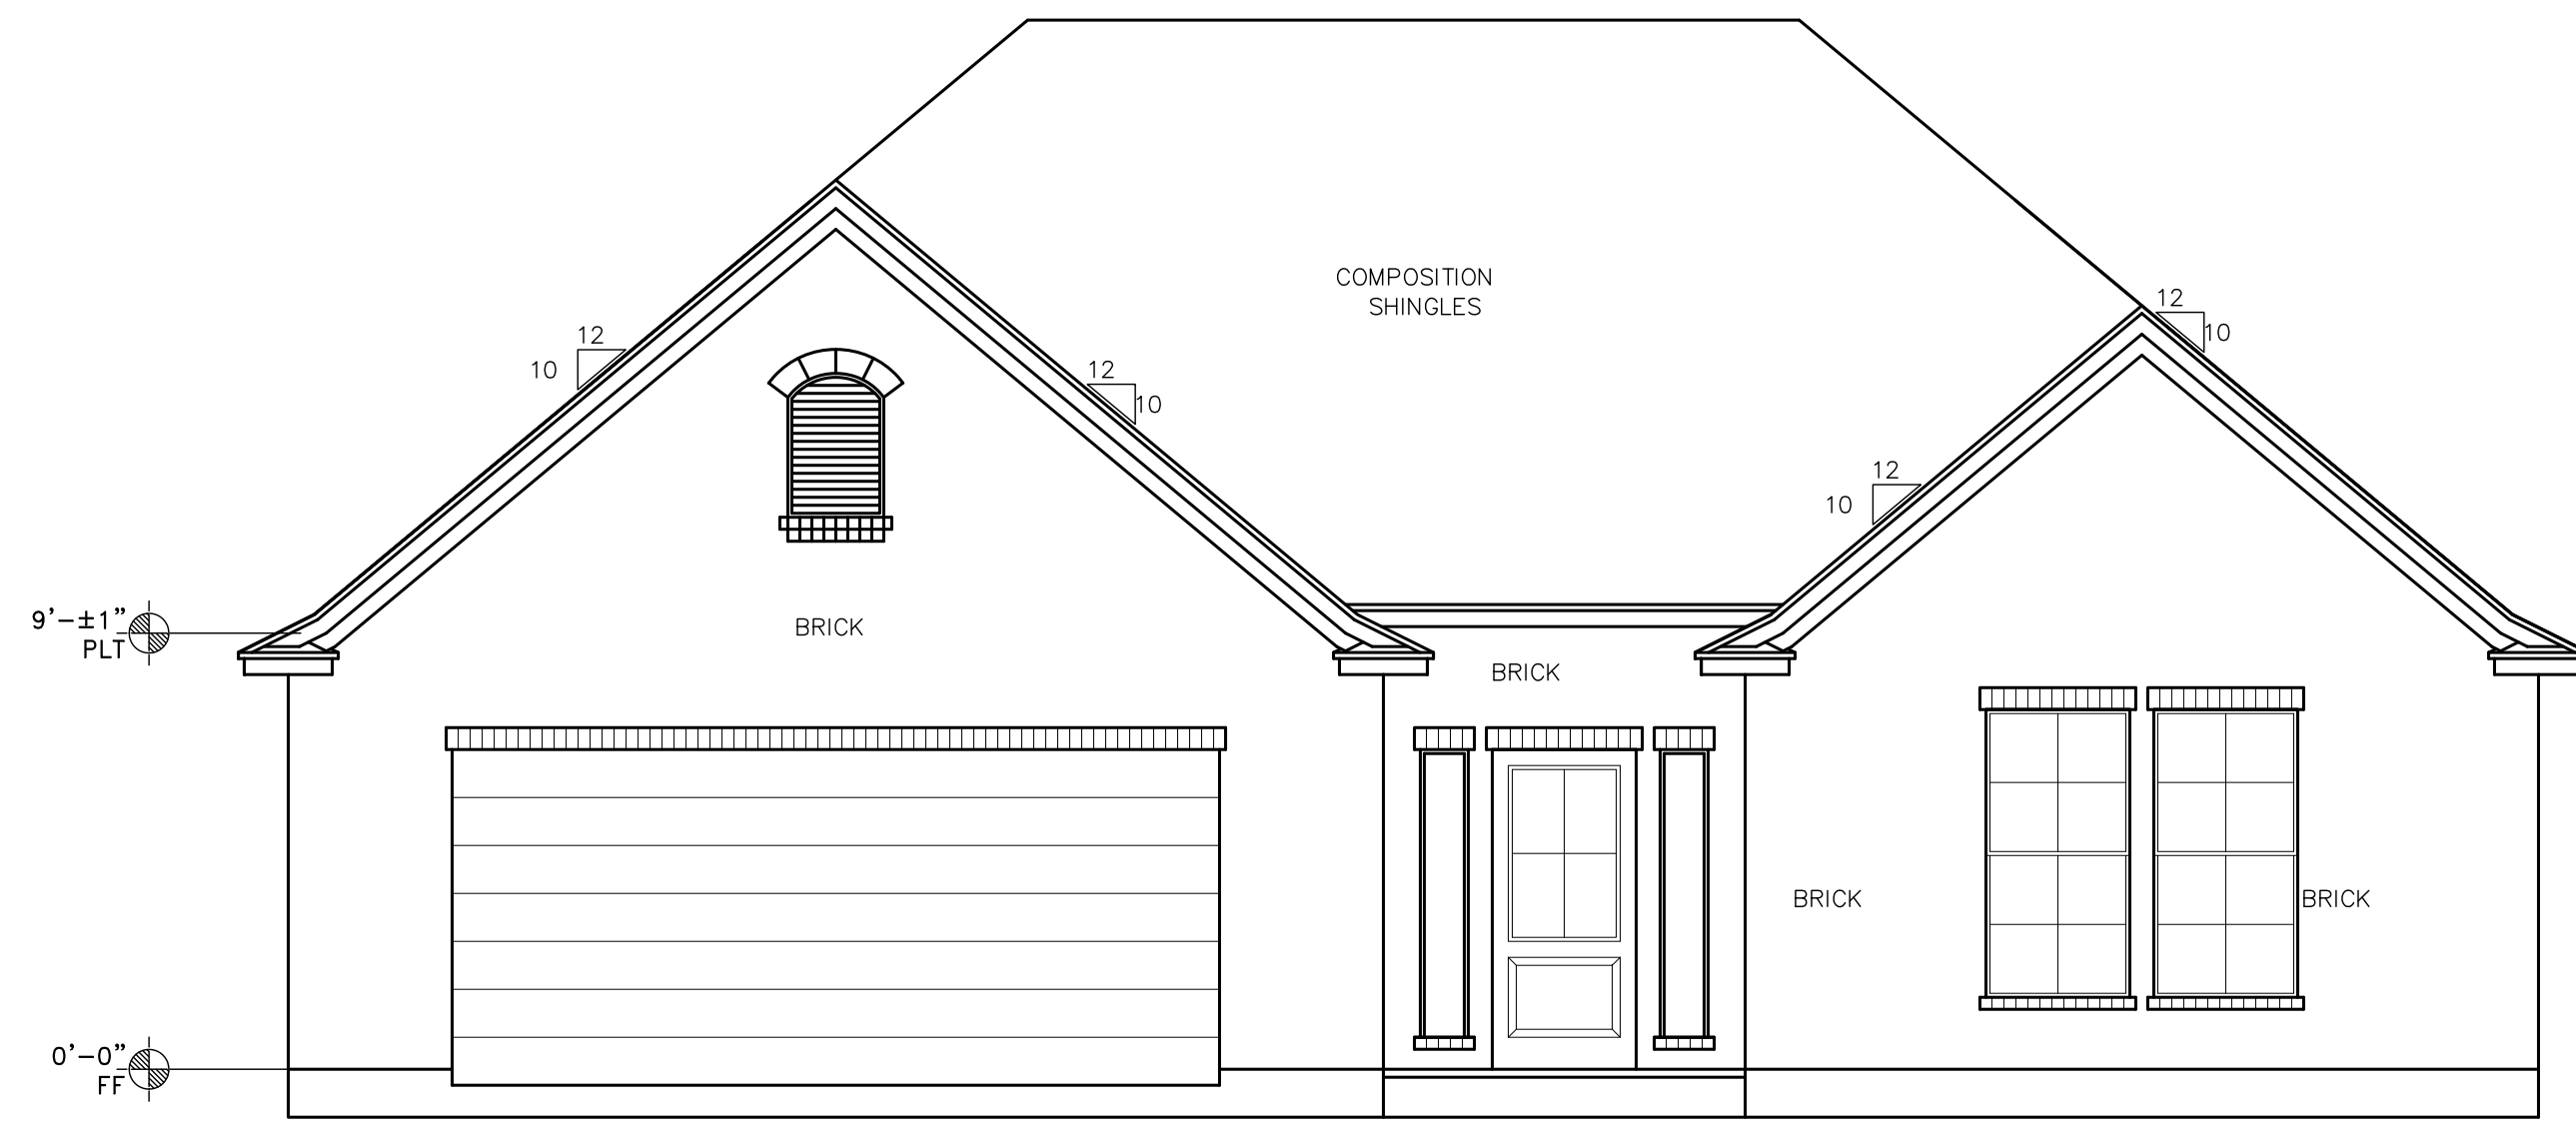


1 FRONT VIEW
A1 SCALE: 1/4" = 1'

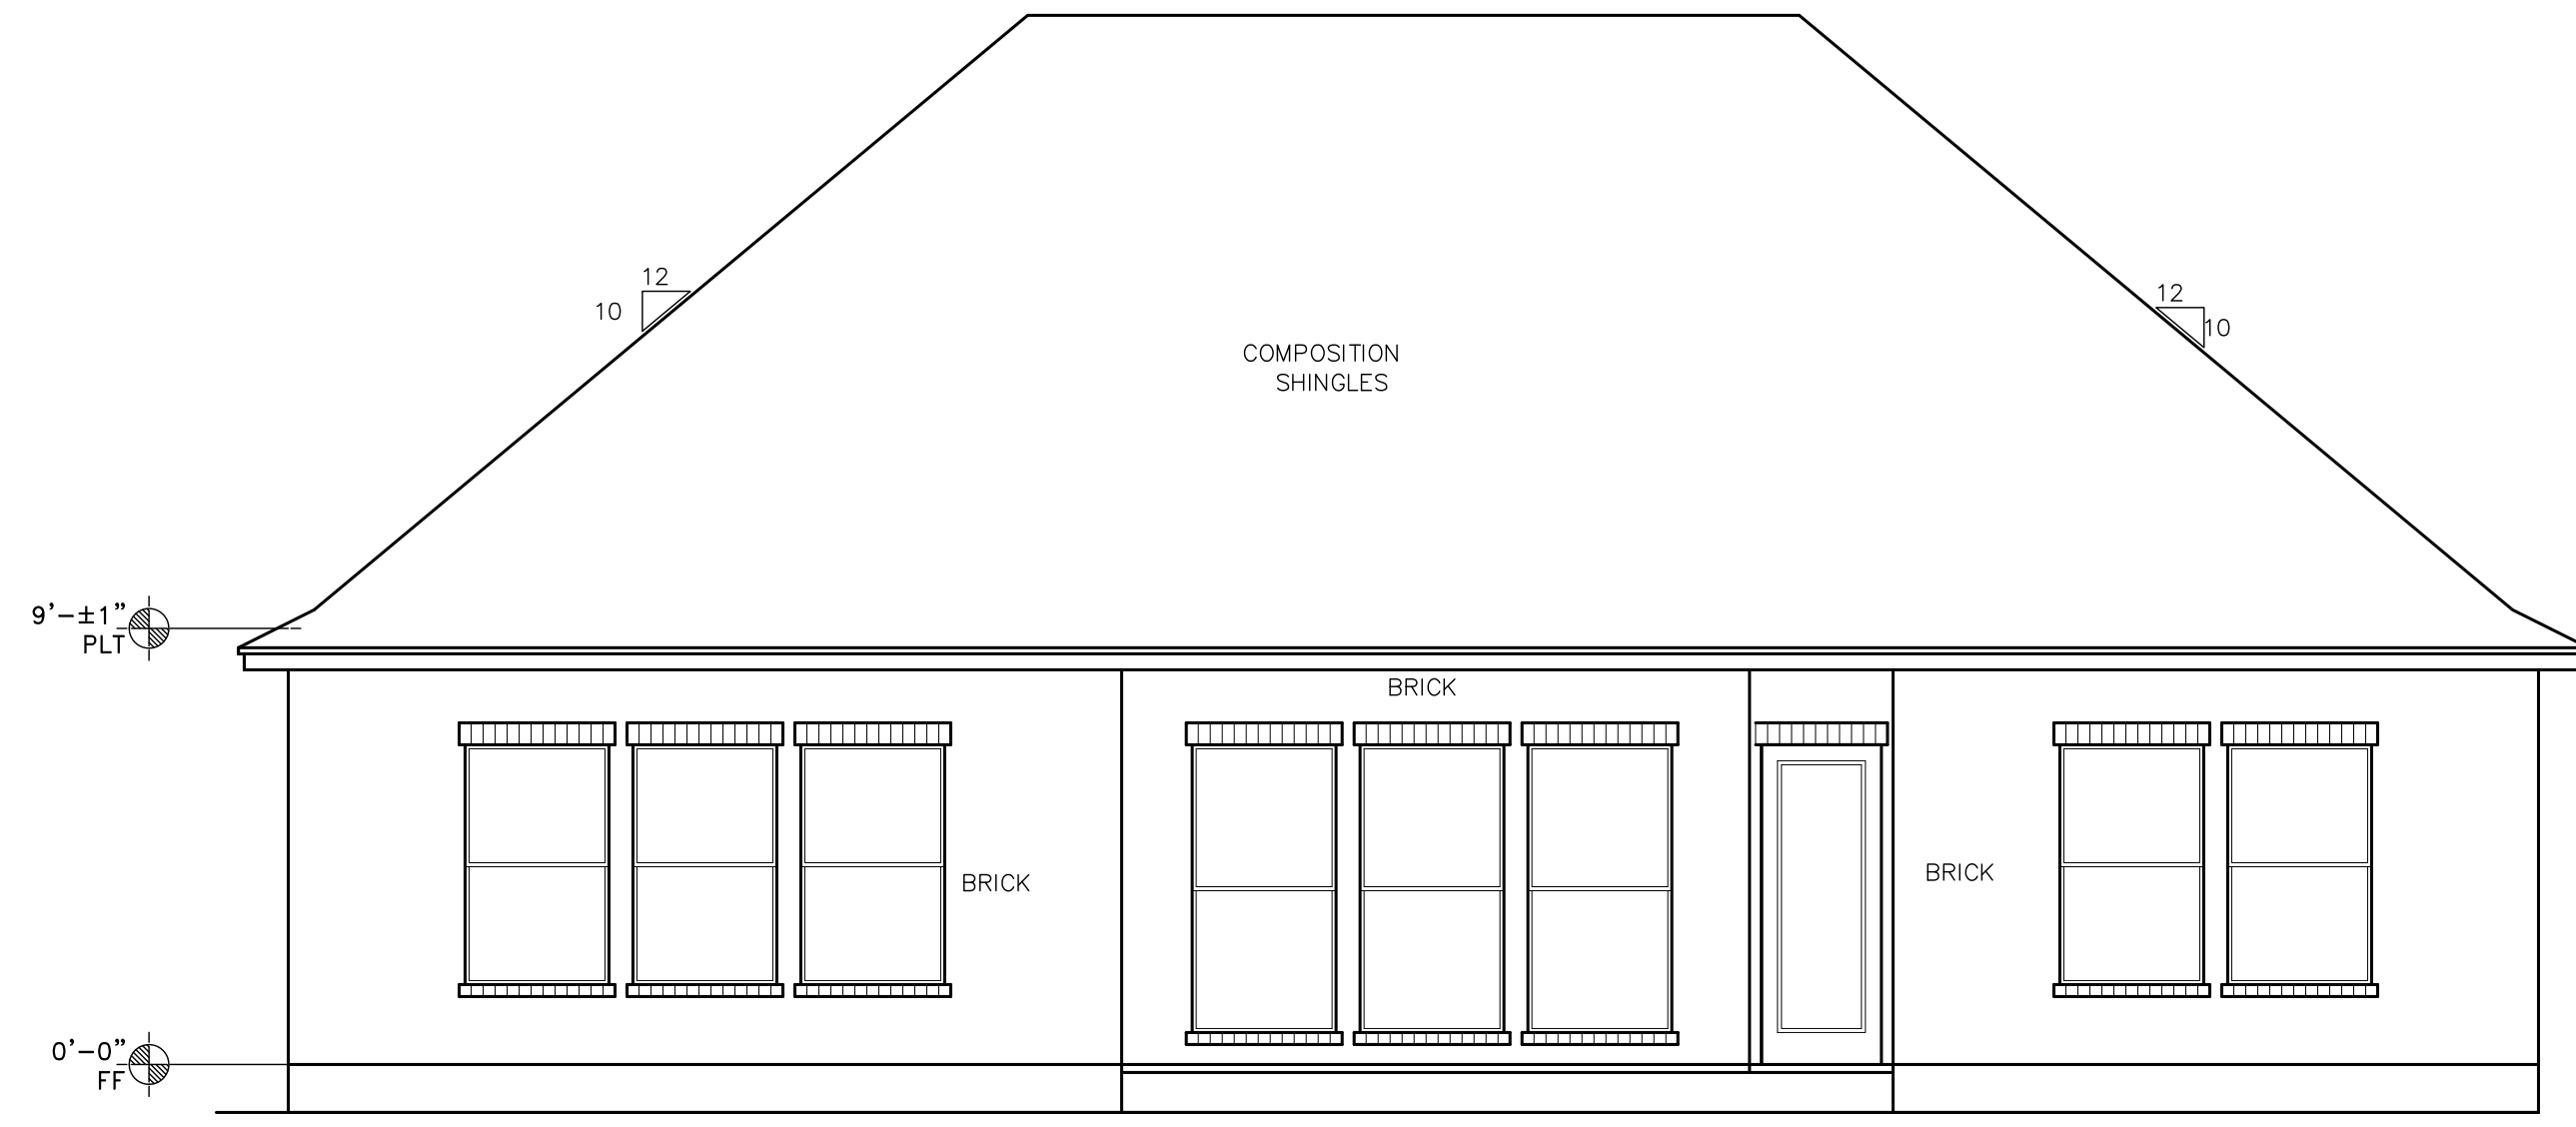

1 REAR VIEW
A2 SCALE: 1/4" = 1'

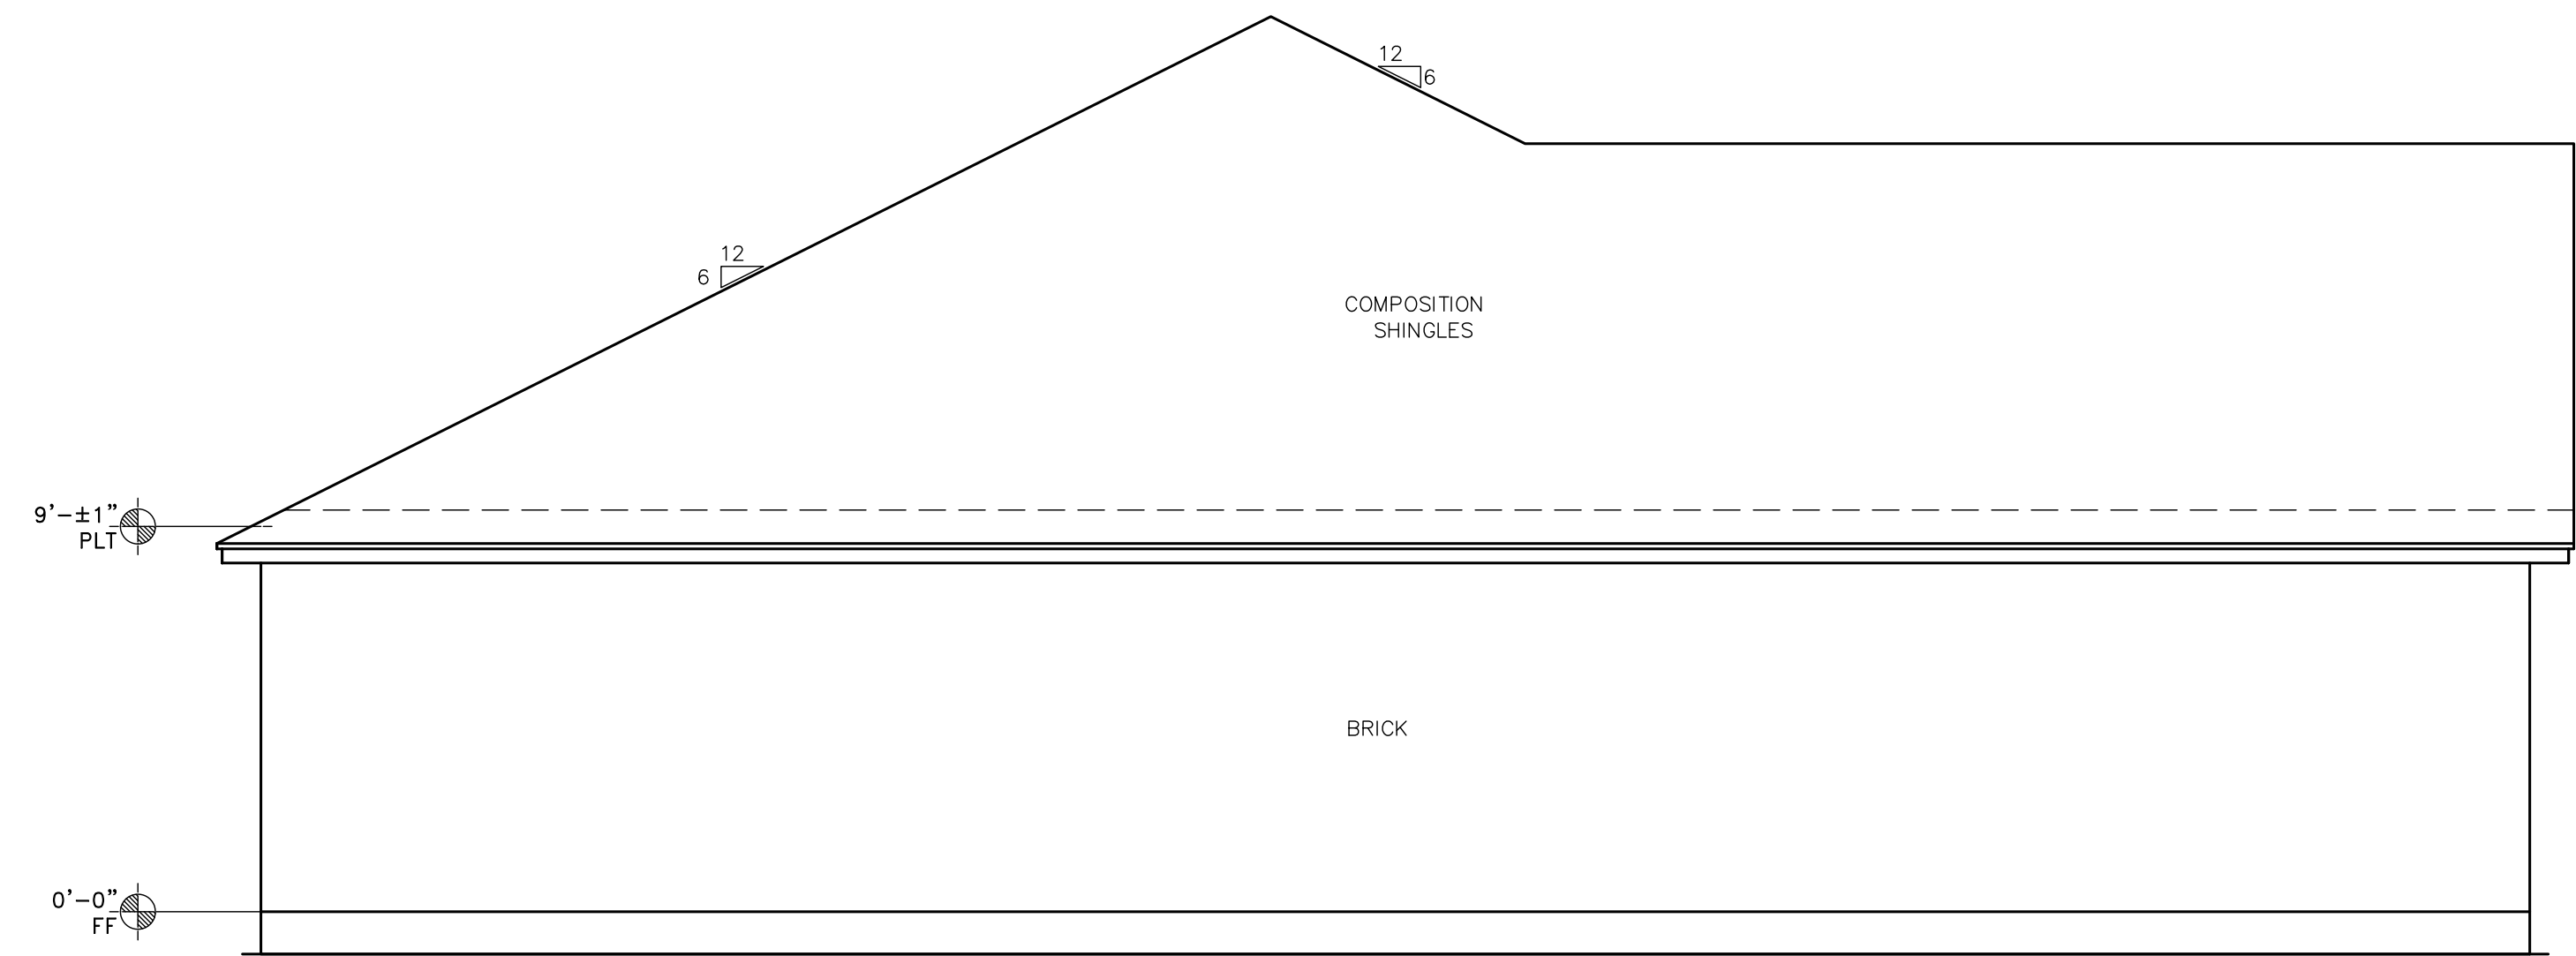

2 LEFT SIDE VIEW
A1 SCALE: 1/4" = 1'

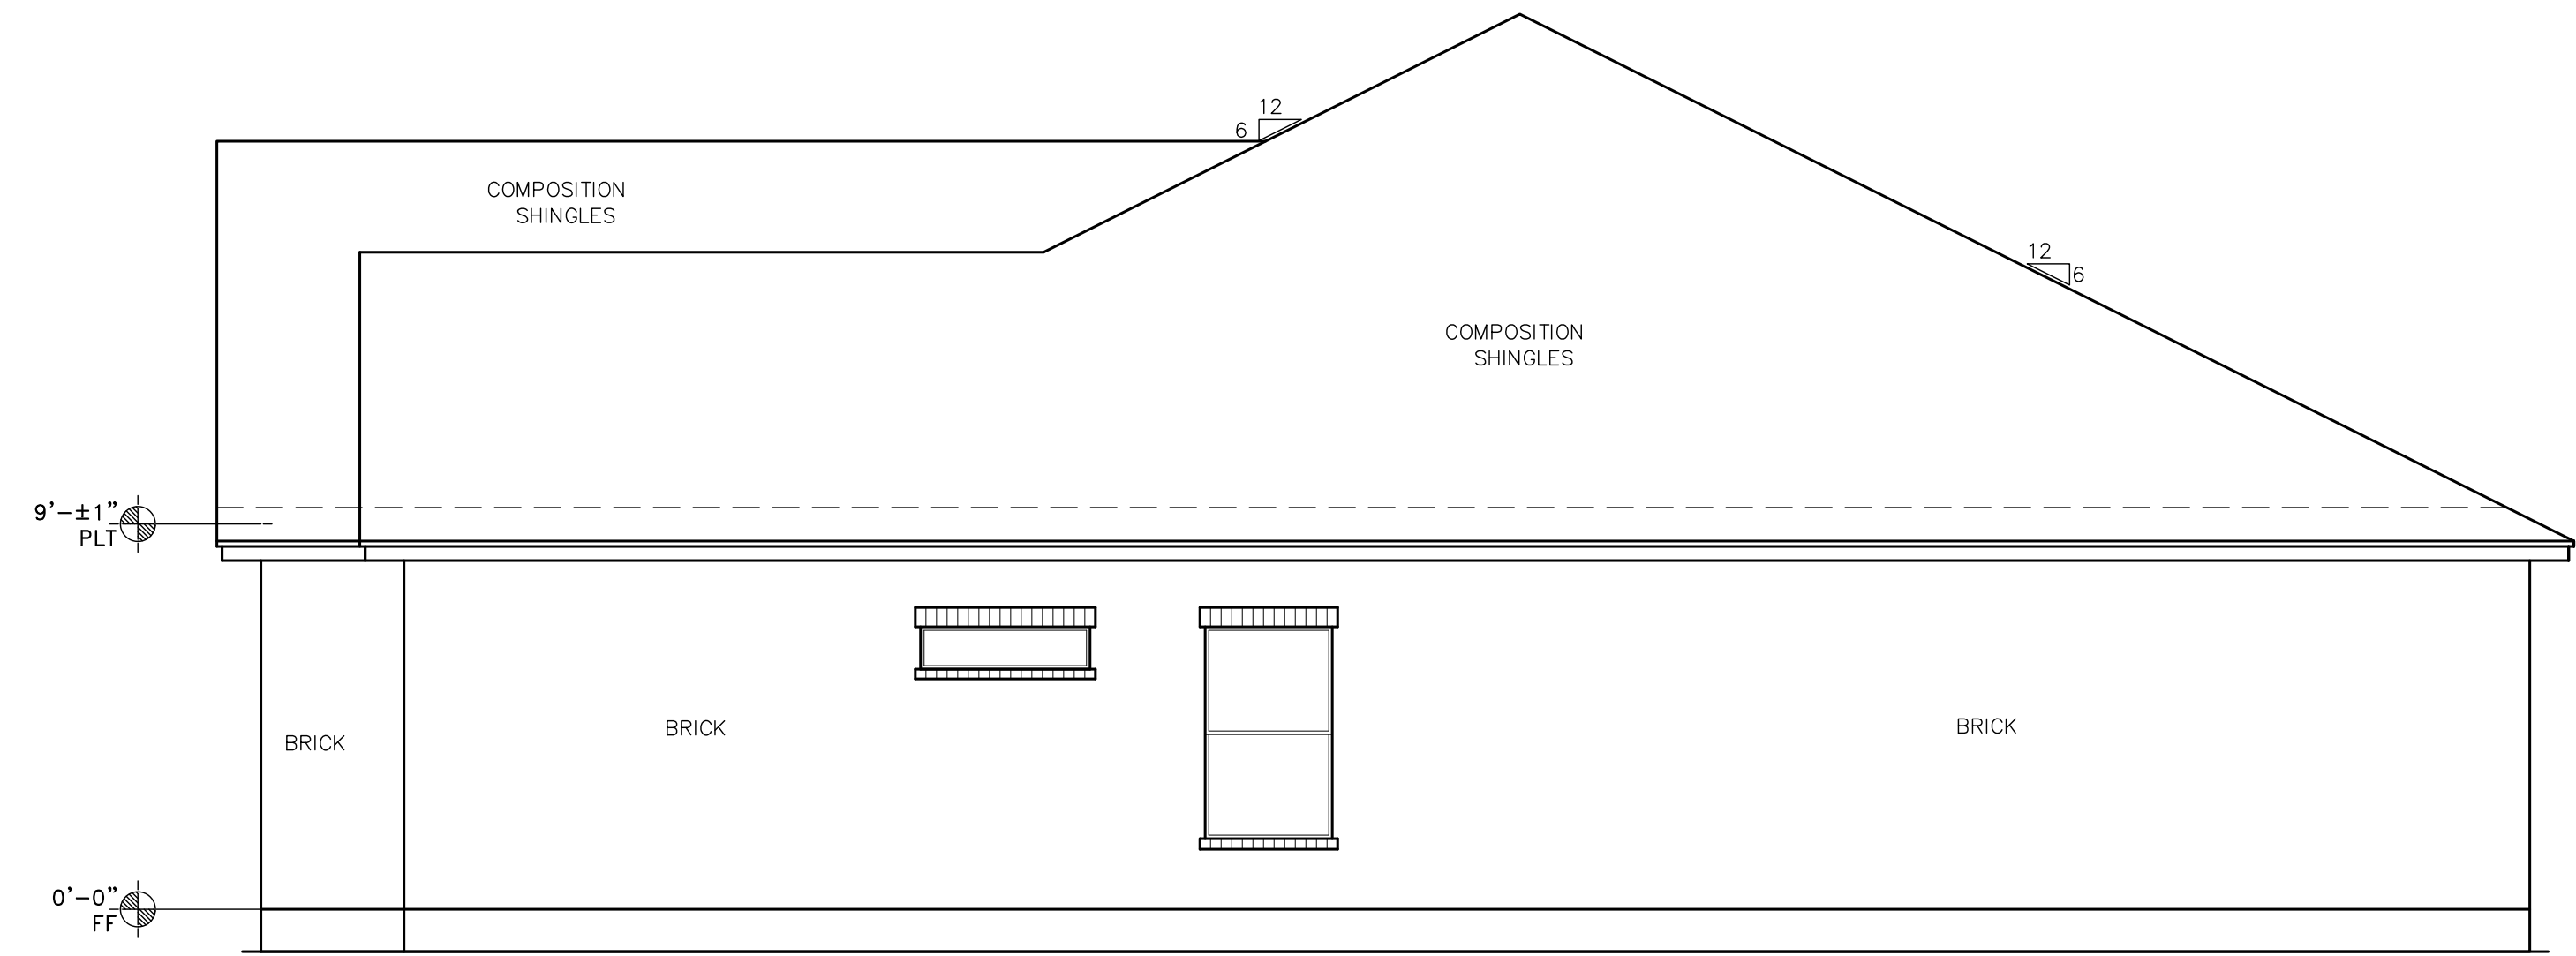

2 RIGHT SIDE VIEW
A2 SCALE: 1/4" = 1'

MOONLIGHT HOUSE PLANS IS A DRAFTING FIRM, NOT AN ENGINEERING OR ARCHITECTURAL FIRM. THESE PRINTS ARE FOR INFORMATION ONLY. MOONLIGHT HOUSE PLANS IS NOT RESPONSIBLE FOR ANY STRUCTURAL OR DESIGN MISTAKES, DIMENSIONS, DETAILS & SPECIFICATIONS. DESIGNER WILL NOT BE LIABLE FOR HUMAN ERROR AFTER CONSTRUCTION IS STARTED. THESE DRAWINGS, SPECIFICATIONS AND IDEAS ARE THE PROPERTY OF MOONLIGHT HOUSE PLANS, AND SHALL NOT BE REUSED, REPRODUCED, OR ALTERED IN ANY WAY.

Moonlight House
Plans
979-482-1967

REVISION HISTORY	DATE
NUMBER	


DWG. SCALE:
1/4" = 1'-0"

E L E V A T I O N S
LAKE JACKSON MANAGEMENT
216 SHANNON STREET - ANGLETON, TEXAS
JOB #: 20213935

04-13-21

A1


ABBREVIATIONS							
SH	SINGLE HUNG	EB	EYE BROW	PAN	PANTRY	W.I.C.	WALK-IN CLOSET
DL	DIVIDED LIGHTS	PKT	POCKET	RM	ROOM	DBL	DOUBLE
HD	HEADER	DR	DOOR	CLST	CLOSET	SNK	SINK
HT	HEIGHT	FG	FIXED GLASS	SHLVS	SHELVES	DW	DISH WASHER
OH	OVERHEAD	OBSCG	OBSCURED GLASS	CW	COLD WATER TAP	MSTR	MASTER
SECT	SECTIONAL	BTH	HALF BATH	CLG	CEILING		

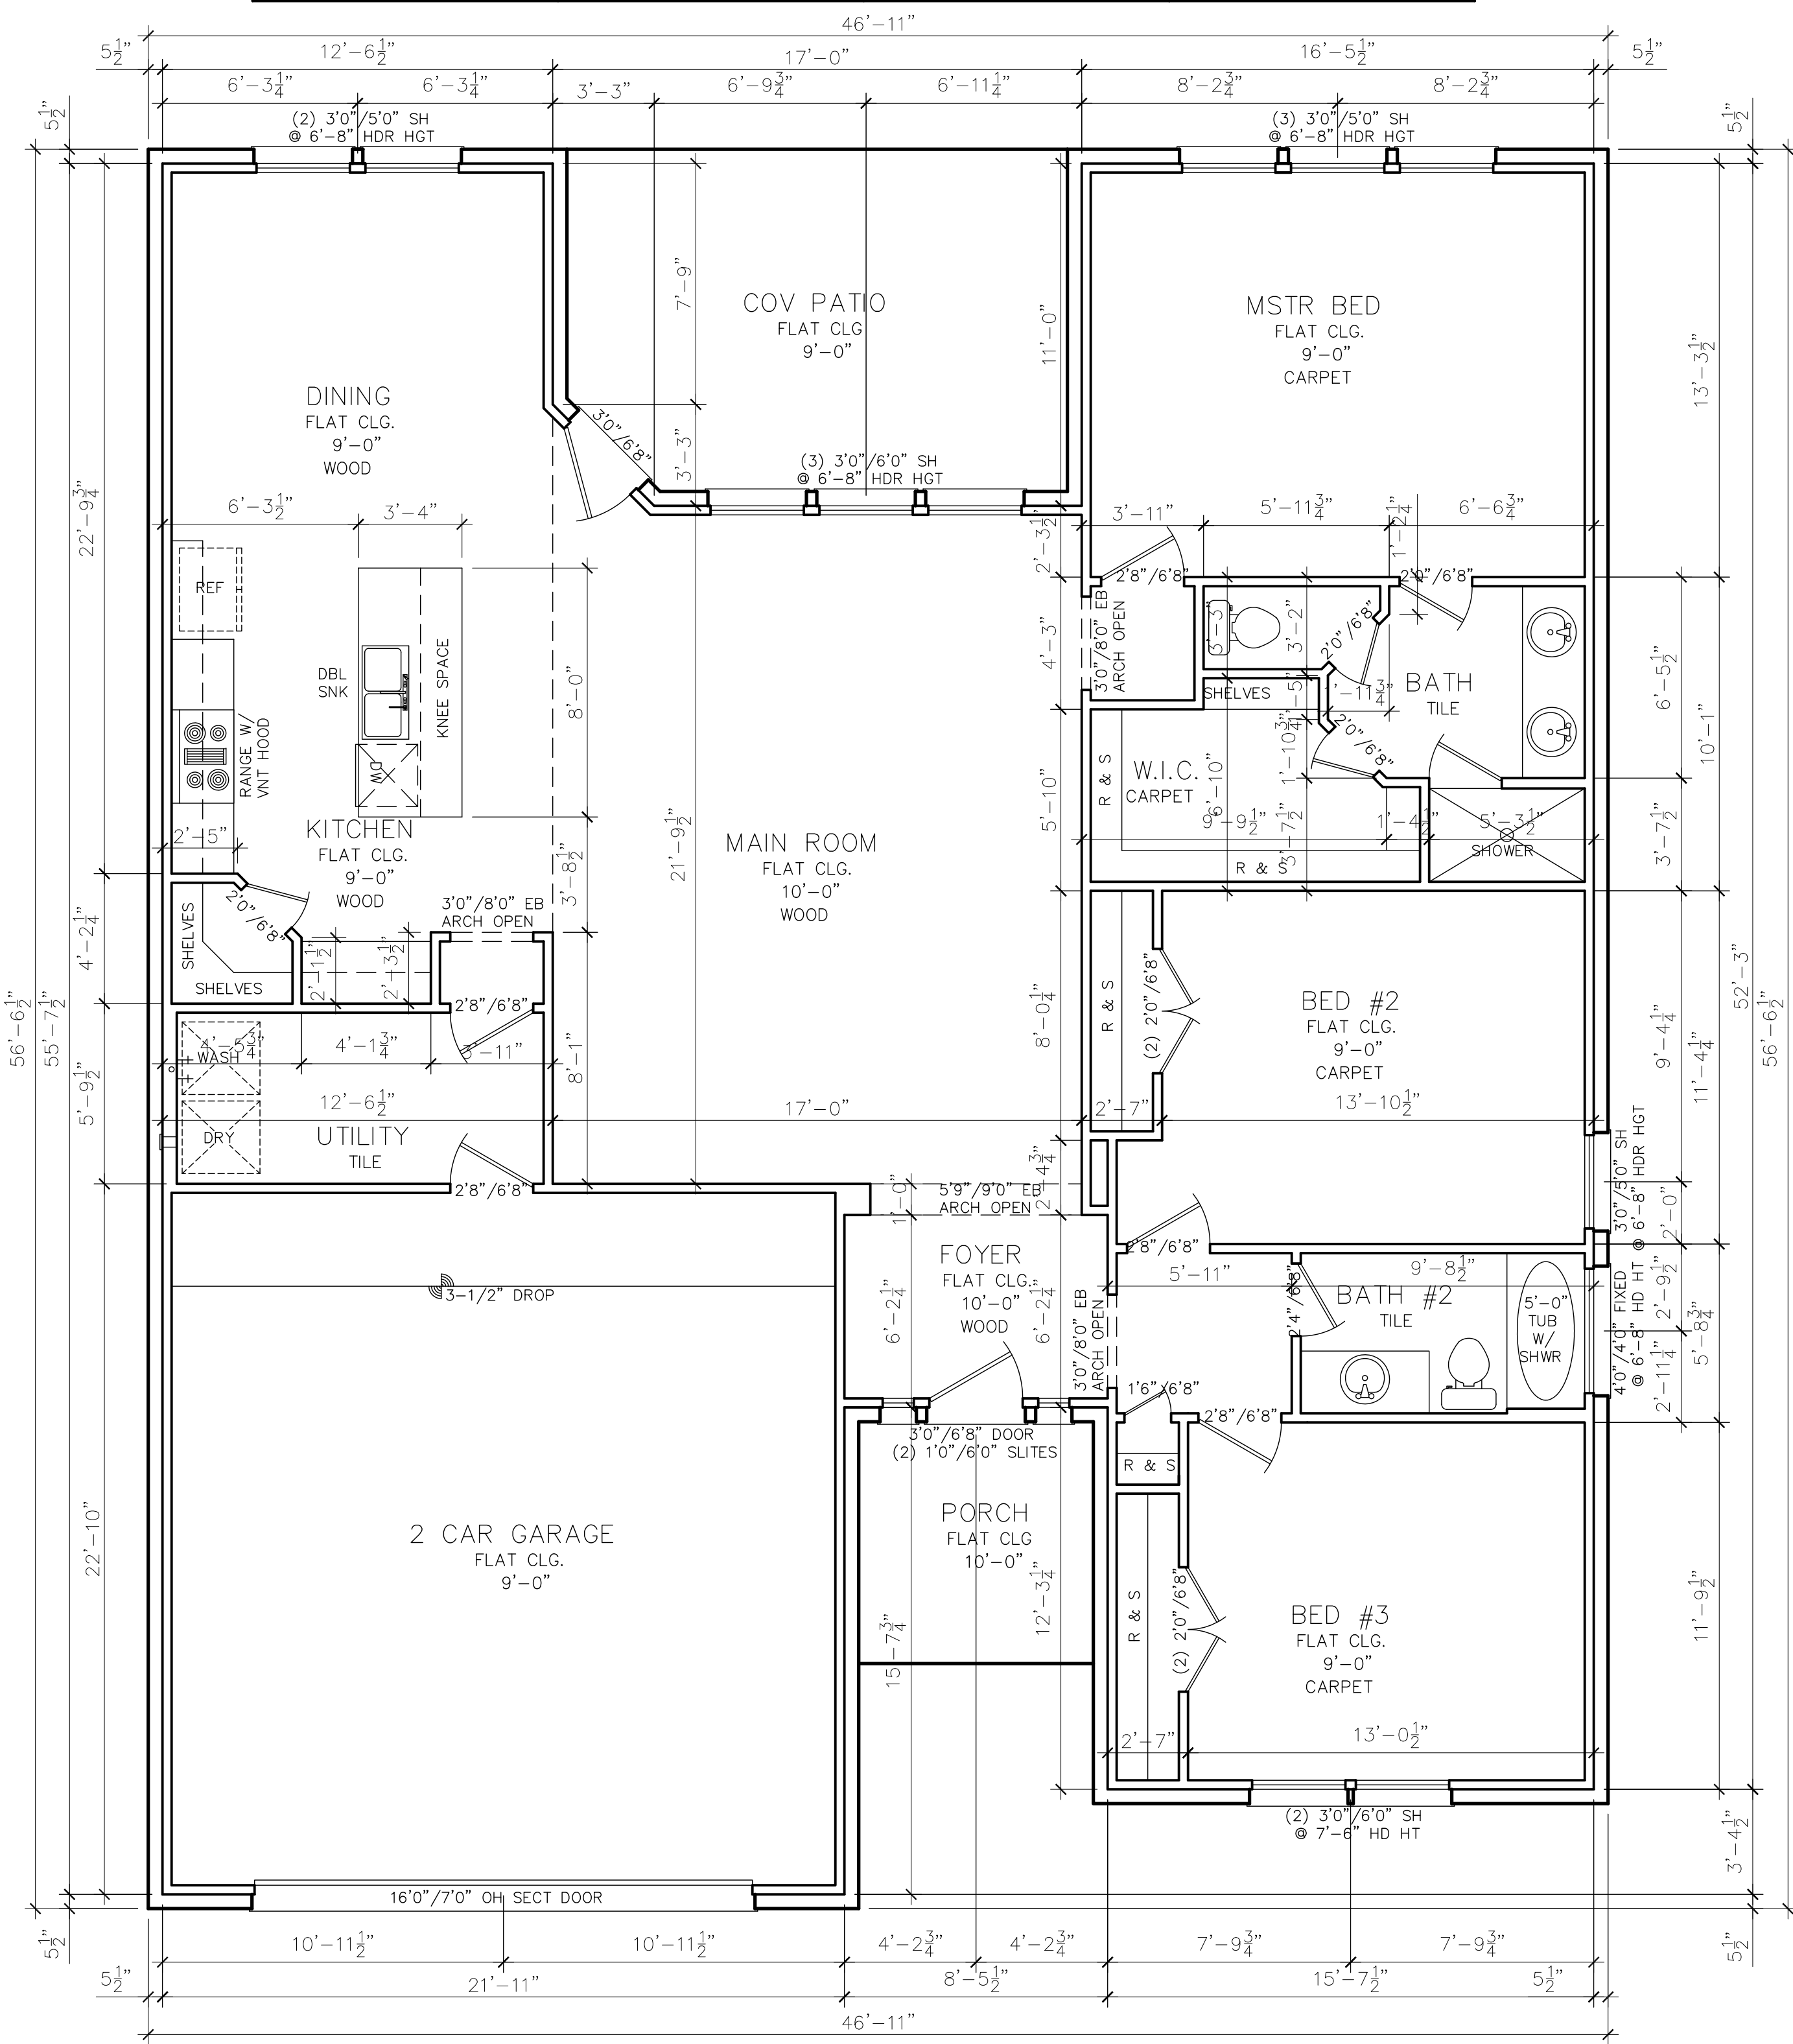

1 FLOOR PLAN
SCALE: 1/4" = 1'

ELECTRICAL LEGEND	
SYMBOL	DESCRIPTION
	RECESSED LIGHT FIXTURE
	CEILING MOUNTED LIGHT FIXTURE
	WALL MOUNT LIGHT FIXTURE
	VENT
	SMOKE DETECTOR
	220 V. DUPLEX RECEPT OUTLET
	110 V. DUPLEX RECEPT OUTLET
	110 V. FLOOR OUTLET
	GROUND FAULT INTERRUPTER DUPLEX RECEPTACLE OUTLET
	WATER PROOF OUTLET
	SINGLE POLE SWITCH
	2 WAY SWITCH
	DIMMER SWITCH
	2 WAY SWITCH WITH DIMMER
	PUSH BUTTON GARAGE DOOR
	DOOR BELL
	CHIME
	TELEVISION JACK
	PHONE JACK
	GAS LINE CONNECTION
	GARAGE DOOR OPENER
	JUNCTION BOX
	FLOOD LIGHTS

ELECTRICAL NOTES:
 -SMOKE DETECTORS IN ALL BED ROOMS, REQUIRE 110V TO HOUSE WIRING, BATTERY BACKUP & INTERCONNECT
 -VENT ALL EXHAUST FANS TO OUTSIDE
 -PROVIDE G.F.I. PROTECTION ON BATH PLUGS
 -PROVIDE LIGHT FIXTURE & SMOKE DETECTORS AT WATER HEATER & A/C UNIT
 -PROVIDE ELECTRIC DISCONNECT AT A/C UNIT

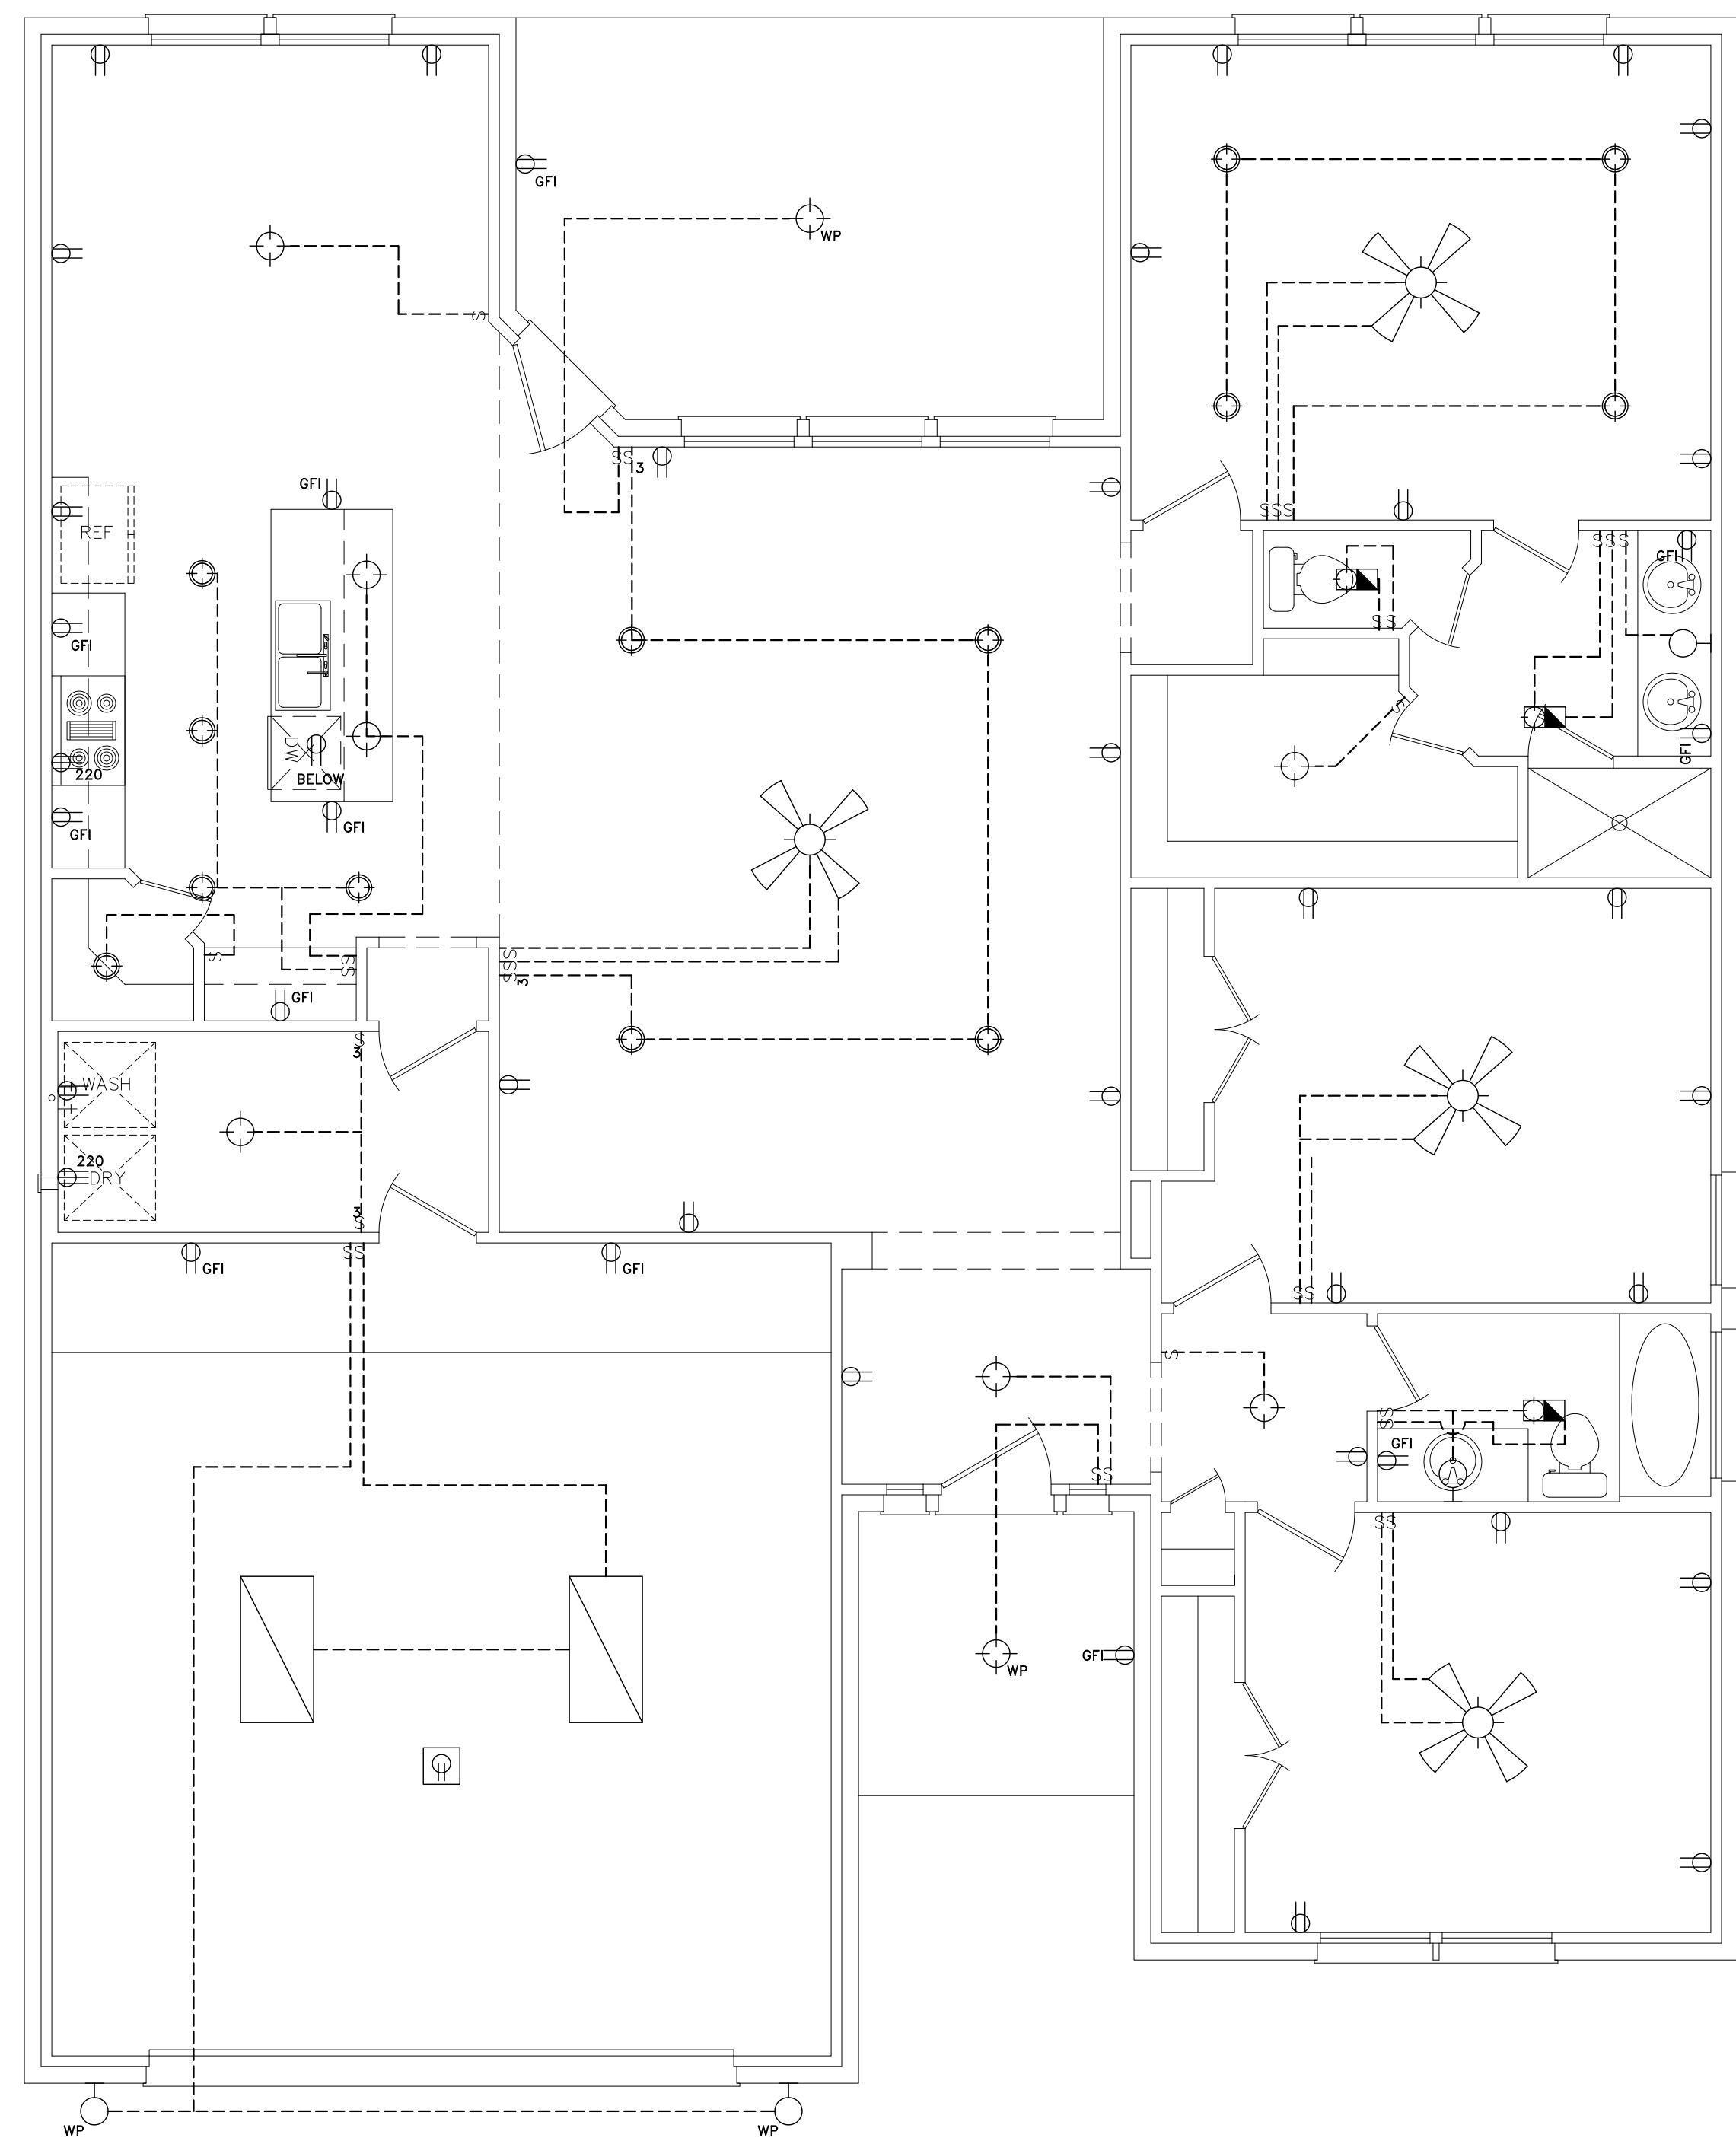

2 ELECTRICAL
SCALE: 1/4" = 1'

MOONLIGHT HOUSE PLANS IS A DRAFTING FIRM, NOT AN ENGINEERING OR ARCHITECTURAL FIRM. THESE PRINTS ARE NOT TO BE USED FOR ANY STRUCTURAL OR DESIGN MISTAKES. DIMENSIONS, DETAILS & SPECIFICATIONS. DESIGNER WILL NOT BE LIABLE FOR HUMAN ERROR AFTER CONSTRUCTION IS STARTED. THESE DRAWINGS, SPECIFICATIONS AND IDEAS ARE THE PROPERTY OF MOONLIGHT HOUSE PLANS, AND SHALL NOT BE REUSED, REPRODUCED, OR ALTERED IN ANY WAY.

Moonlight House Plans
979-482-1967


REVISION HISTORY	DATE
NUMBER	

DWG. SCALE: 1/4" = 1'-0"

FLOOR PLAN
LAKE JACKSON MANAGEMENT
216 SHANNON STREET - ANGLETON, TEXAS
JOB #: 20213935

04-13-21

A2

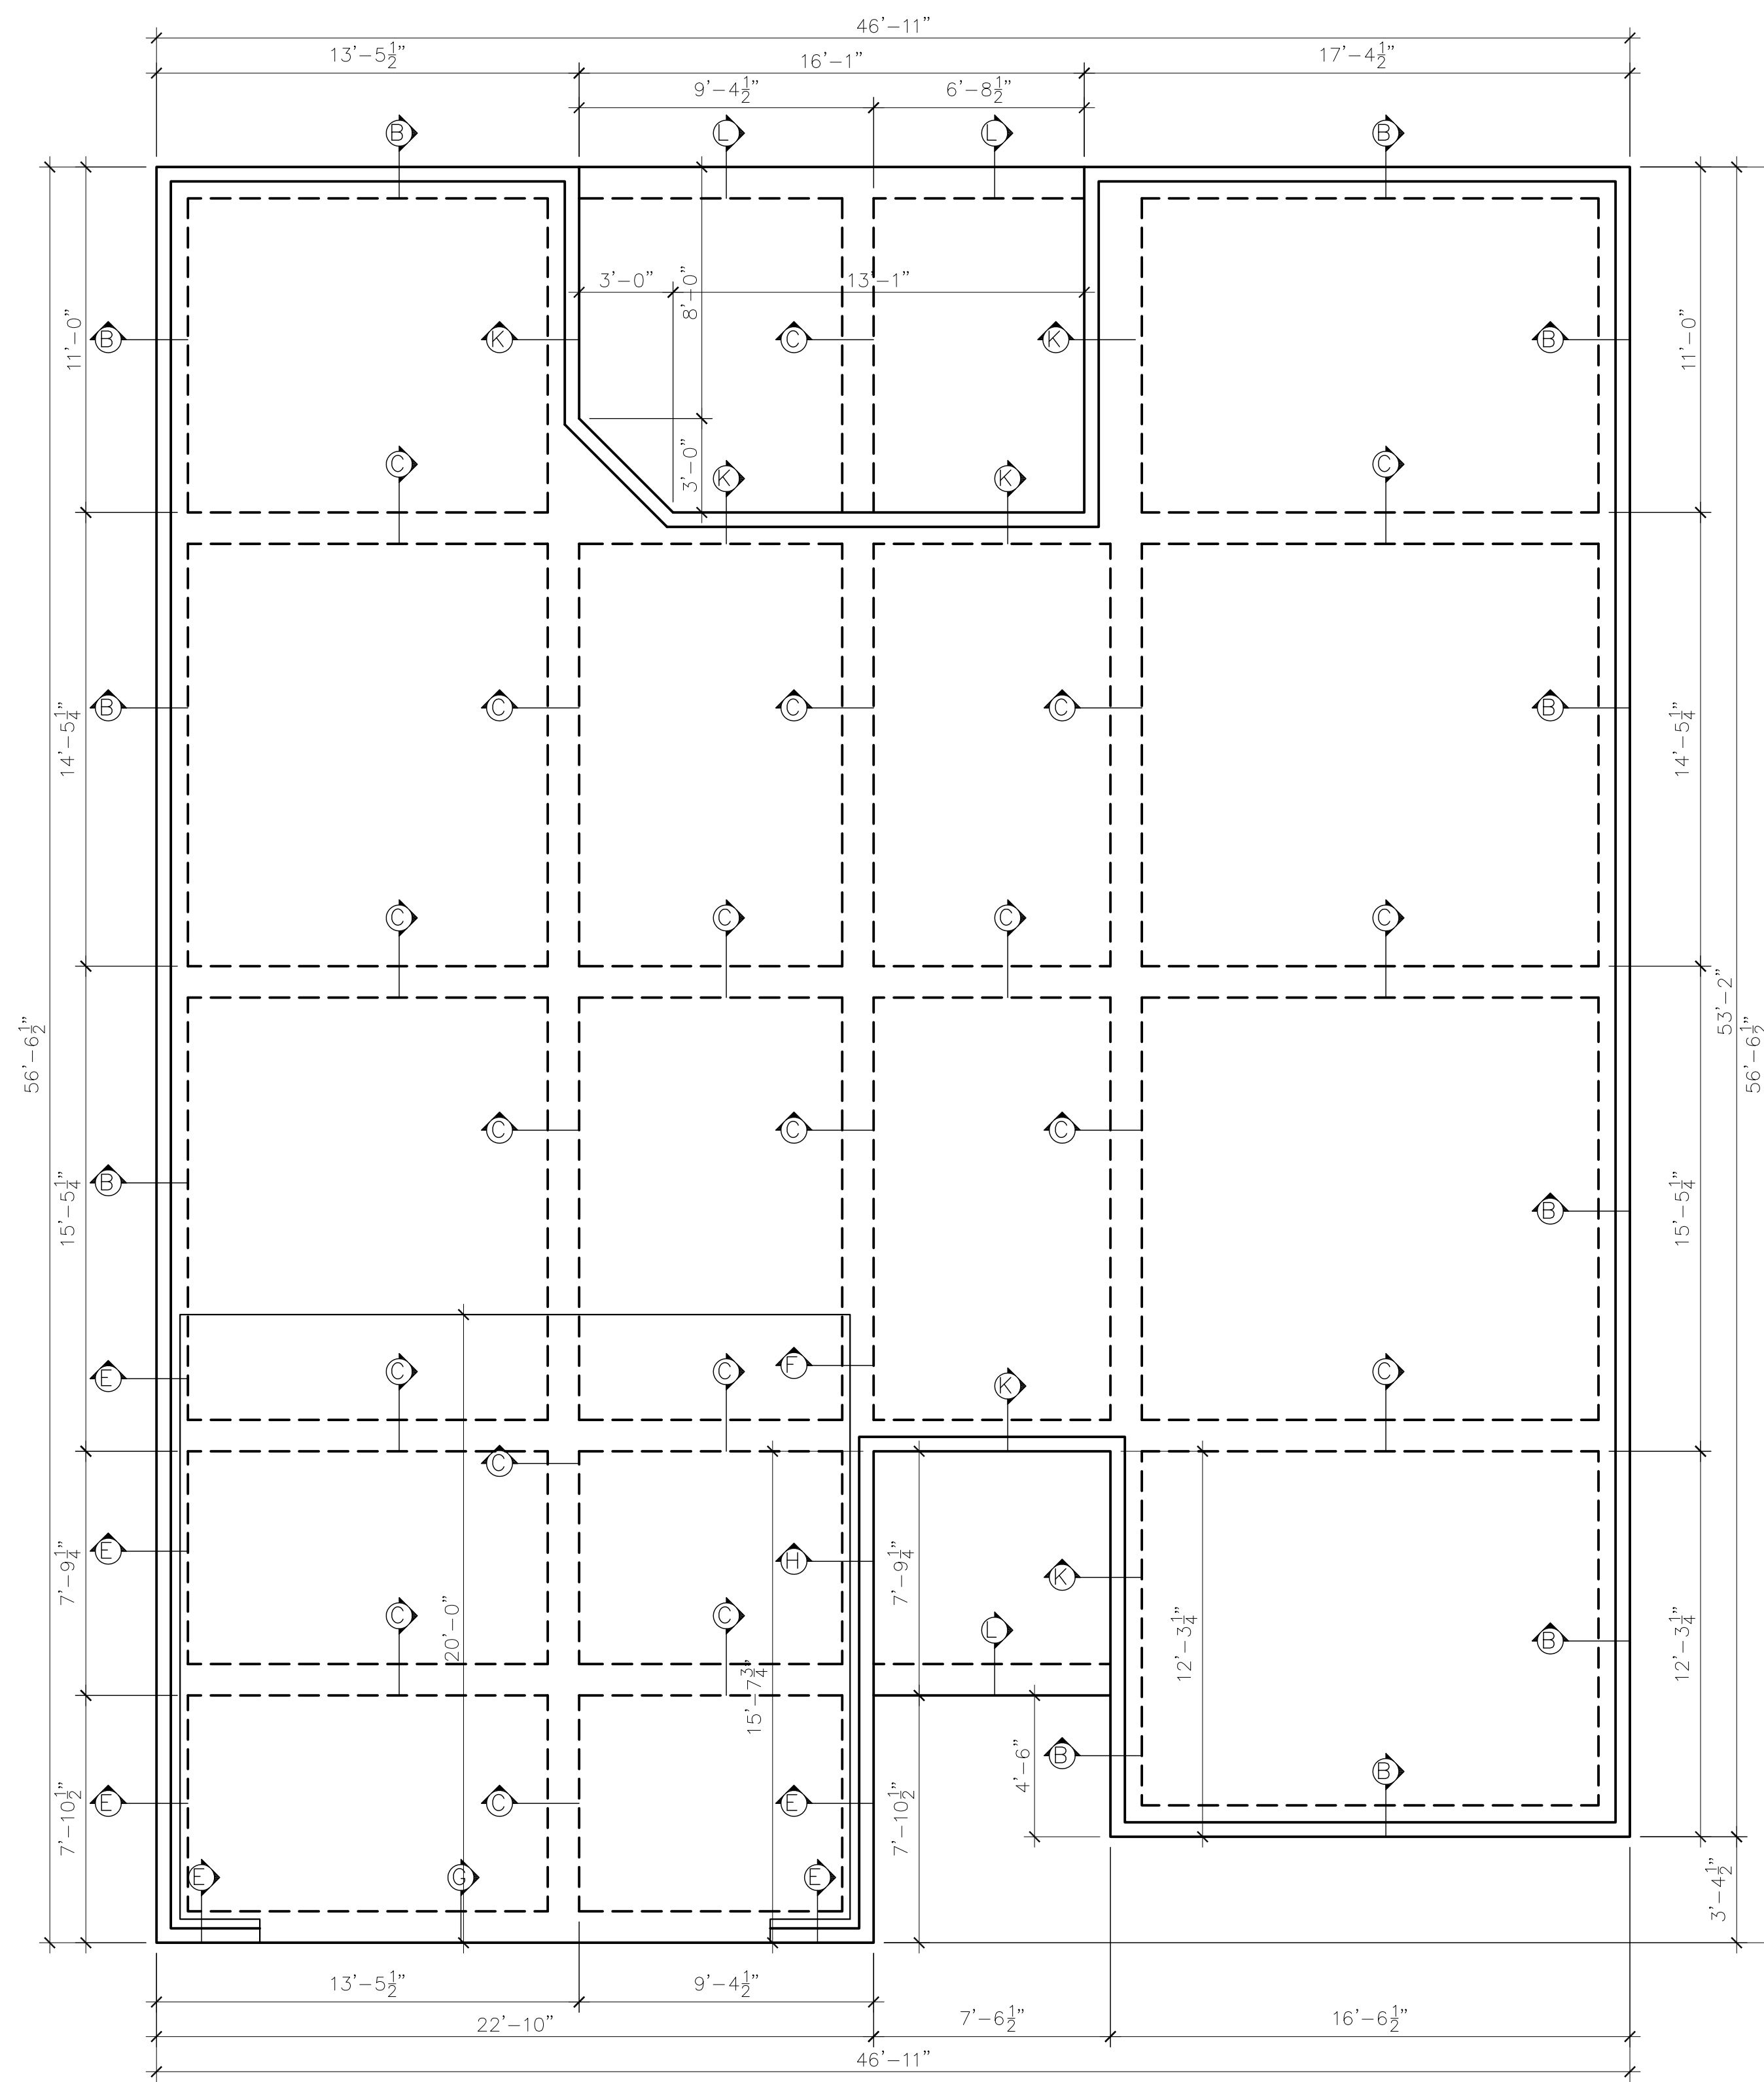

1 FOUNDATION
 S1 SCALE: 1/4" = 1'

MOONLIGHT HOUSE PLANS IS A DRAFTING FIRM, NOT AN ENGINEERING OR ARCHITECTURAL FIRM. THESE PRINTS ARE NOT TO BE USED FOR CONSTRUCTION OR FOR ANY OTHER PURPOSES WITHOUT THE WRITTEN PERMISSION OF MOONLIGHT HOUSE PLANS. MOONLIGHT HOUSE PLANS IS NOT RESPONSIBLE FOR ANY STRUCTURAL OR DESIGN MISTAKES, OMISSIONS, ERRORS, OR INACCURACIES IN THE PLANS, DIMENSIONS, DETAILS & SPECIFICATIONS. DESIGNER WILL NOT BE LIABLE FOR HUMAN ERROR AFTER CONSTRUCTION IS STARTED. THESE DRAWINGS, SPECIFICATIONS AND IDEAS ARE THE PROPERTY OF MOONLIGHT HOUSE PLANS, AND SHALL NOT BE REUSED, REPRODUCED, OR ALTERED IN ANY WAY.

Moonlight House
 Plans
 979-482-1967

REVISION NUMBER	HISTORY	DATE


DWG. SCALE:
 1/4" = 1'-0"

E O U N D A T I O N
 LAKE JACKSON MANAGEMENT
 216 SHANNON STREET - ANGLETON, TEXAS
 JOB #: 20213935


04-13-21

S1


A - A PERIMETER BEAM

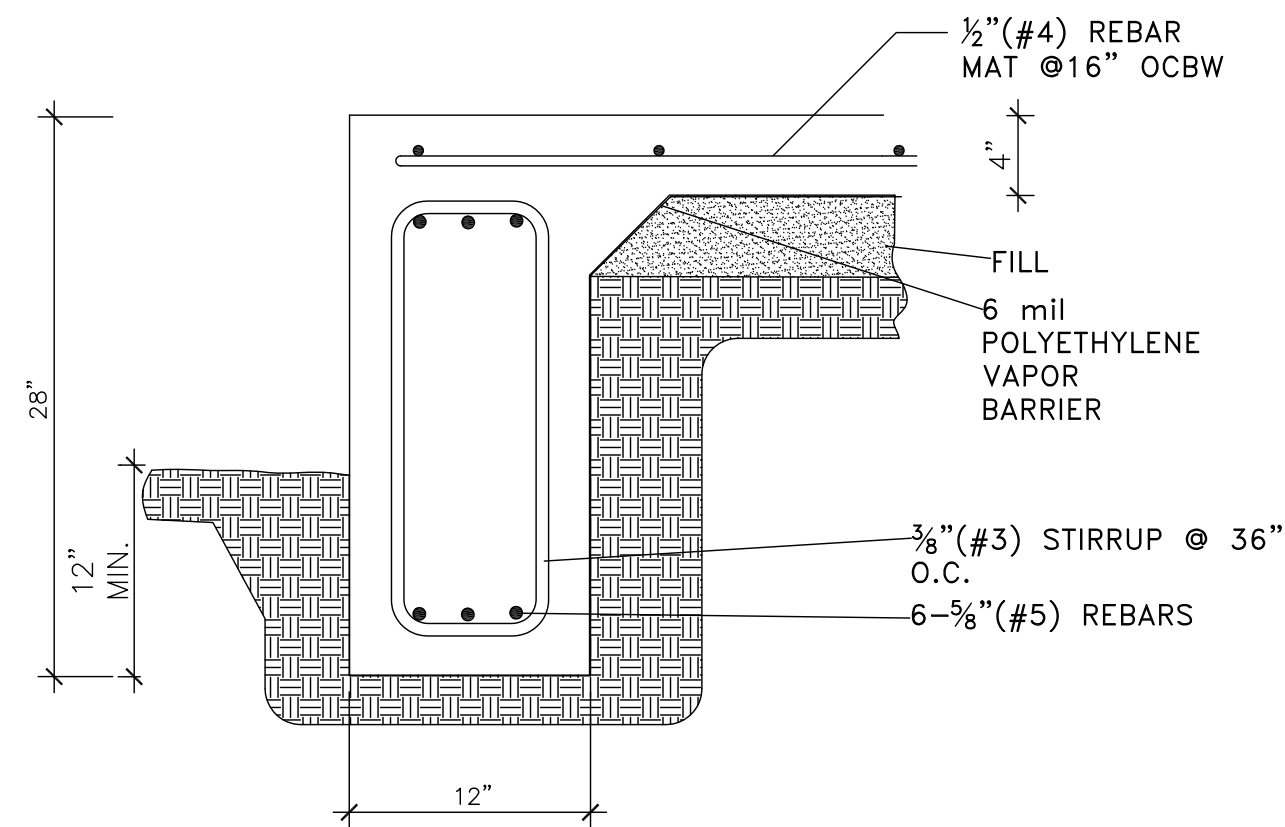


B - B PERIMETER BEAM with BRICK LEDGE

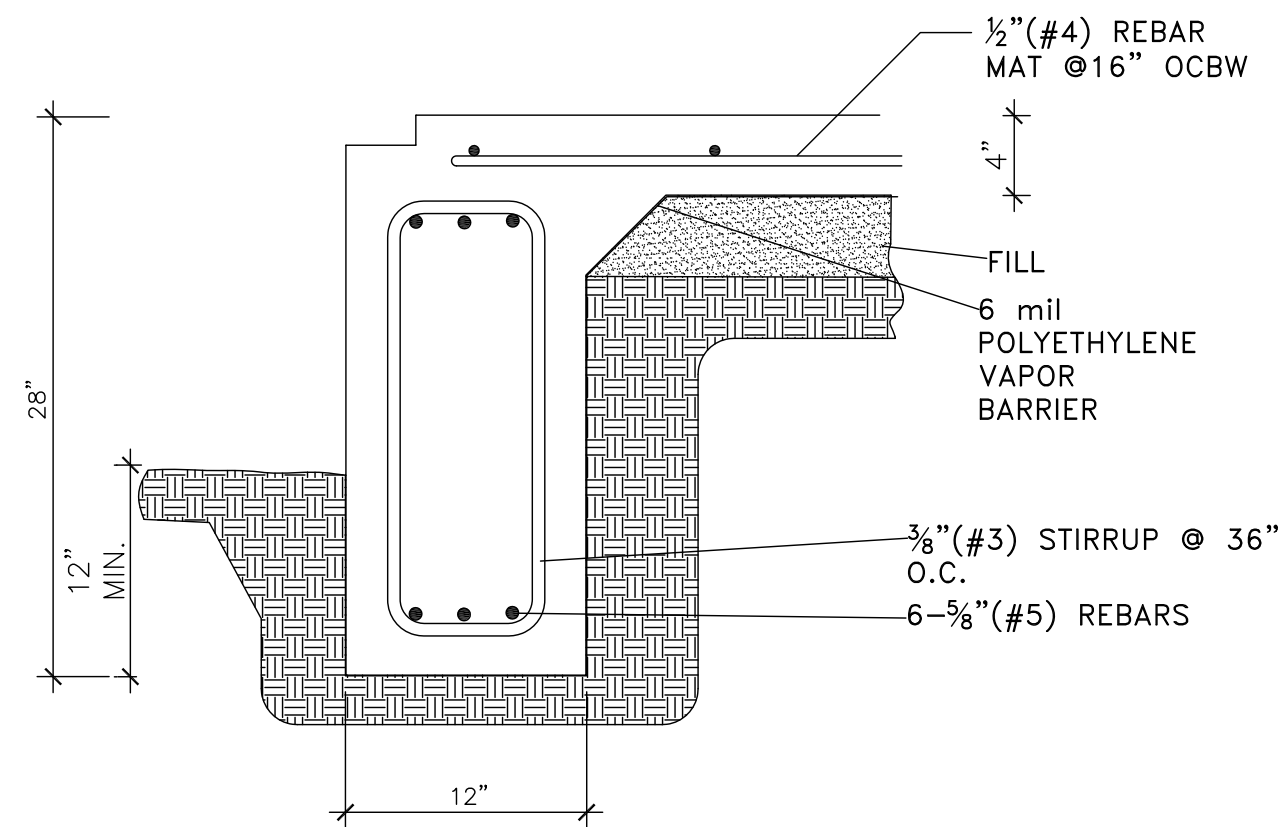


C - C INTERIOR BEAM

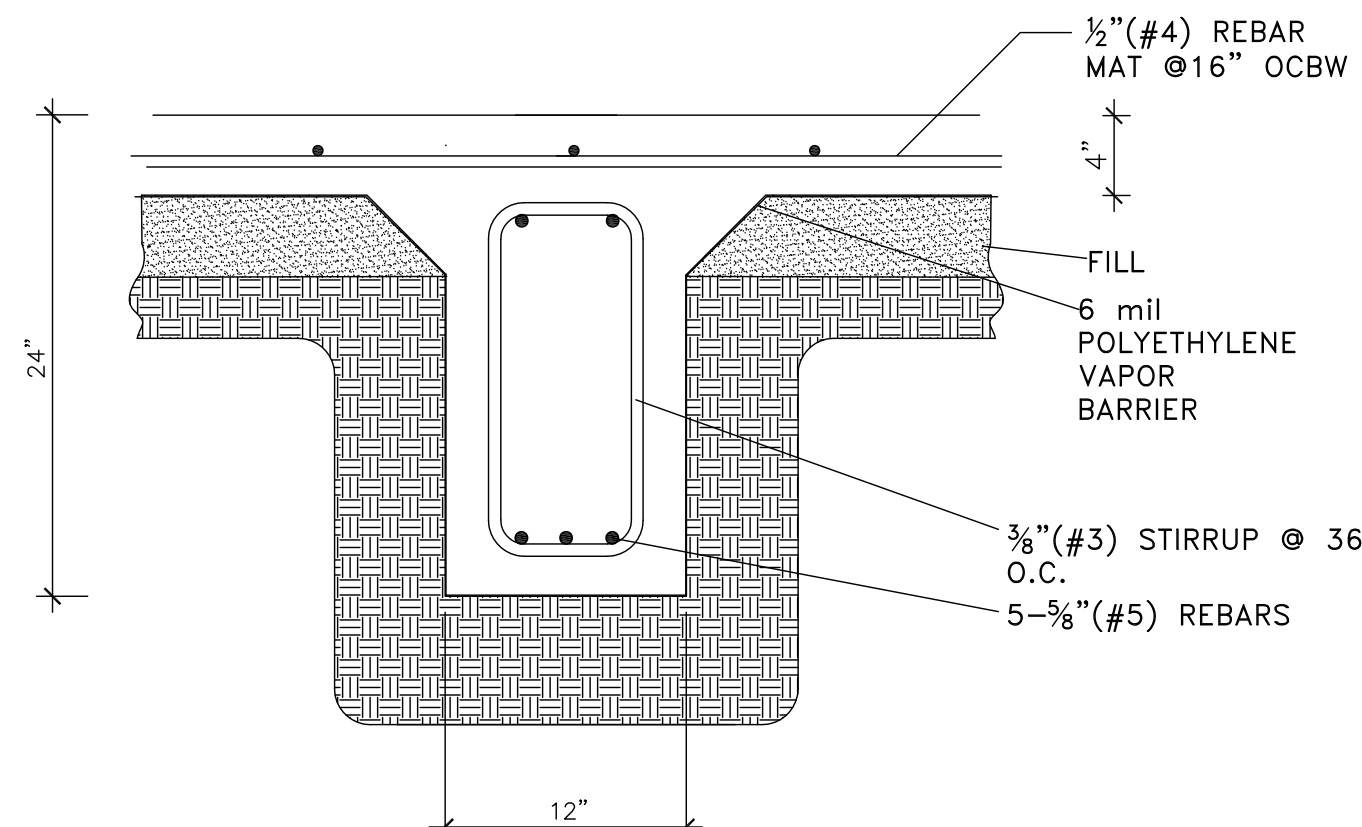


D - D PERIMETER BEAM AT GARAGE

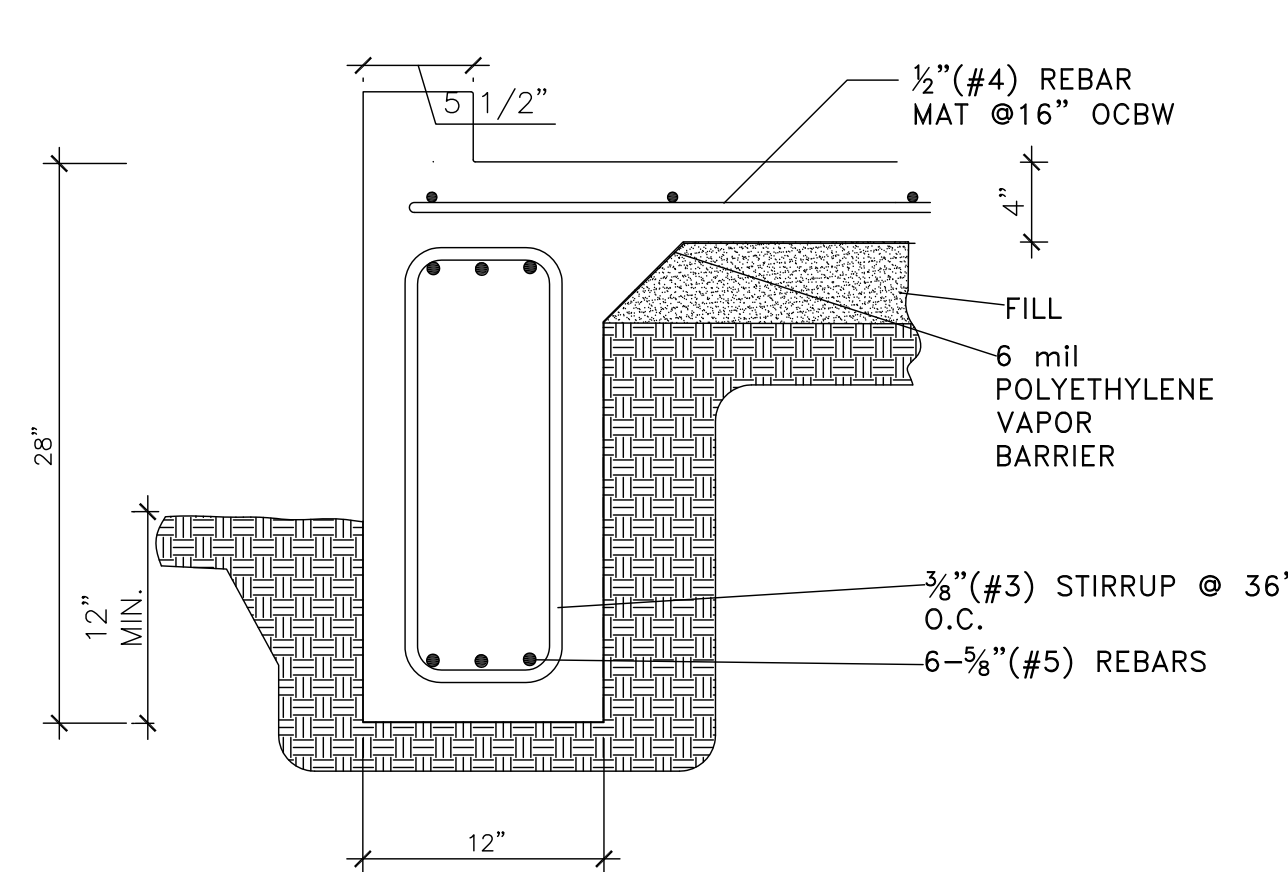


E - E PERIMETER BEAM with BRICK LEDGE

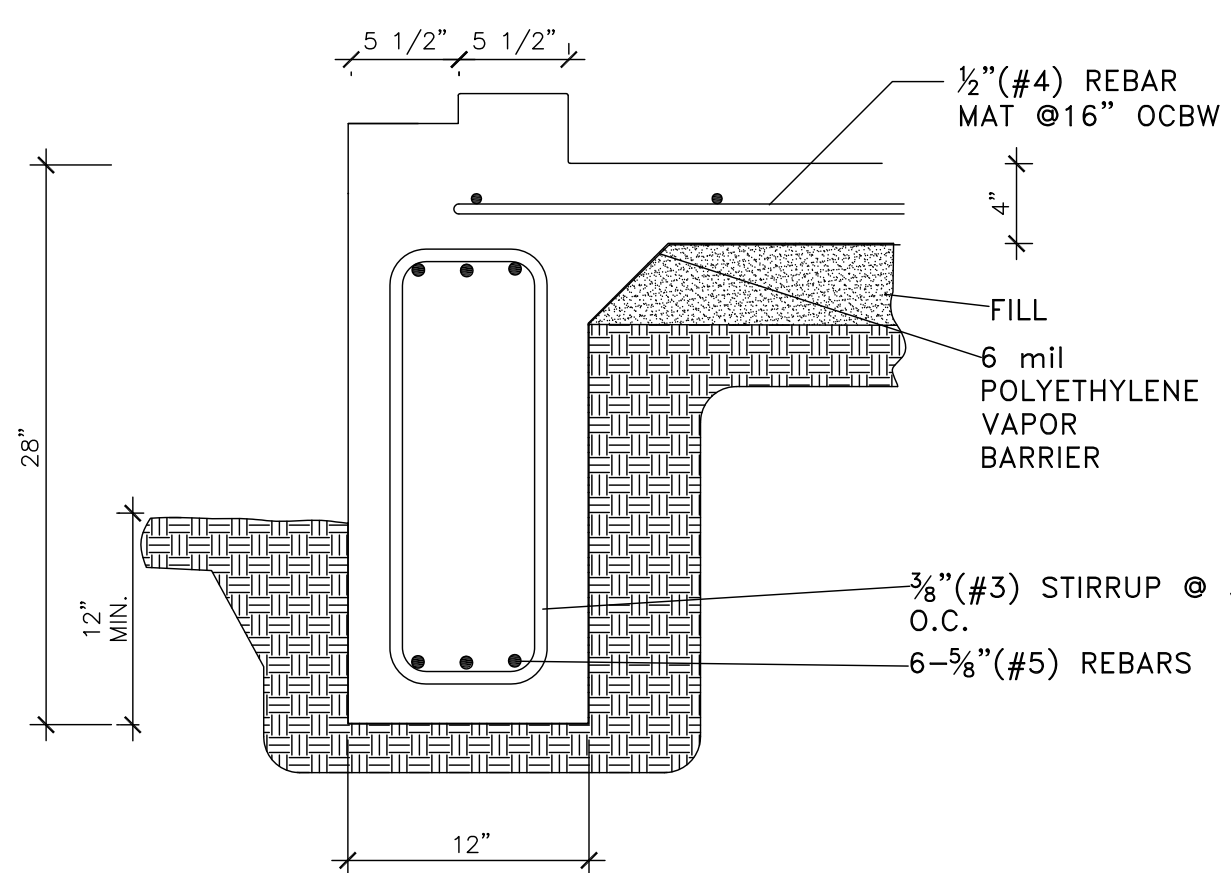


F - F INTERIOR DROP AT GARAGE

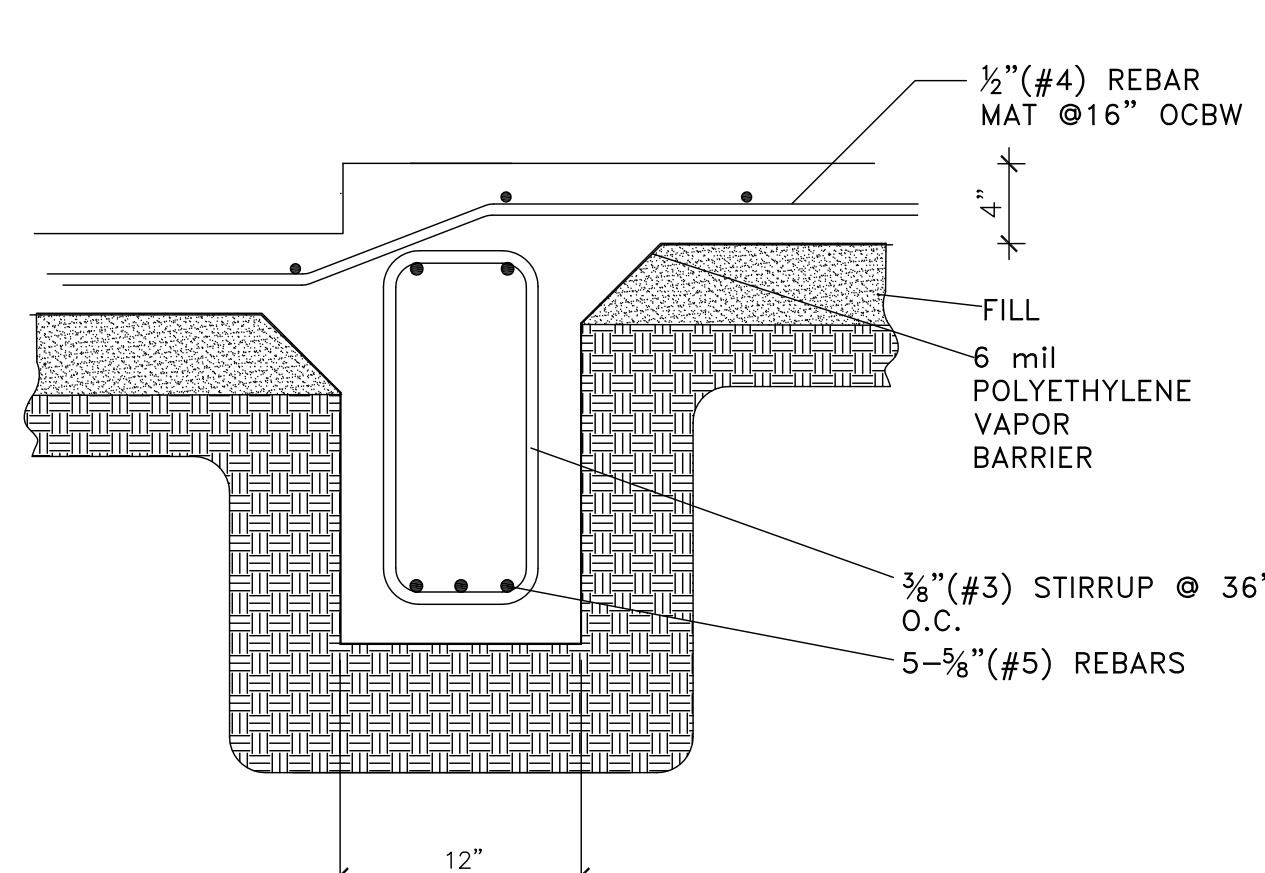


G - G PERIMETER BEAM AT GARAGE DOOR

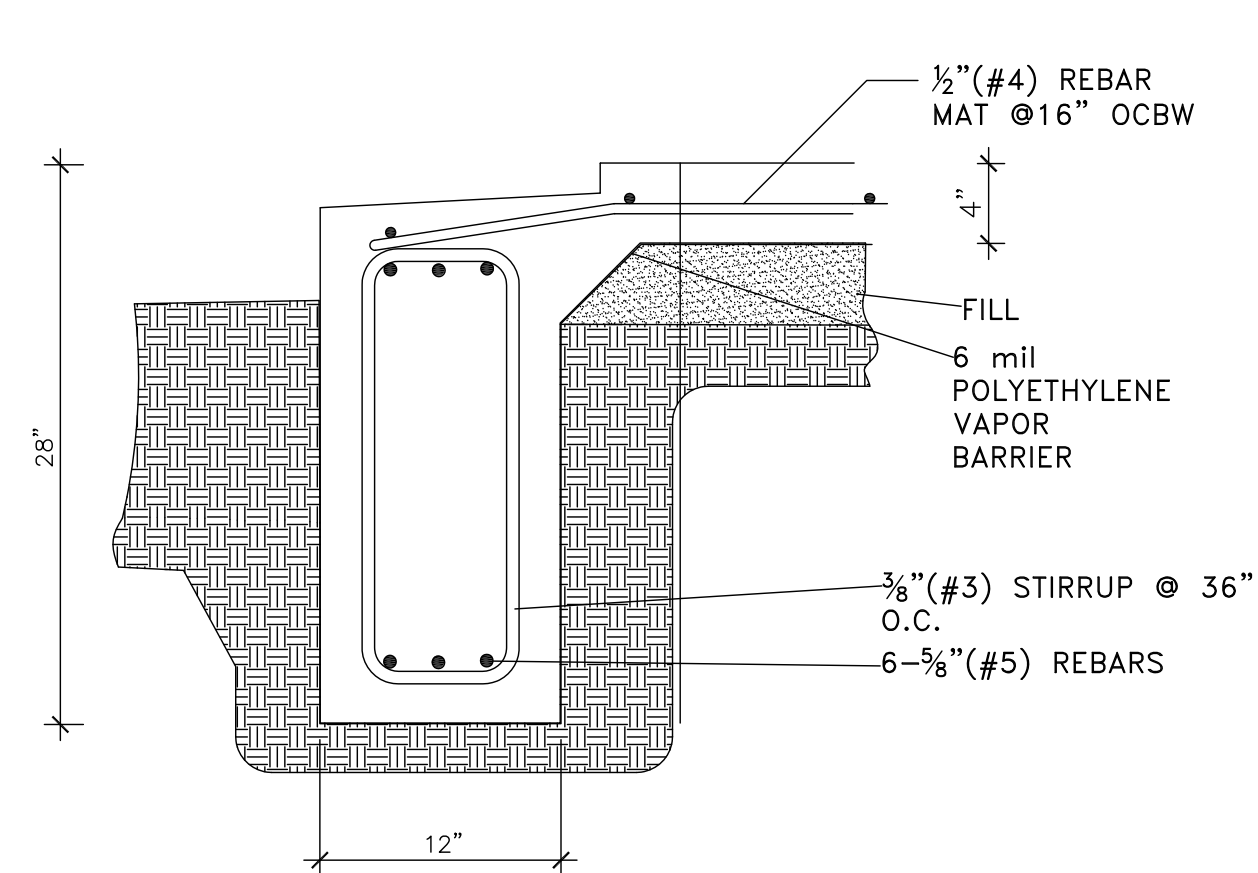


H - H INTERIOR BRICK BEAM AT GARAGE/PORCH

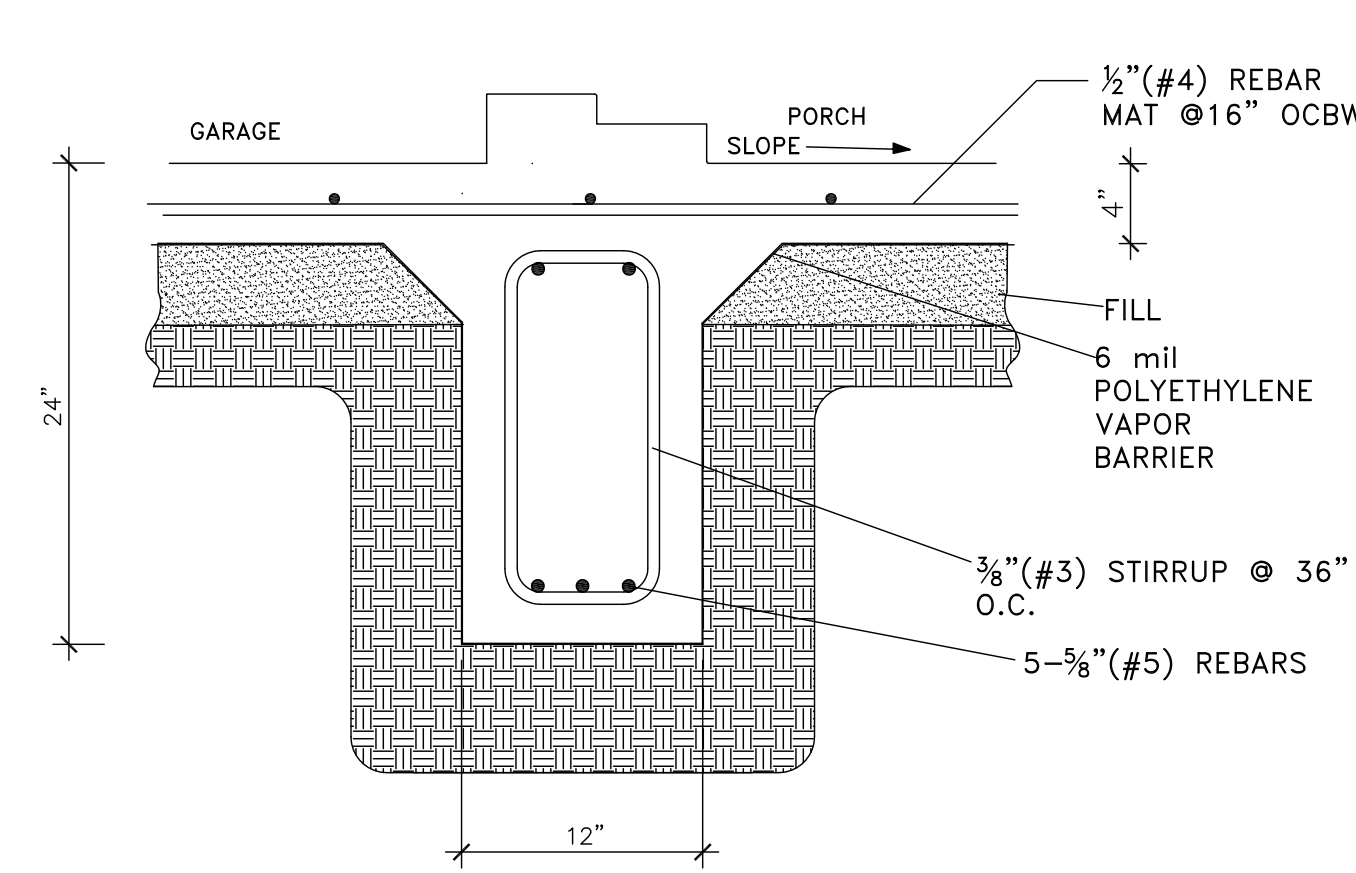


I - I INTERIOR BEAM AT GARAGE/PORCH

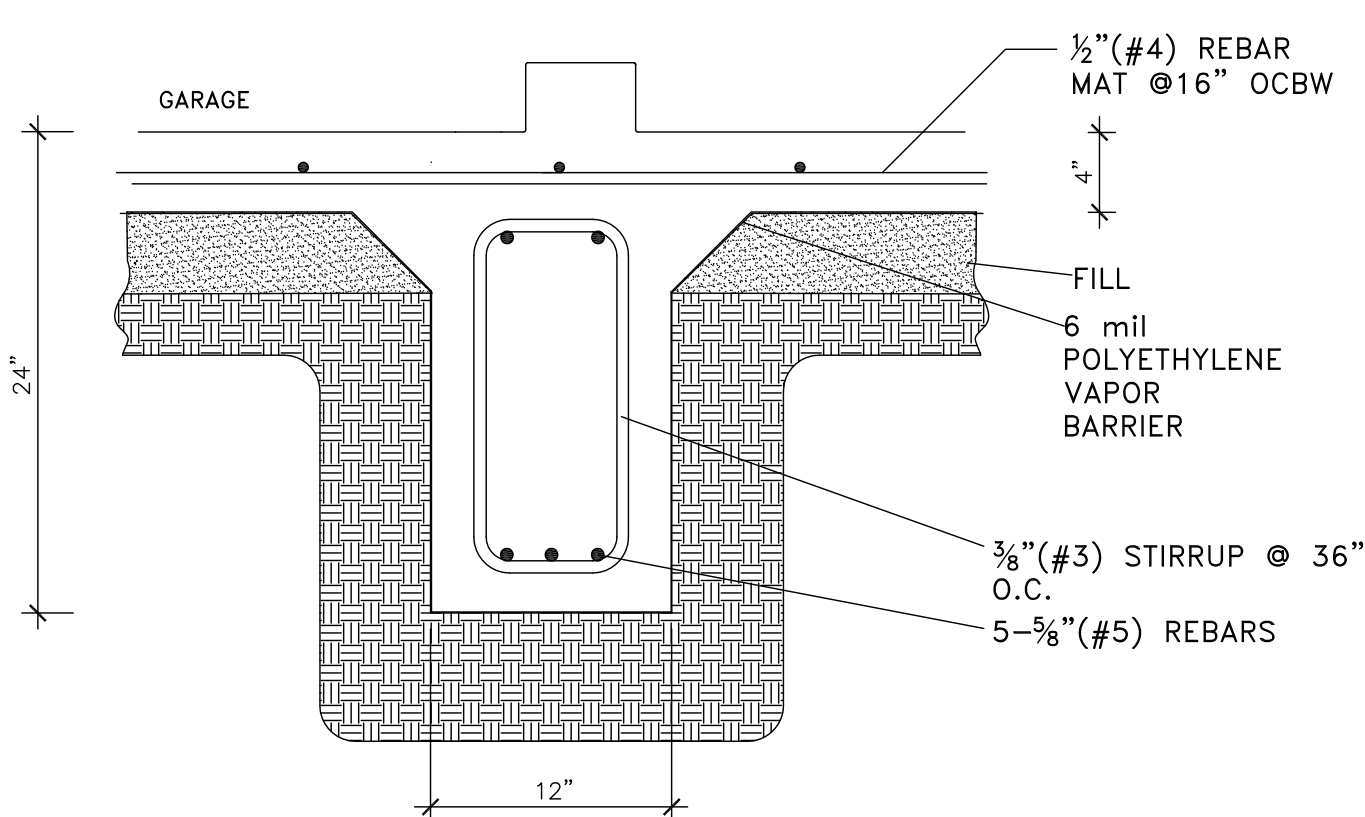


J - J INTERIOR BEAM AT PORCH

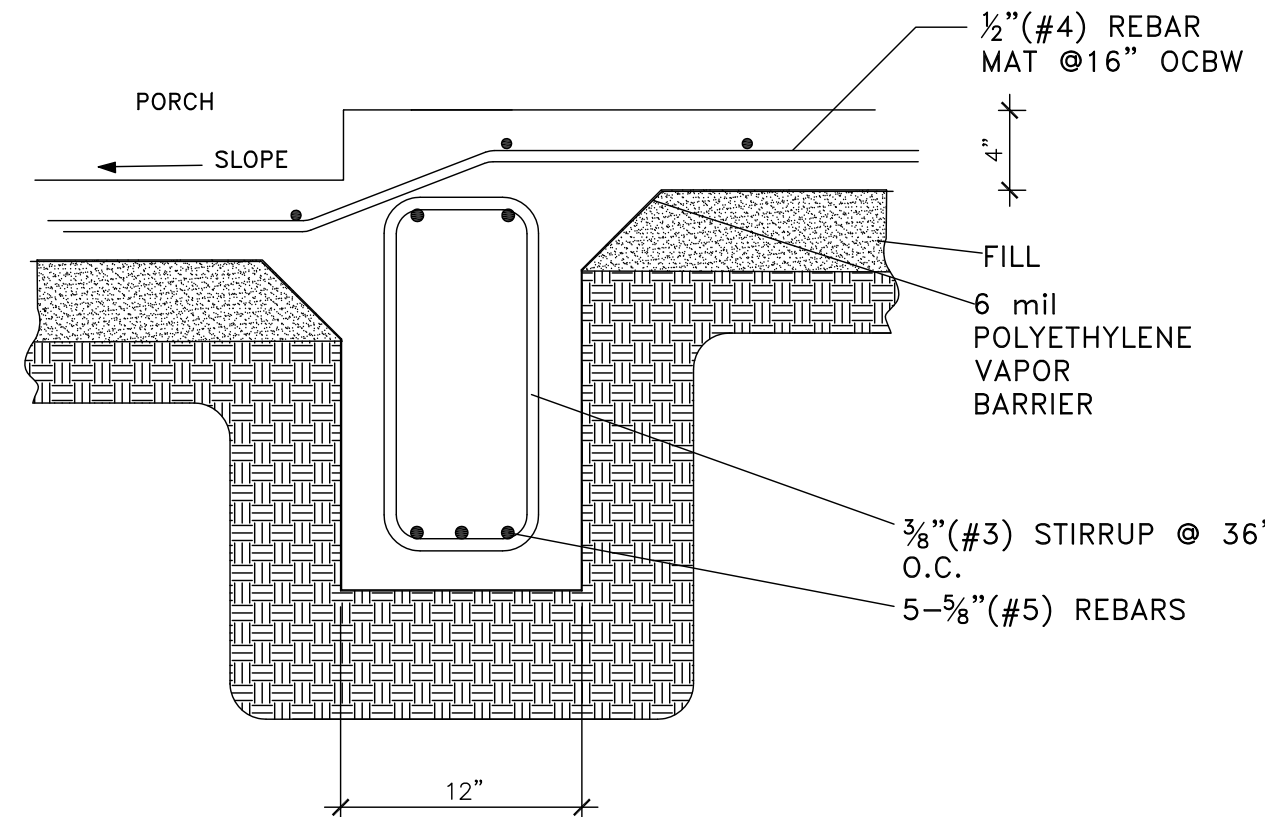


K - K PORCH DROP AT BRICK BEAM

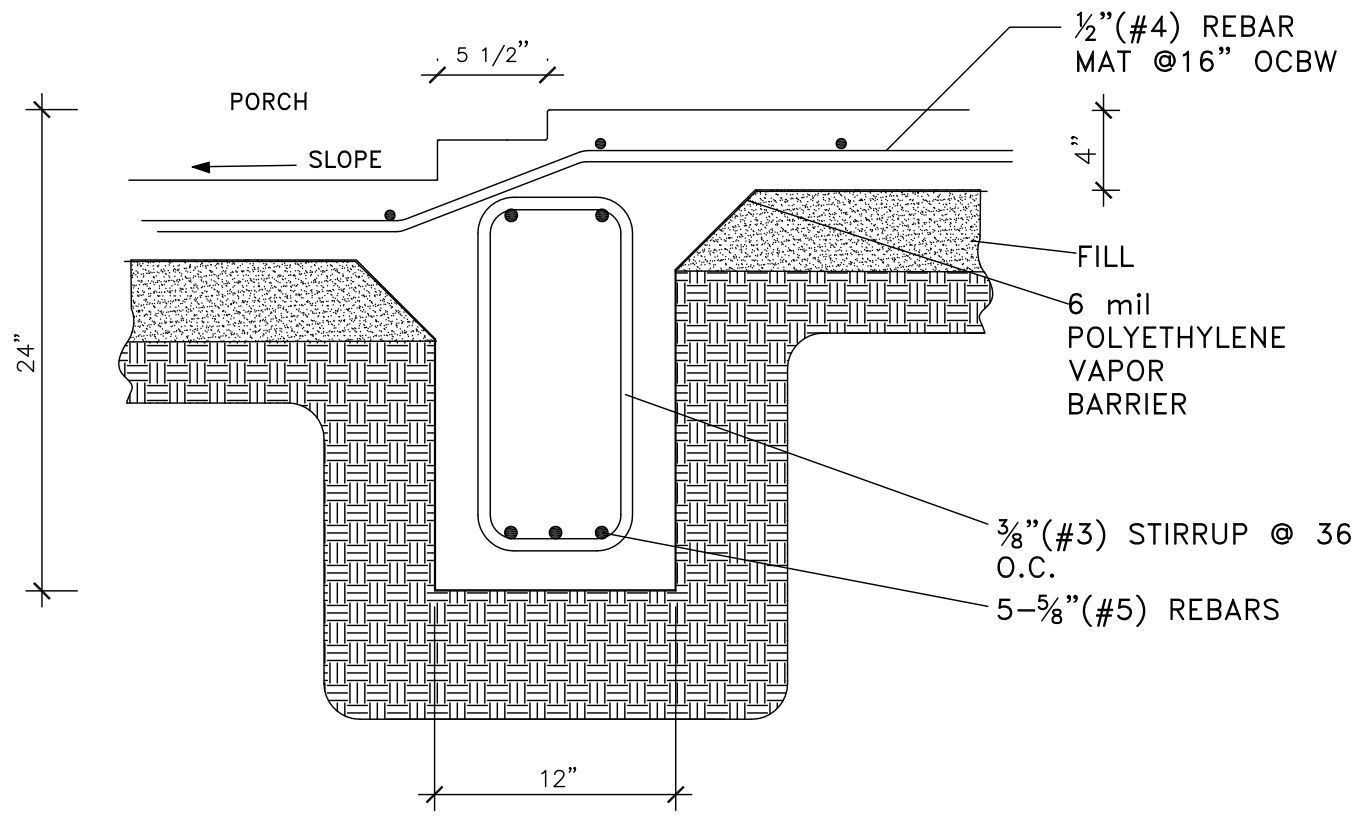


L - L PERIMETER PORCH BEAM

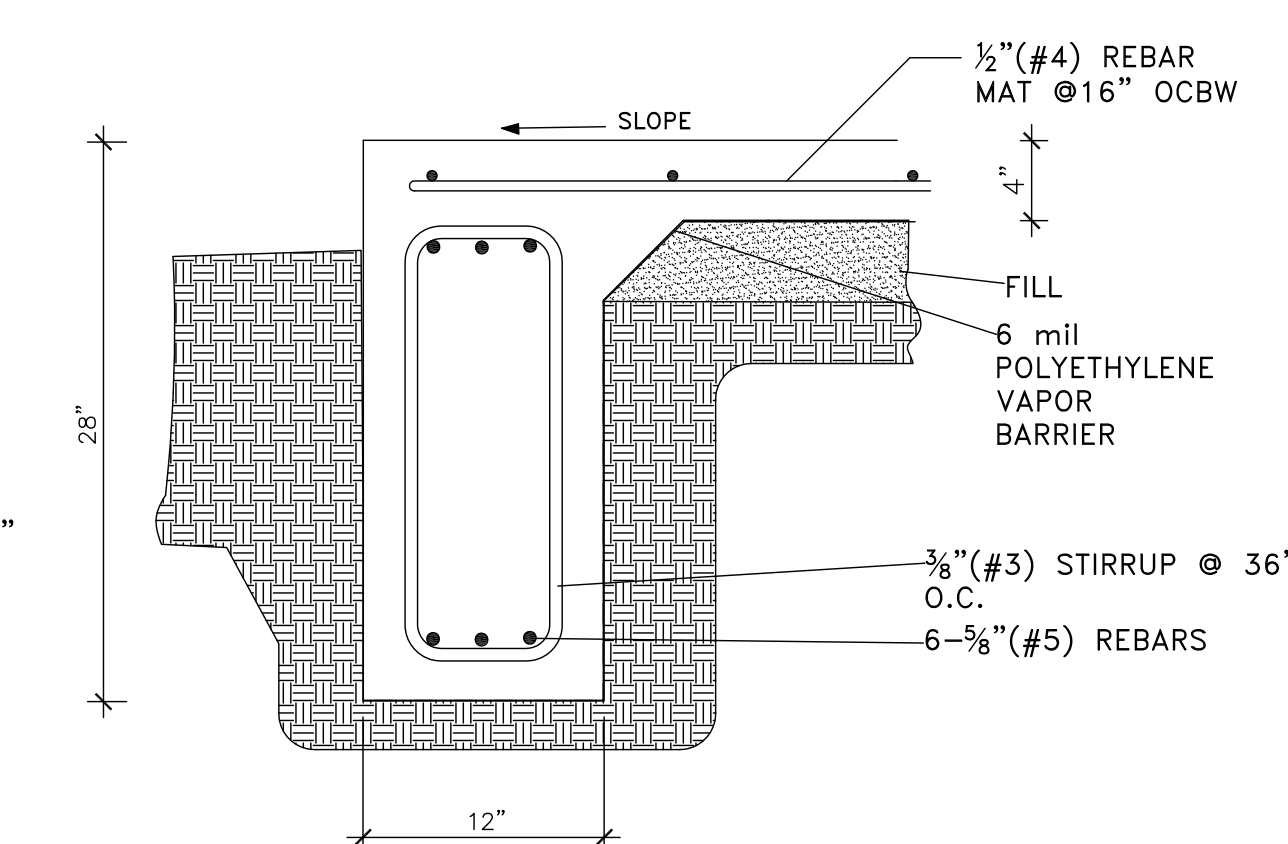

M - M Brick Fireplace @ Exterior Wall

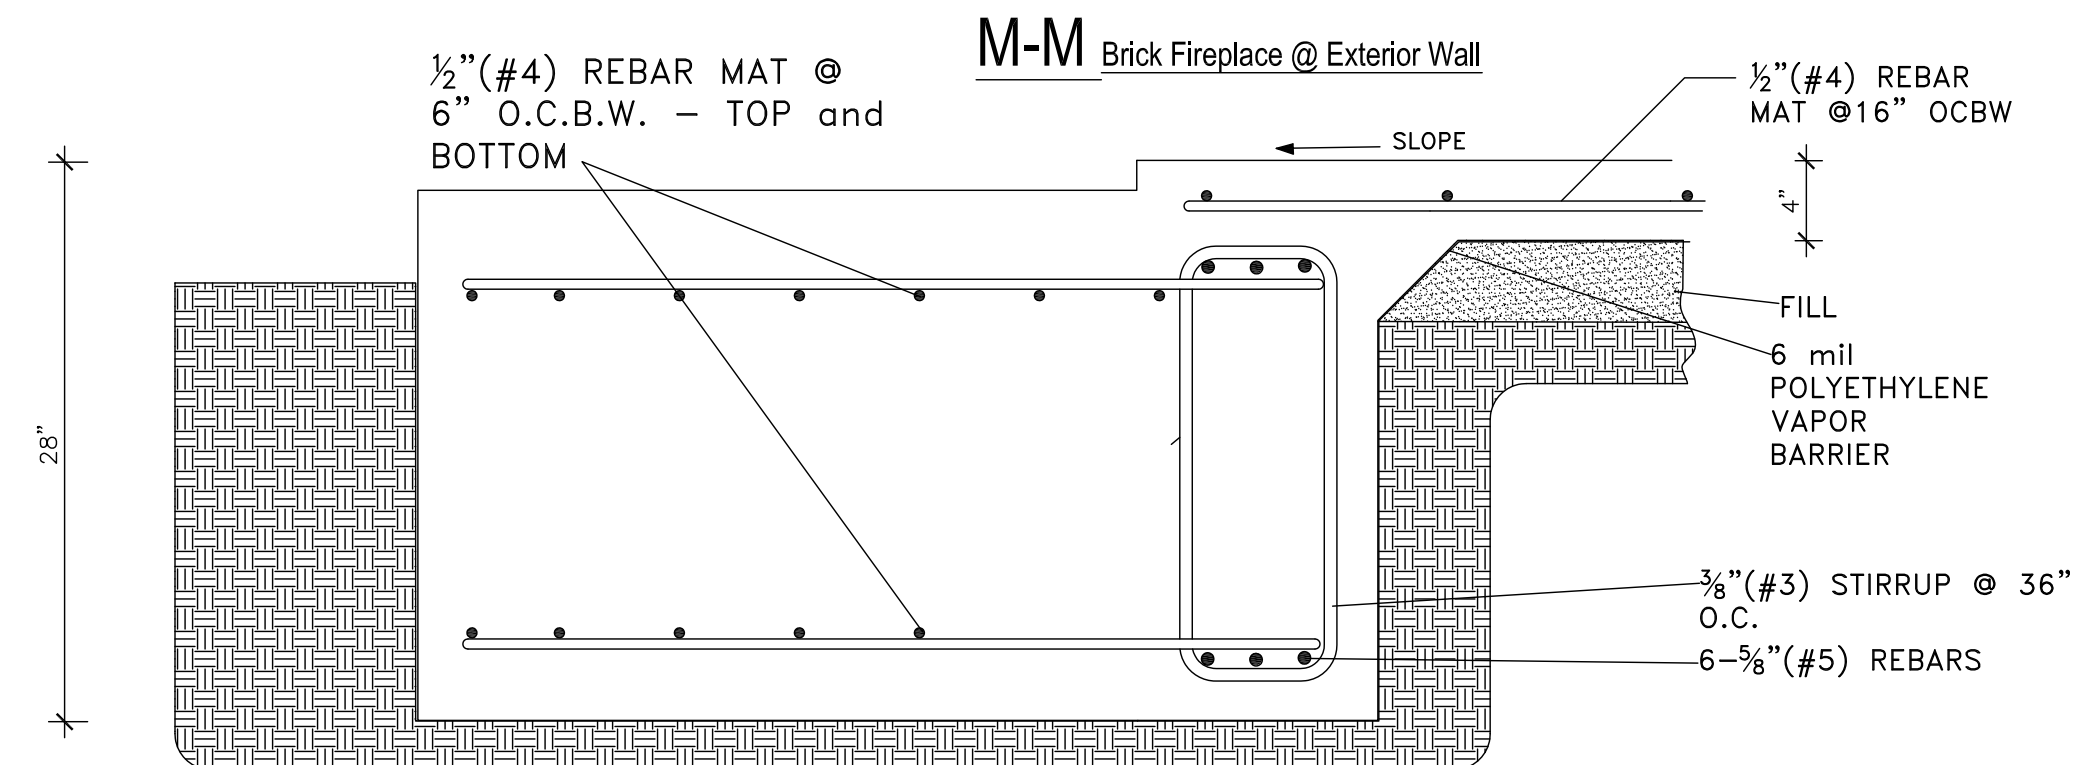

N - N Wheelstop

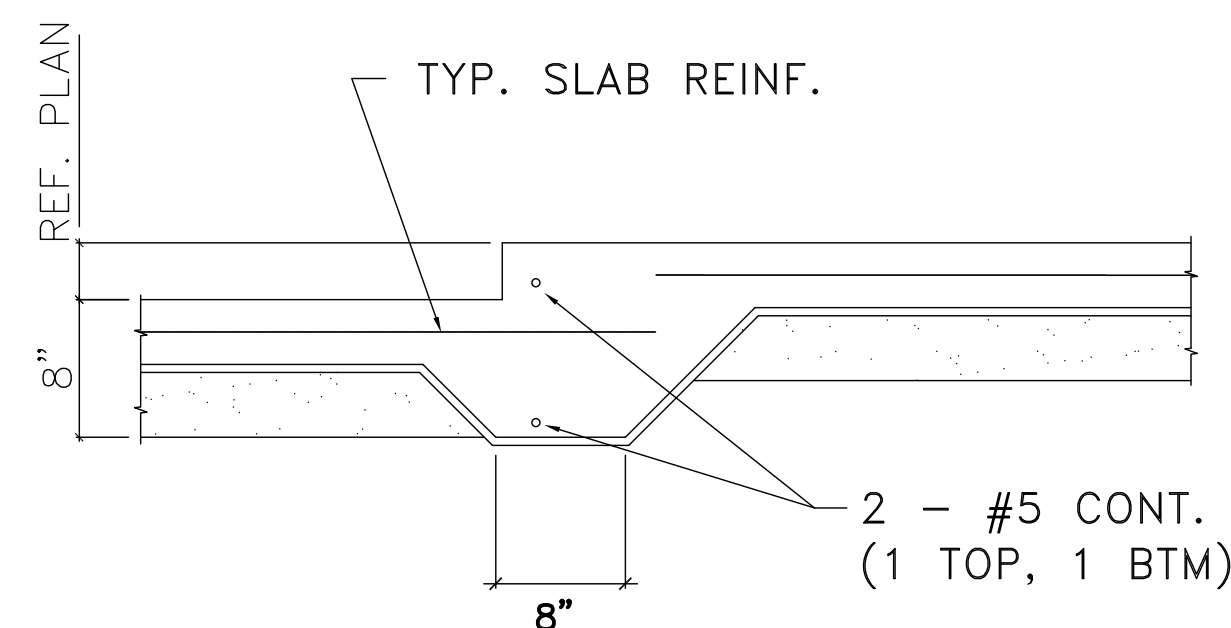

THE ABOVE FOUNDATION DETAILS ARE TYPICAL DETAILS, INCLUDING THE BEAM DEPTH AND WIDTH. THE ABOVE DETAILS SHOULD BE APPROVED BY A LOCAL ENGINEER BEFORE ANY CONSTRUCTION IS STARTED.

MOONLIGHT HOUSE PLANS IS A DRAFTING FIRM, NOT AN ENGINEERING OR ARCHITECTURAL FIRM. THESE PRINTS ARE NOT TO BE USED FOR ANY STRUCTURAL OR DESIGN MISTAKES. DIMENSIONS, DETAILS & SPECIFICATIONS. DESIGNER WILL NOT BE LIABLE FOR HUMAN ERROR AFTER CONSTRUCTION IS STARTED. THESE DRAWINGS, SPECIFICATIONS AND IDEAS ARE THE PROPERTY OF MOONLIGHT HOUSE PLANS, AND SHALL NOT BE REPRODUCED, OR ALTERED IN ANY WAY.

Moonlight House Plans
979-482-1967

REVISION HISTORY	DATE
NUMBER	

DWG. SCALE: 1/4" = 1'-0"

DETAILS
LAKE JACKSON MANAGEMENT
216 SHANNON STREET - ANGLETON, TEXAS
JOB #: 20213935

04-13-21

D1