


18722 White Barnwood

Y

[Handwritten Signature]

[TV] : Cable
 [P] : Phone

X : Flood light

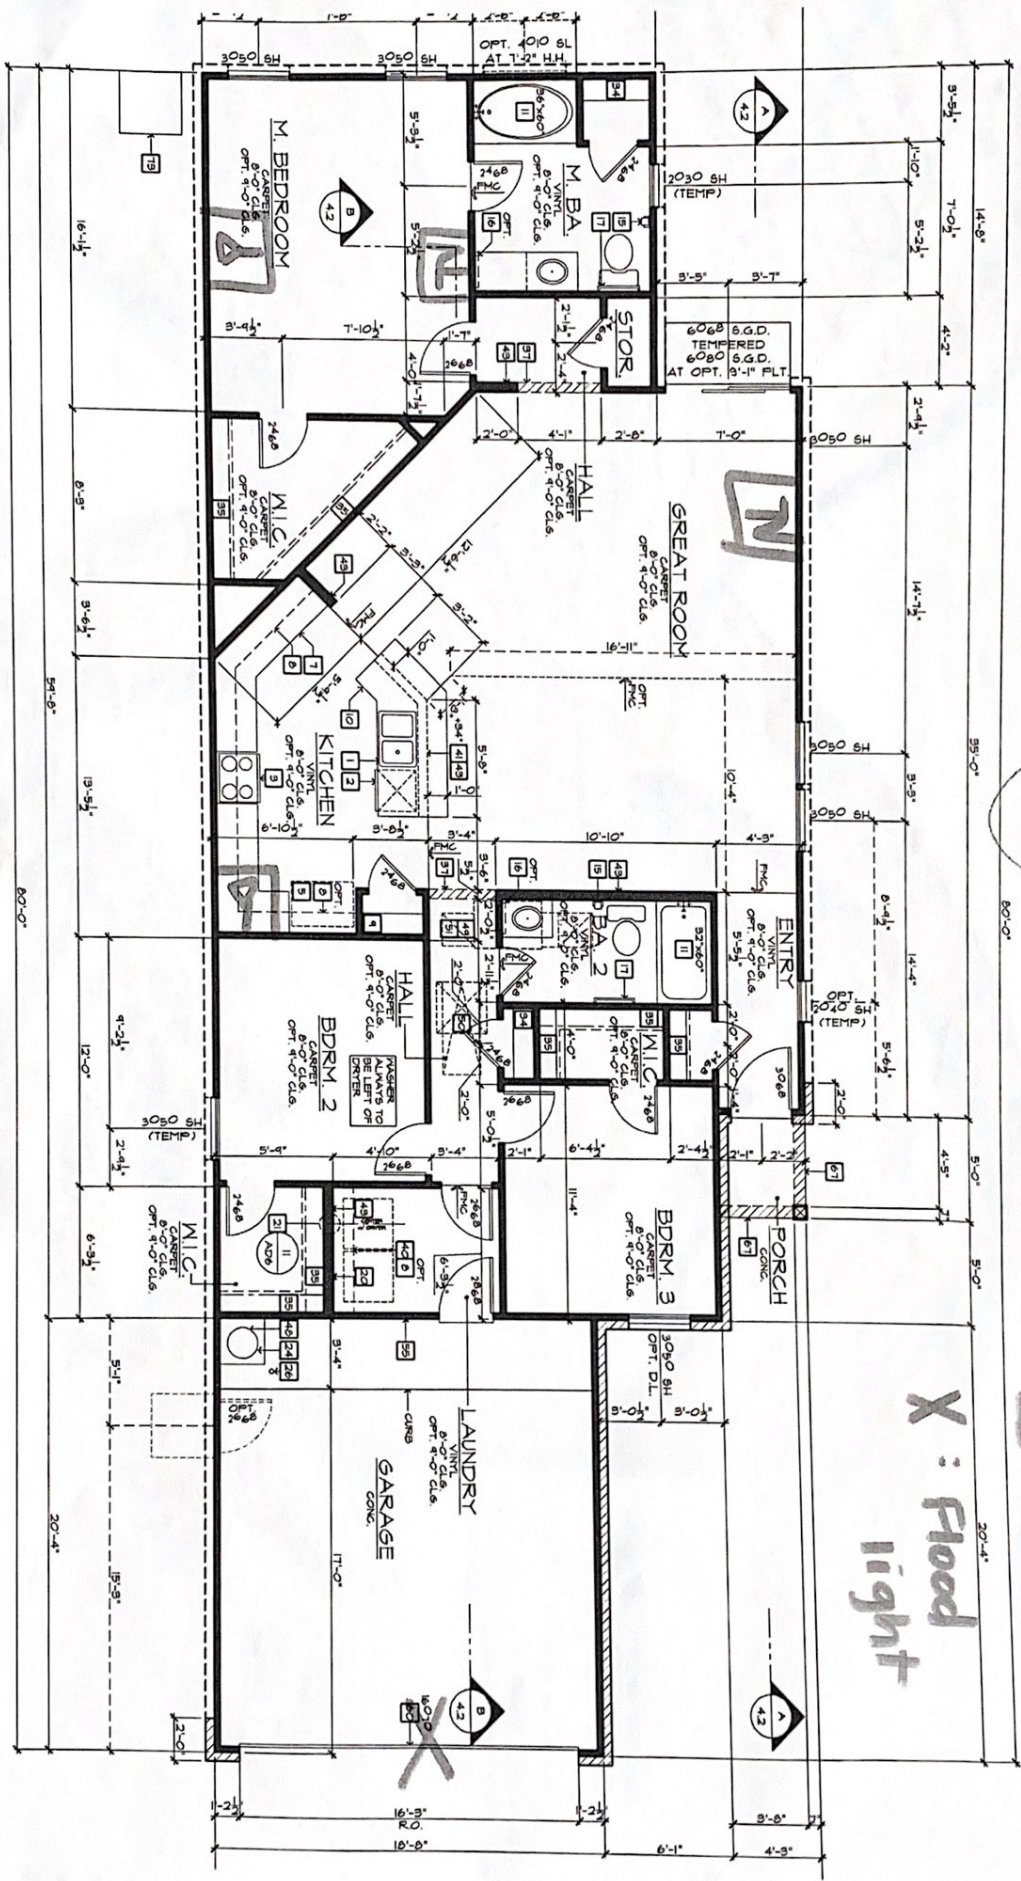

FLOOR PLAN
 SCALE 1/4"=1'-0" (23'x94") - 1/8"=1'-0" (11'x17")

BASIC PLAN