


legend:

- ⊕ duplex receptacle 110v
- ⊕ WP 220v receptacle
- ⊕ FLR. waterproof duplex receptacle
- ⊕ recessed floor receptacle
- ⊕ t.v. antenna outlet
- ⊕ CLG. ceiling receptacle
- ⊕ phone outlet

- ⊕ \$3 single pole switch
- ⊕ three way switch
- ⊕ OGD garbage disposal
- ⊕ SD smoke detector
- ⊕ thermostat
- ⊕ ceiling mounted light fixture
- ⊕ wall mounted fixture
- ⊕ PC porcelain fixture w/pull cord switch

- ⊕ exhaust fan
- ⊕ exhaust fan at range hood
- ⊕ ceiling fan
- ⊕ pre-wire and block for ceiling fan

CH CH
P.B. PU

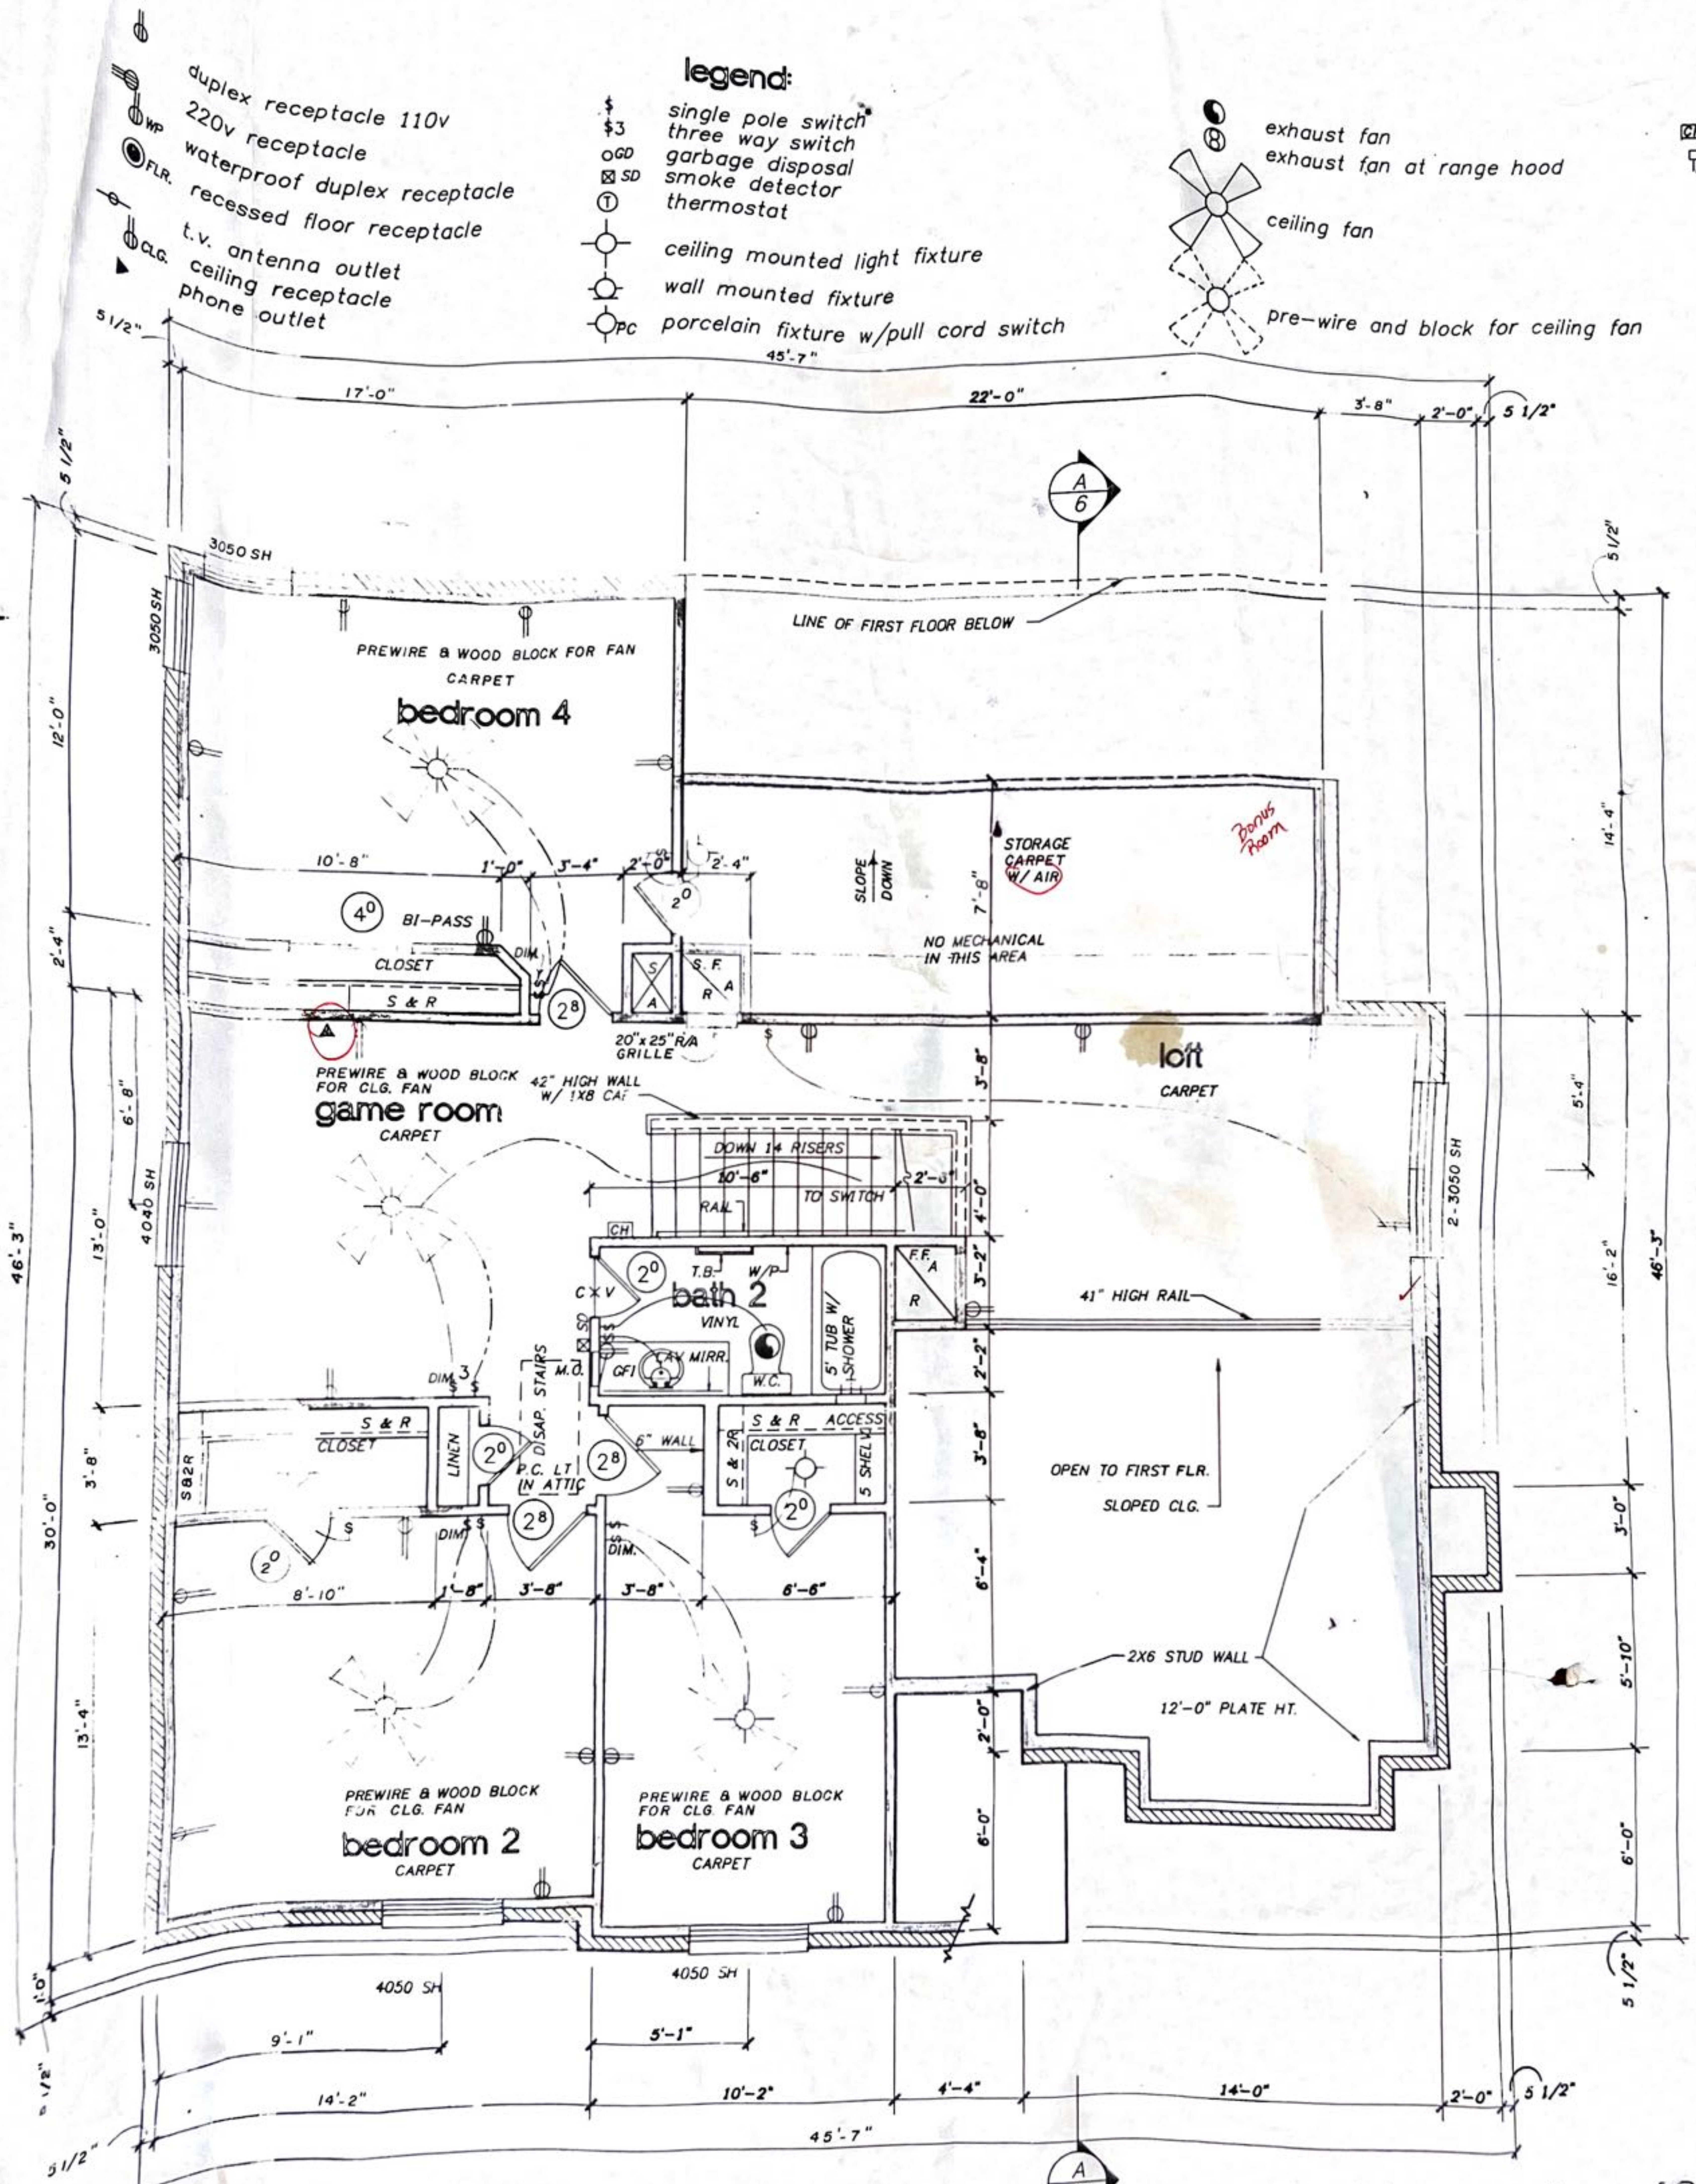

second floor plan-4896

SCALE: 1/4"=1'-0"