


1 FLOOR PLAN
SCALE: 1/4" = 1'

ABBREVIATIONS							
SH	SINGLE HUNG	EB	EYE BROW	PAN	PANTRY	W.I.C.	WALK-IN CLOSET
DL	DIVIDED LIGHTS	PKT	POCKET	RM	ROOM	DBL	DOUBLE
HD	HEADER	DR	DOOR	CLST	CLOSET	SNK	SINK
HT	HEIGHT	FG	FIXED GLASS	SHLV	SHELVES	DW	DISH WASHER
OH	OVERHEAD	OBGG	OBSCURED GLASS	CW	COLD WATER TAP	MSTR	MASTER
SECT	SECTIONAL	/BTH	HALF BATH	CLG	CEILING		

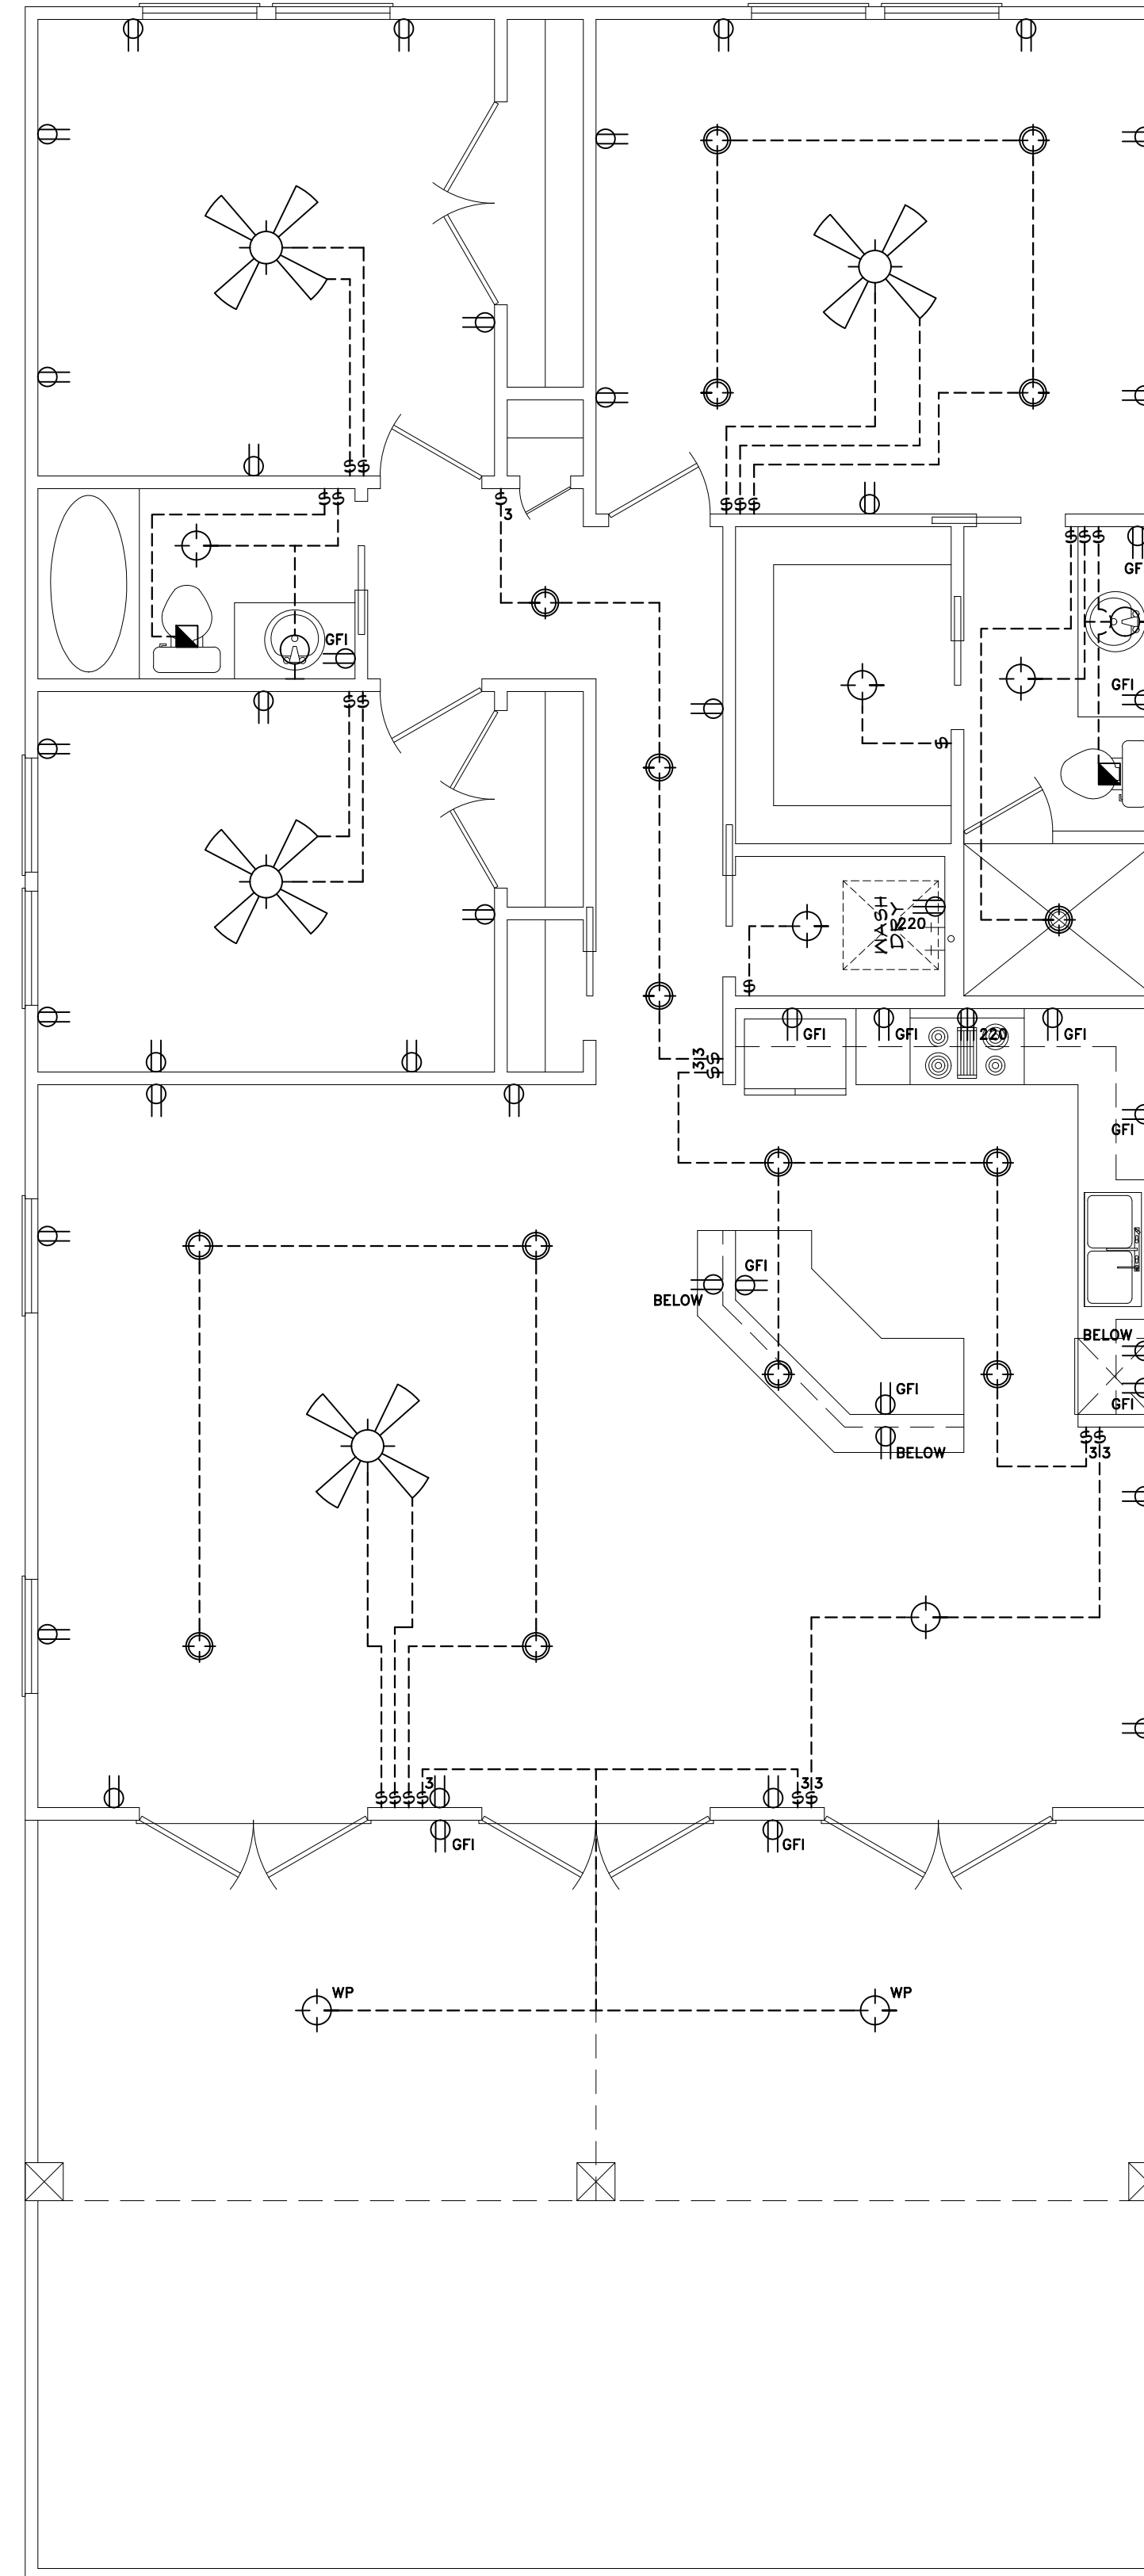

2 ELECTRICAL
SCALE: 1/4" = 1'

ELECTRICAL LEGEND	
SYMBOL	DESCRIPTION
	RECESSED LIGHT FIXTURE
	CEILING MOUNTED LIGHT FIXTURE
	WALL MOUNT LIGHT FIXTURE
	VENT
	SMOKE DETECTOR
	220 V. DUPLEX RECEPT OUTLET
	110 V. DUPLEX RECEPT OUTLET
	110 V. FLOOR OUTLET
	GROUND FAULT INTERRUPTER DUPLEX RECEPTACLE OUTLET
	WATER PROOF OUTLET
	SINGLE POLE SWITCH
	2 WAY SWITCH
	DIMMER SWITCH
	2 WAY SWITCH WITH DIMMER
	PUSH BUTTON GARAGE DOOR
	DOOR BELL
	CHIME
	TELEVISION JACK
	PHONE JACK
	GAS LINE CONNECTION
	GARAGE DOOR OPENER
	JUNCTION BOX
	FLOOD LIGHTS

ELECTRICAL NOTES:
 -SMOKE DETECTORS IN ALL BED ROOMS, REQUIRE 110V TO HOUSE WIRING, BATTERY BACKUP & INTERCONNECT
 -VENT ALL EXHAUST FANS TO OUTSIDE
 -PROVIDE G.F.I. PROTECTION ON BATH PLUGS
 -PROVIDE LIGHT FIXTURE & SMOKE DETECTOR AT WATER HEATER & A/C UNIT
 -PROVIDE ELECTRIC DISCONNECT AT A/C UNIT