





FRONT ELEVATION
SCALE: 1/4" = 1'

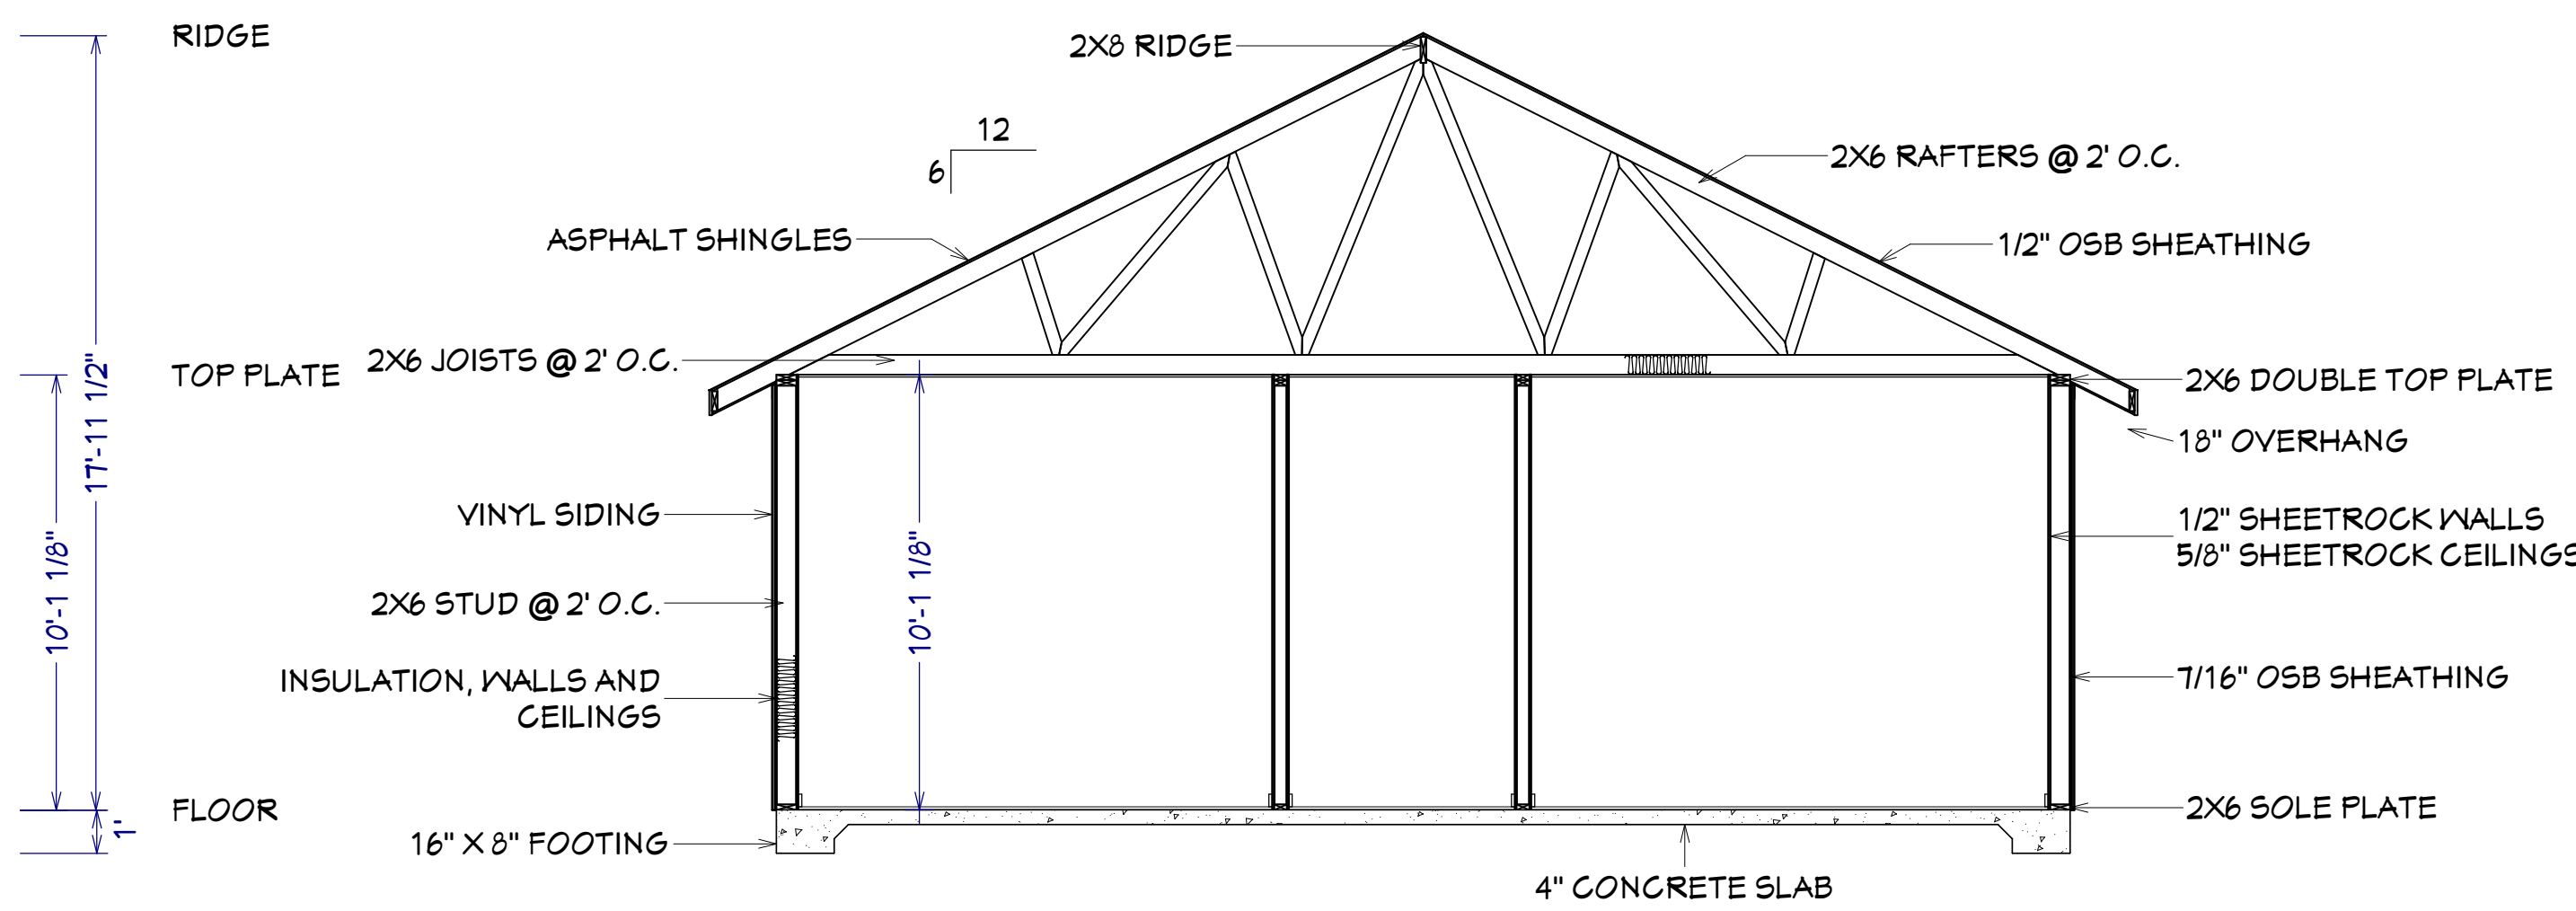


CROSS SECTION
SCALE: 1/4" = 1'




REAR ELEVATION
SCALE: 1/4" = 1'

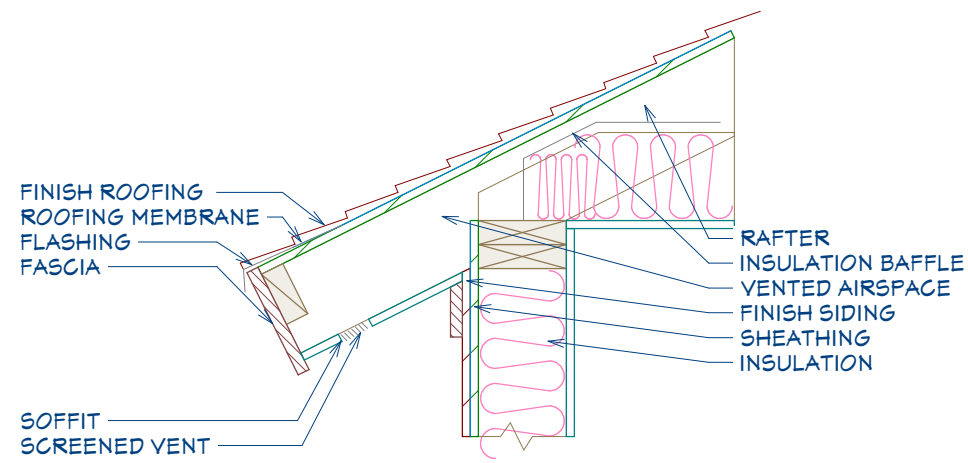

Boxed in Eave
SCALE: 1" = 1'

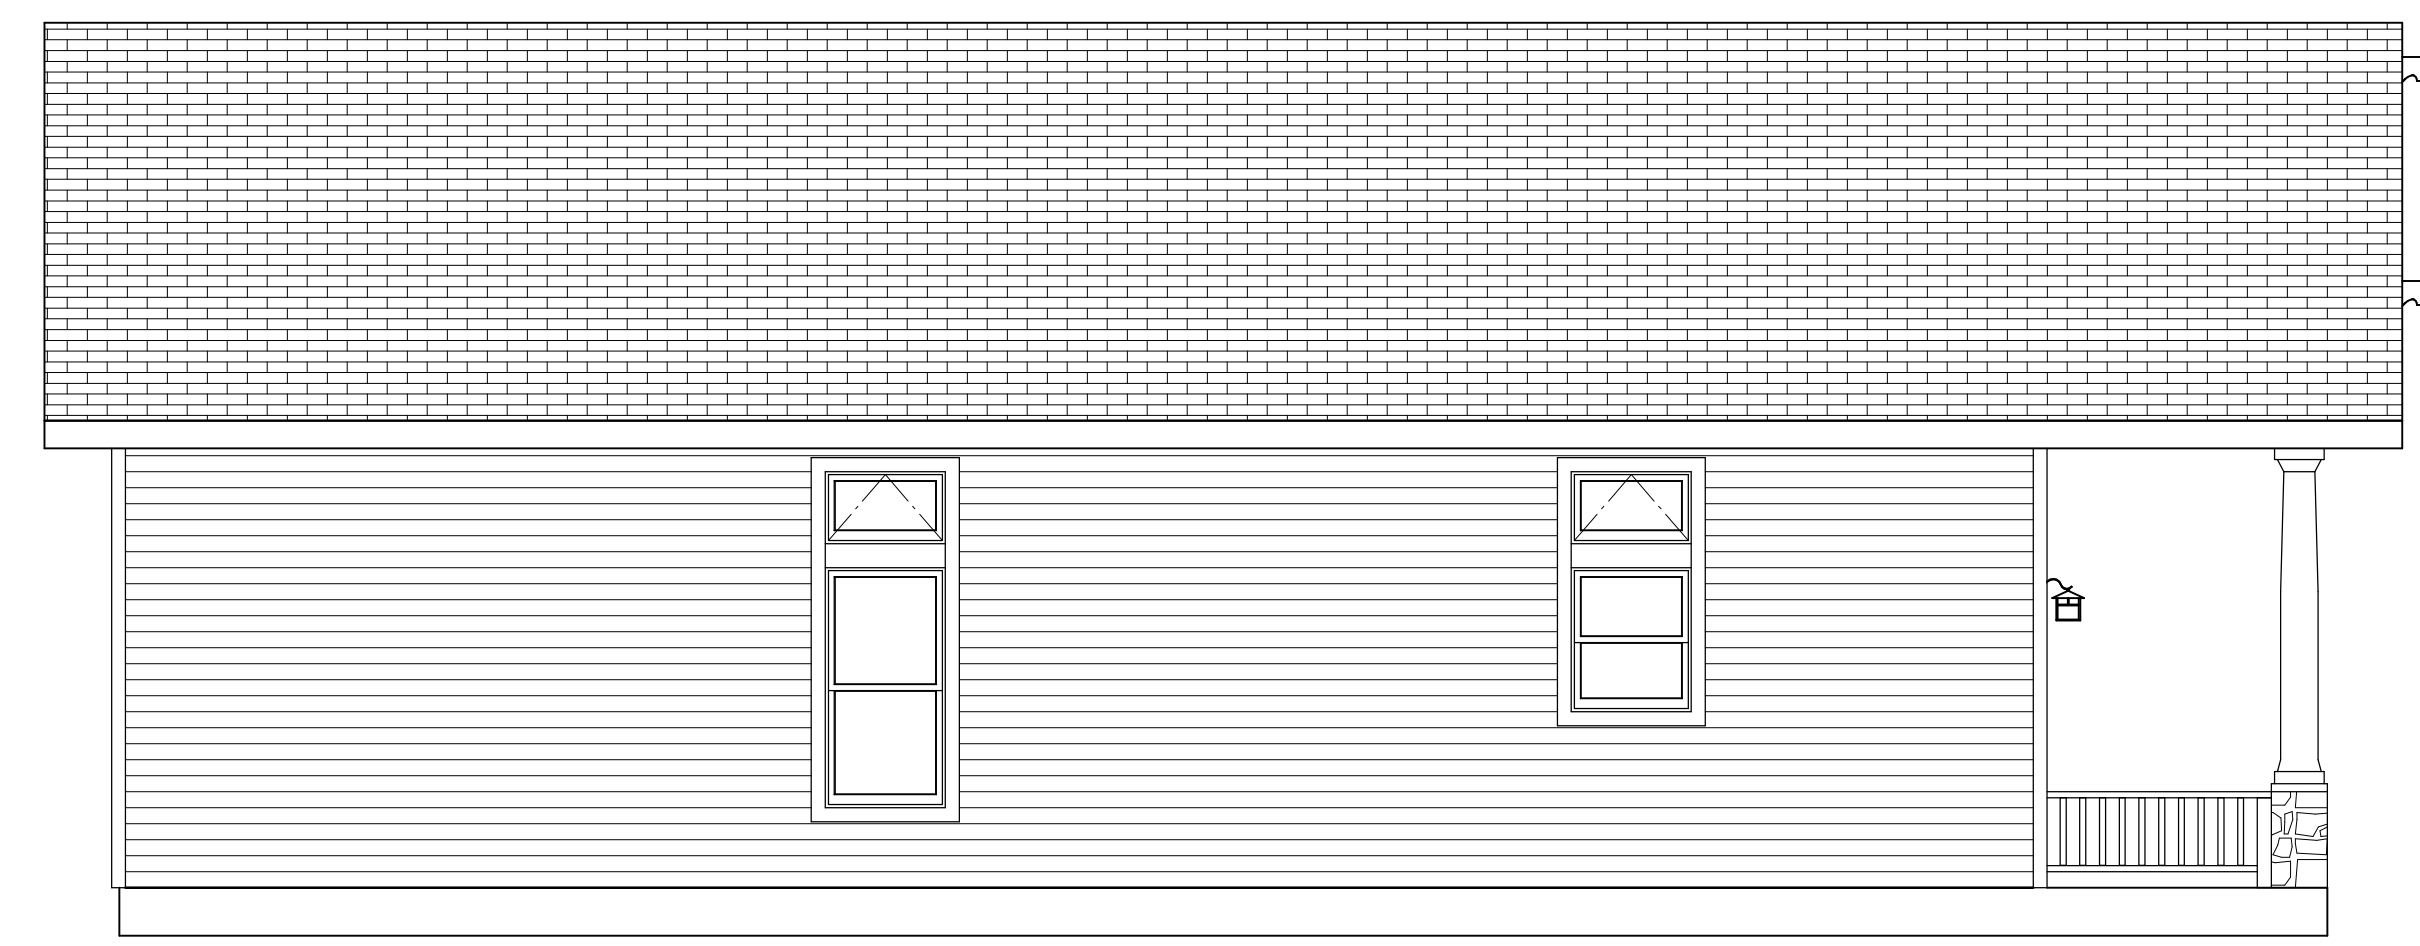

LEFT ELEVATION
SCALE: 1/4" = 1'

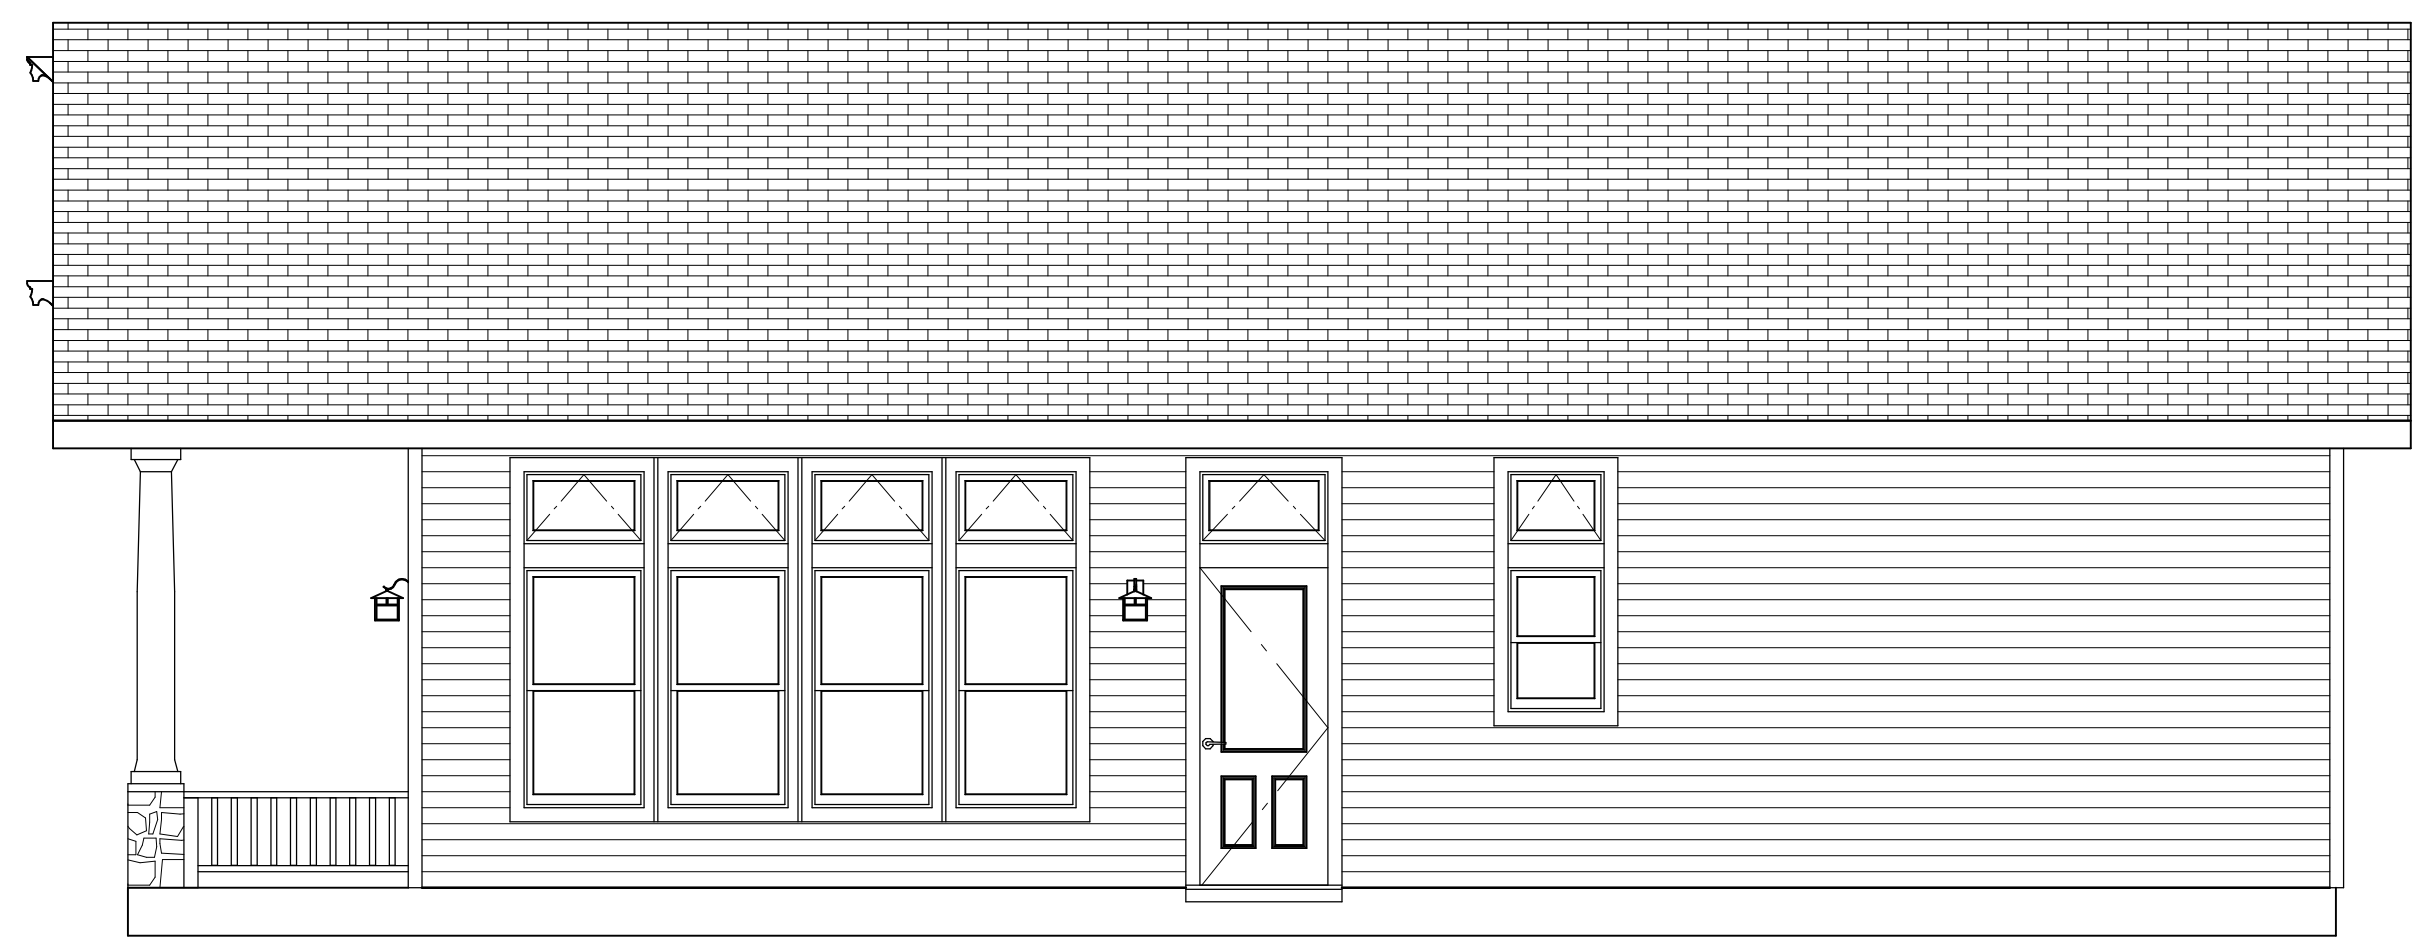

RIGHT ELEVATION
SCALE: 1/4" = 1'

**30x40 House
#30X40H3C**

SQUARE FEET: 1,200
 WIDTH: 30'
 DEPTH: 46'
 EXTERIOR WALL STRUCTURE: 2X6 STUDS

BUILDING CONTRACTOR/HOME OWNER TO REVIEW AND VERIFY ALL DIMENSIONS, AND SPECS BEFORE CONSTRUCTION BEGINS. BUILDING TO BE BUILT AS PER LOCAL CODE REQUIREMENTS.

To the best of my knowledge these plans are drawn to comply with owner's and/ or builder's specifications and any changes made on them after prints are made will be done at the owner's and / or builder's expense and responsibility. The contractor shall verify all dimensions and enclosed drawing. E.F.P. is not liable for errors. While every effort has been made in the preparation of this plan to avoid mistakes, the maker cannot guarantee against human error. The contractor of the job must check all dimensions and other details prior to construction and be solely responsible thereafter. All calculations and member sizing should be verified for your building by a certified building official.




These plans were not prepared by nor checked by a licensed architect and/or engineer. E.F.P. does not represent or imply itself to be a licensed architect and/or licensed engineer. Enjoy these plans but use them at your own risk. Resale of these plans, in whole or part, is strictly prohibited.


Excellent Floor Plans
<https://sites.google.com/excellentfloorplans>
<https://www.ebay.com/str/excellentfloorplans>
<https://excellentfloorplans.etsy.com>

These plans were not prepared by nor checked by a licensed architect and/or engineer.
E. F. P. does not represent or imply itself to be a licensed architect and/or licensed engineer.
Enjoy these plans but use them at your own risk.
Resale of these plans, in whole or part, is strictly prohibited.


Excellent Floor Plans
<https://sites.google.com/excellentfloorplans>
<https://www.ebay.com/str/excellentfloorplans>
<https://excellentfloorplans.etsy.com>

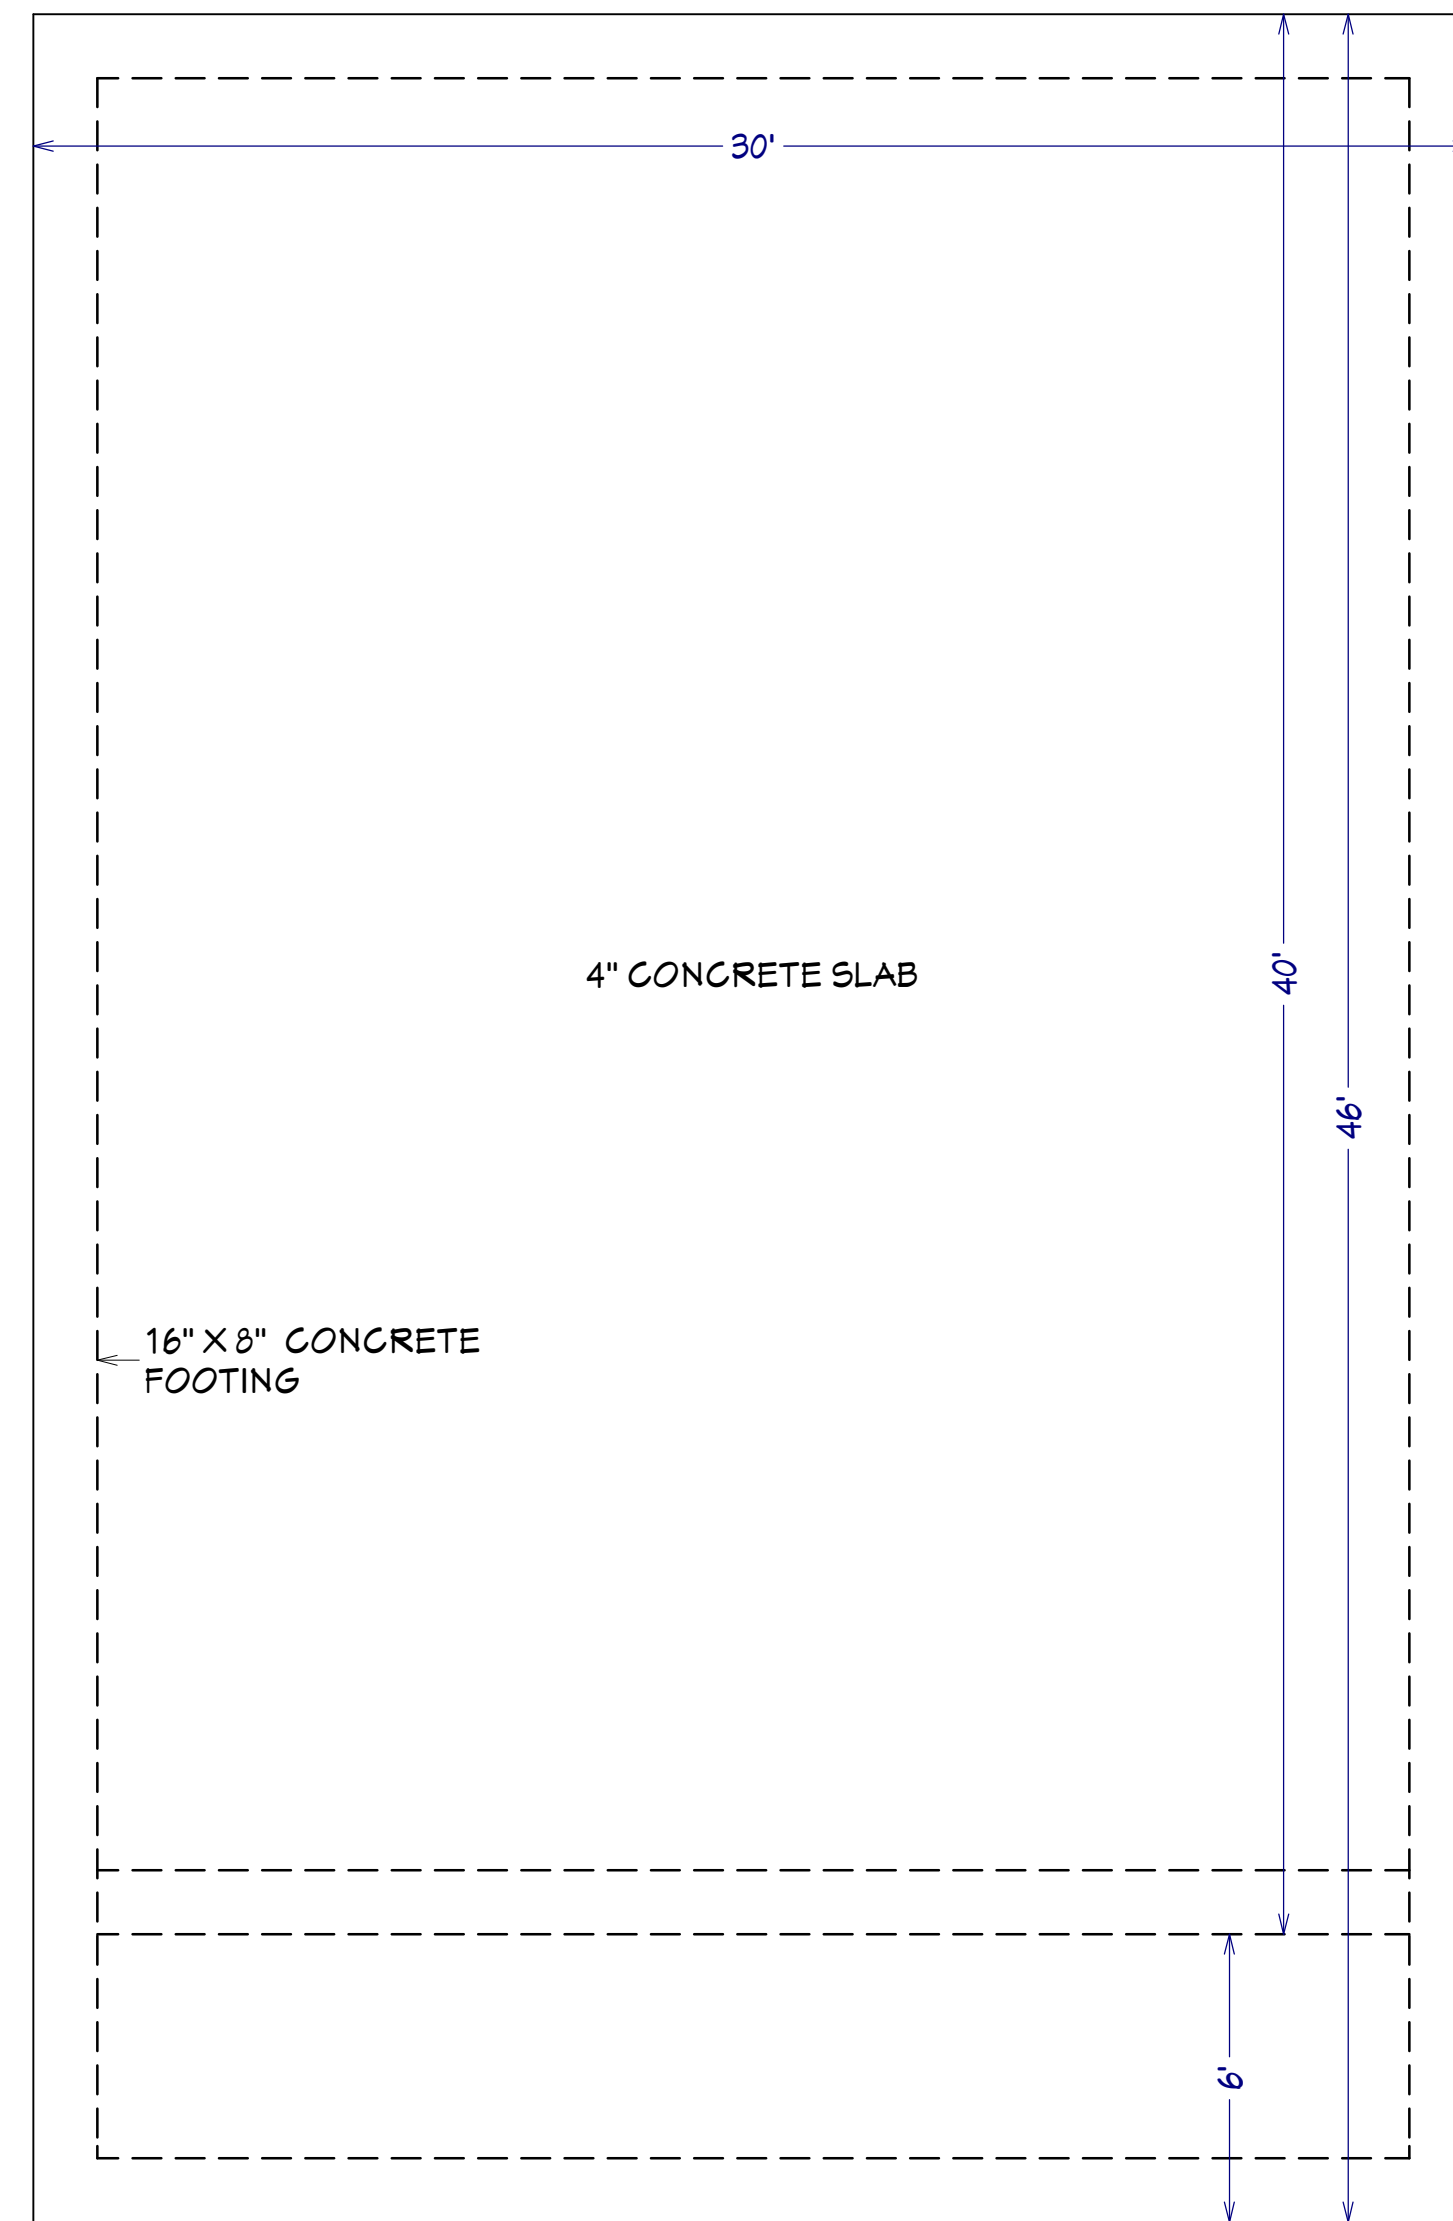


FOUNDATION PLAN
SCALE: 1/4" = 1'

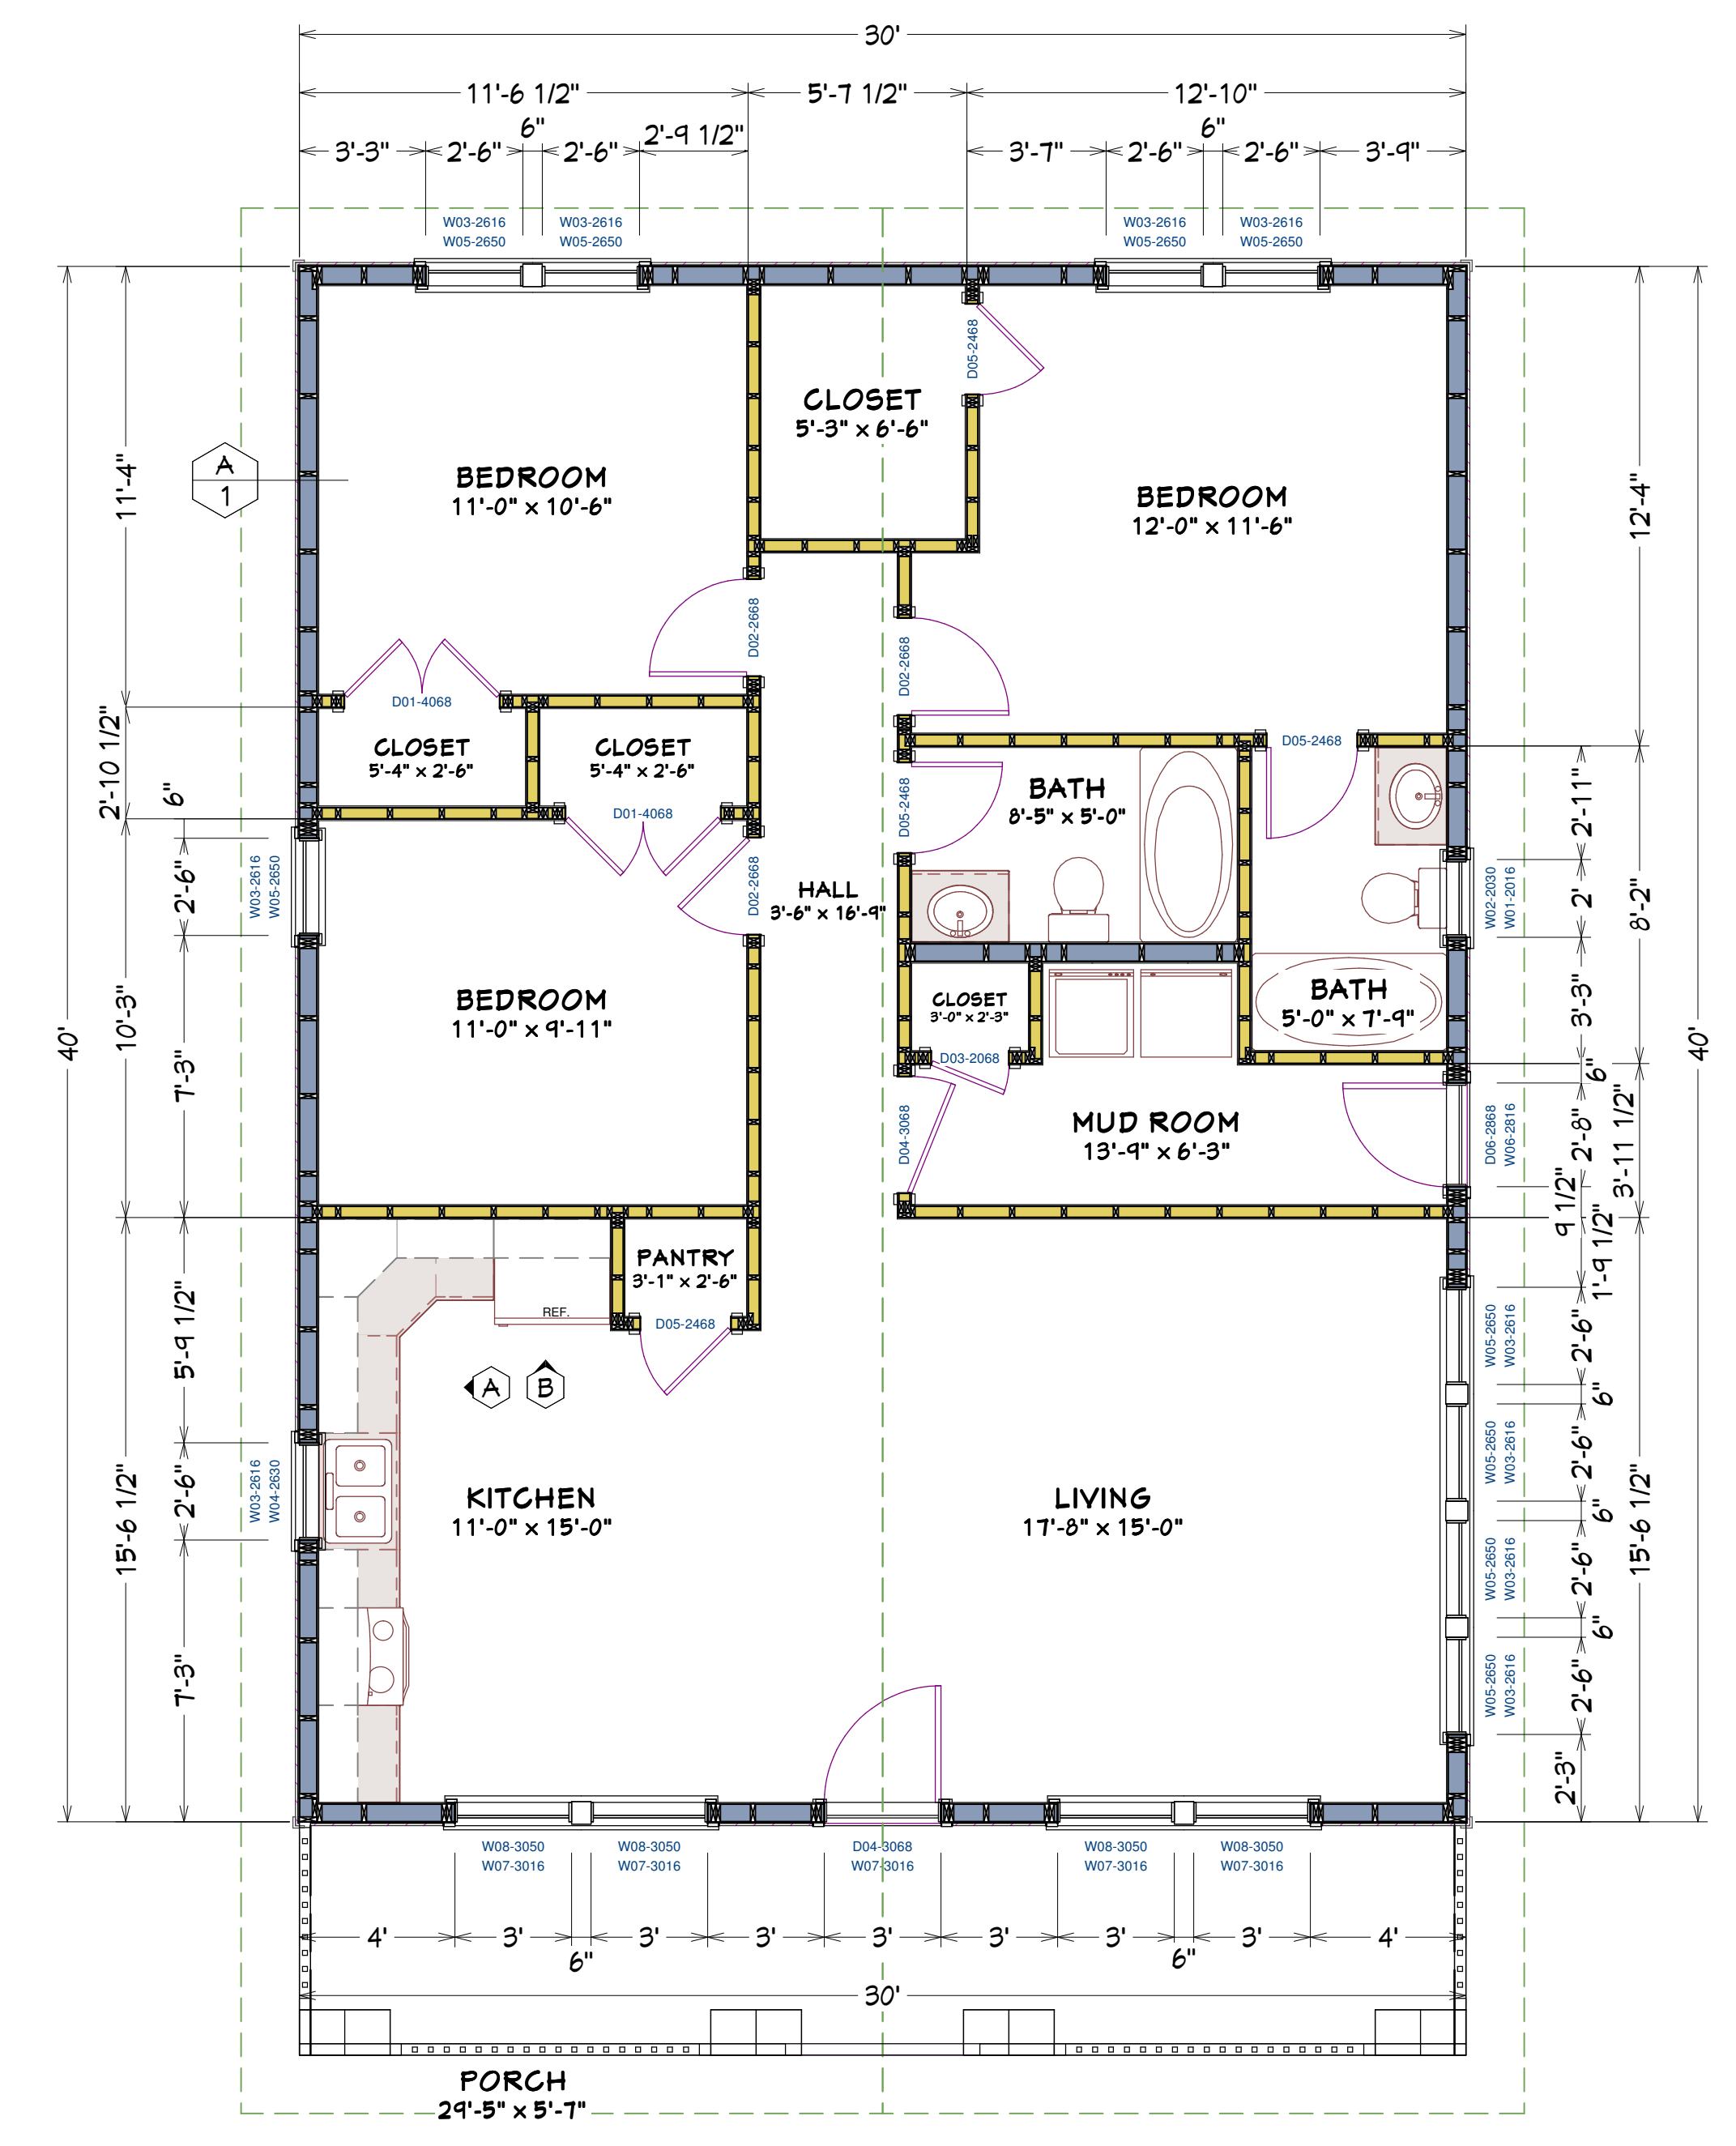

MAIN FLOOR PLAN
SCALE: 1/4" = 1'

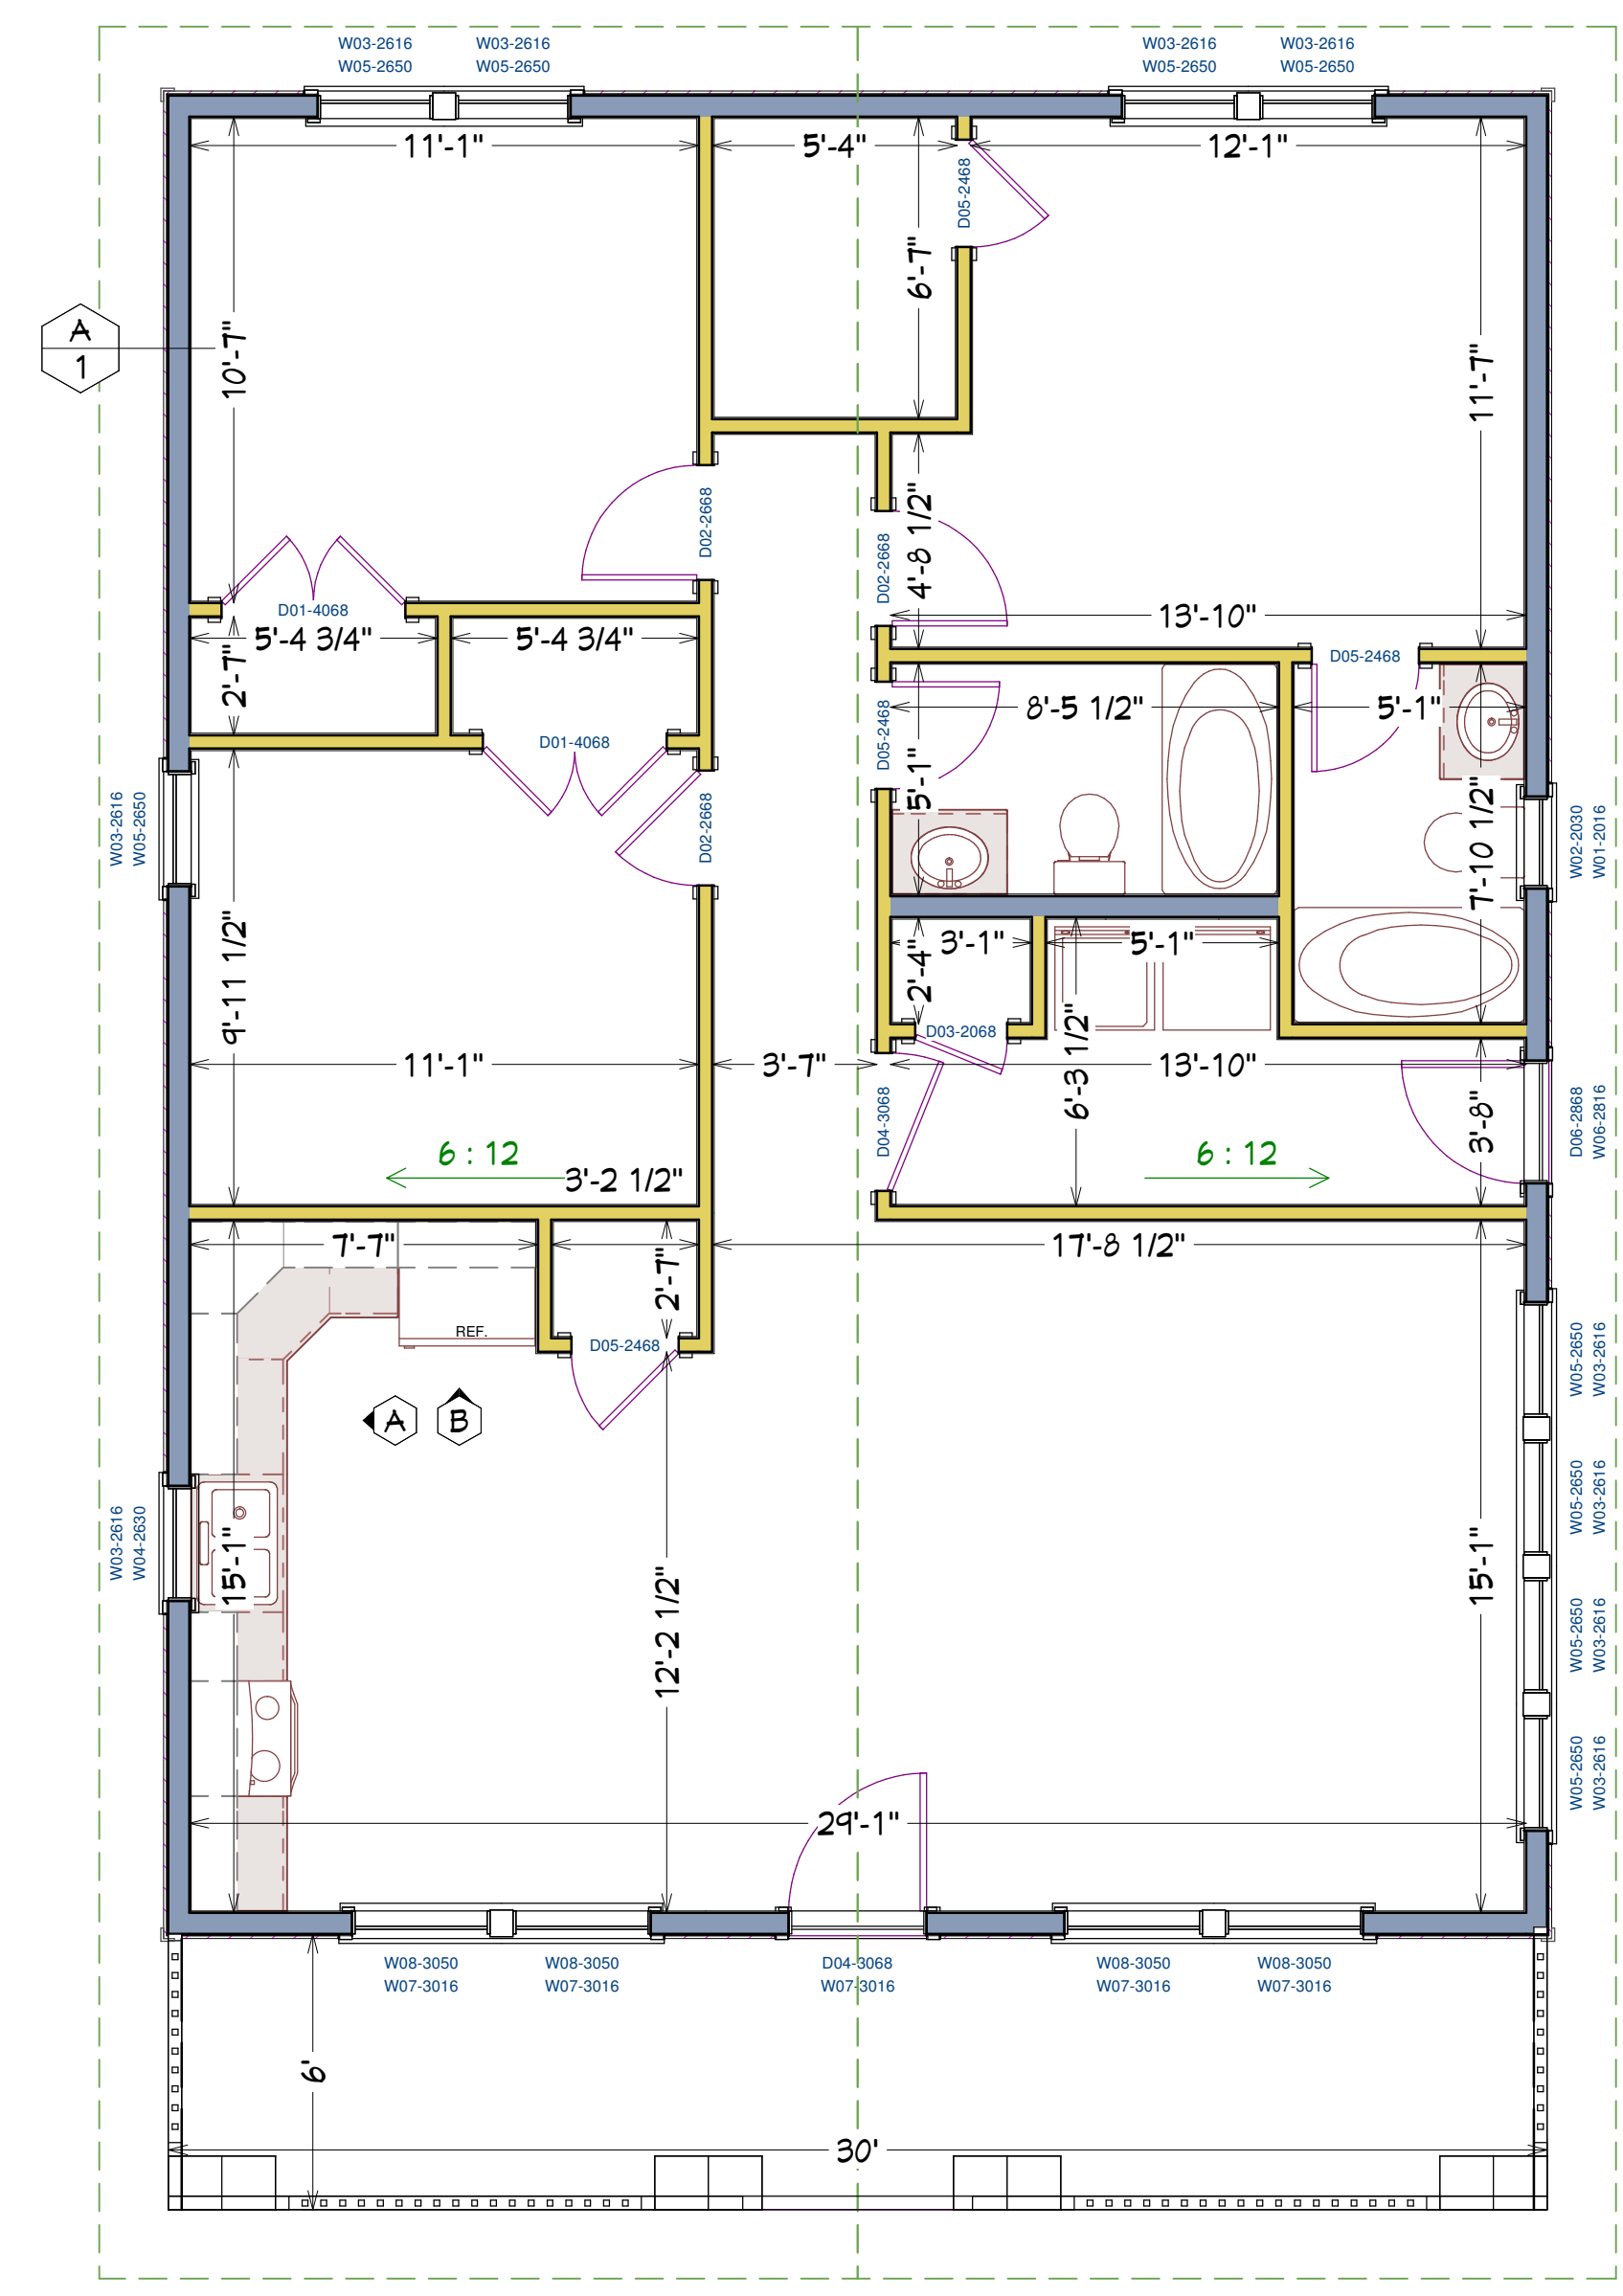


MAIN FLOOR PLAN
SCALE: 1/4" = 1'

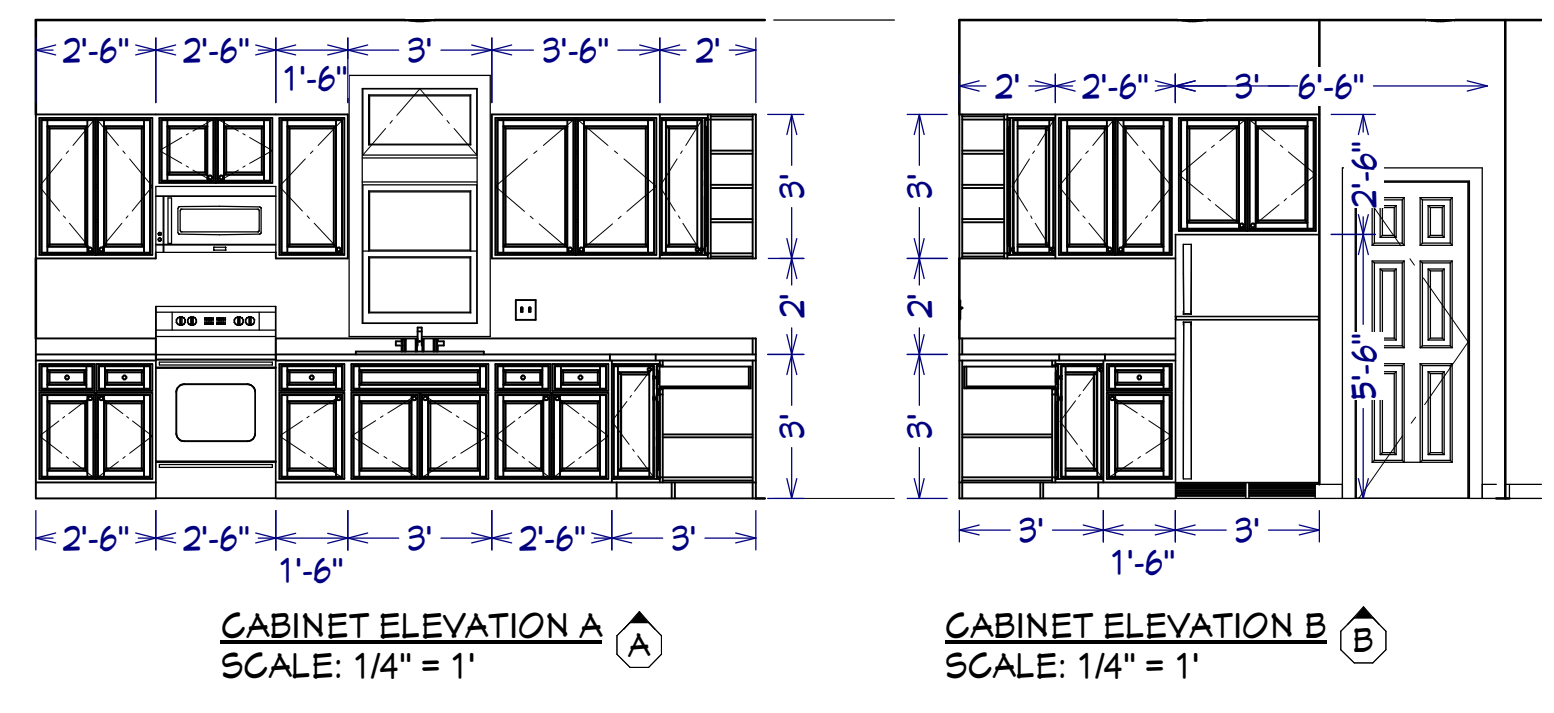


30x40 House
#30X40H3C

DOOR SCHEDULE				
NUMBER	LABEL	QTY	FLOOR SIZE	COMMENTS
D01	D01-4068	2	1	4068
D02	D02-2668	3	1	2668
D03	D03-2068	1	1	2068
D04	D04-3068	2	1	3068
D05	D05-2468	4	1	2468
D06	D06-2868	1	1	2868


WINDOW SCHEDULE					
NUMBER	LABEL	QTY	FLOOR SIZE	DESCRIPTION	COMMENTS
W01	W01-2016	1	1	2016	AWNING
W02	W02-2030	1	1	2030	DOUBLE HUNG
W03	W03-2616	10	1	2616	AWNING
W04	W04-2630	1	1	2630	DOUBLE HUNG
W05	W05-2650	4	1	2650	DOUBLE HUNG
W06	W06-2816	1	1	2816	AWNING
W07	W07-3016	5	1	3016	AWNING
W08	W08-3050	4	1	3050	DOUBLE HUNG

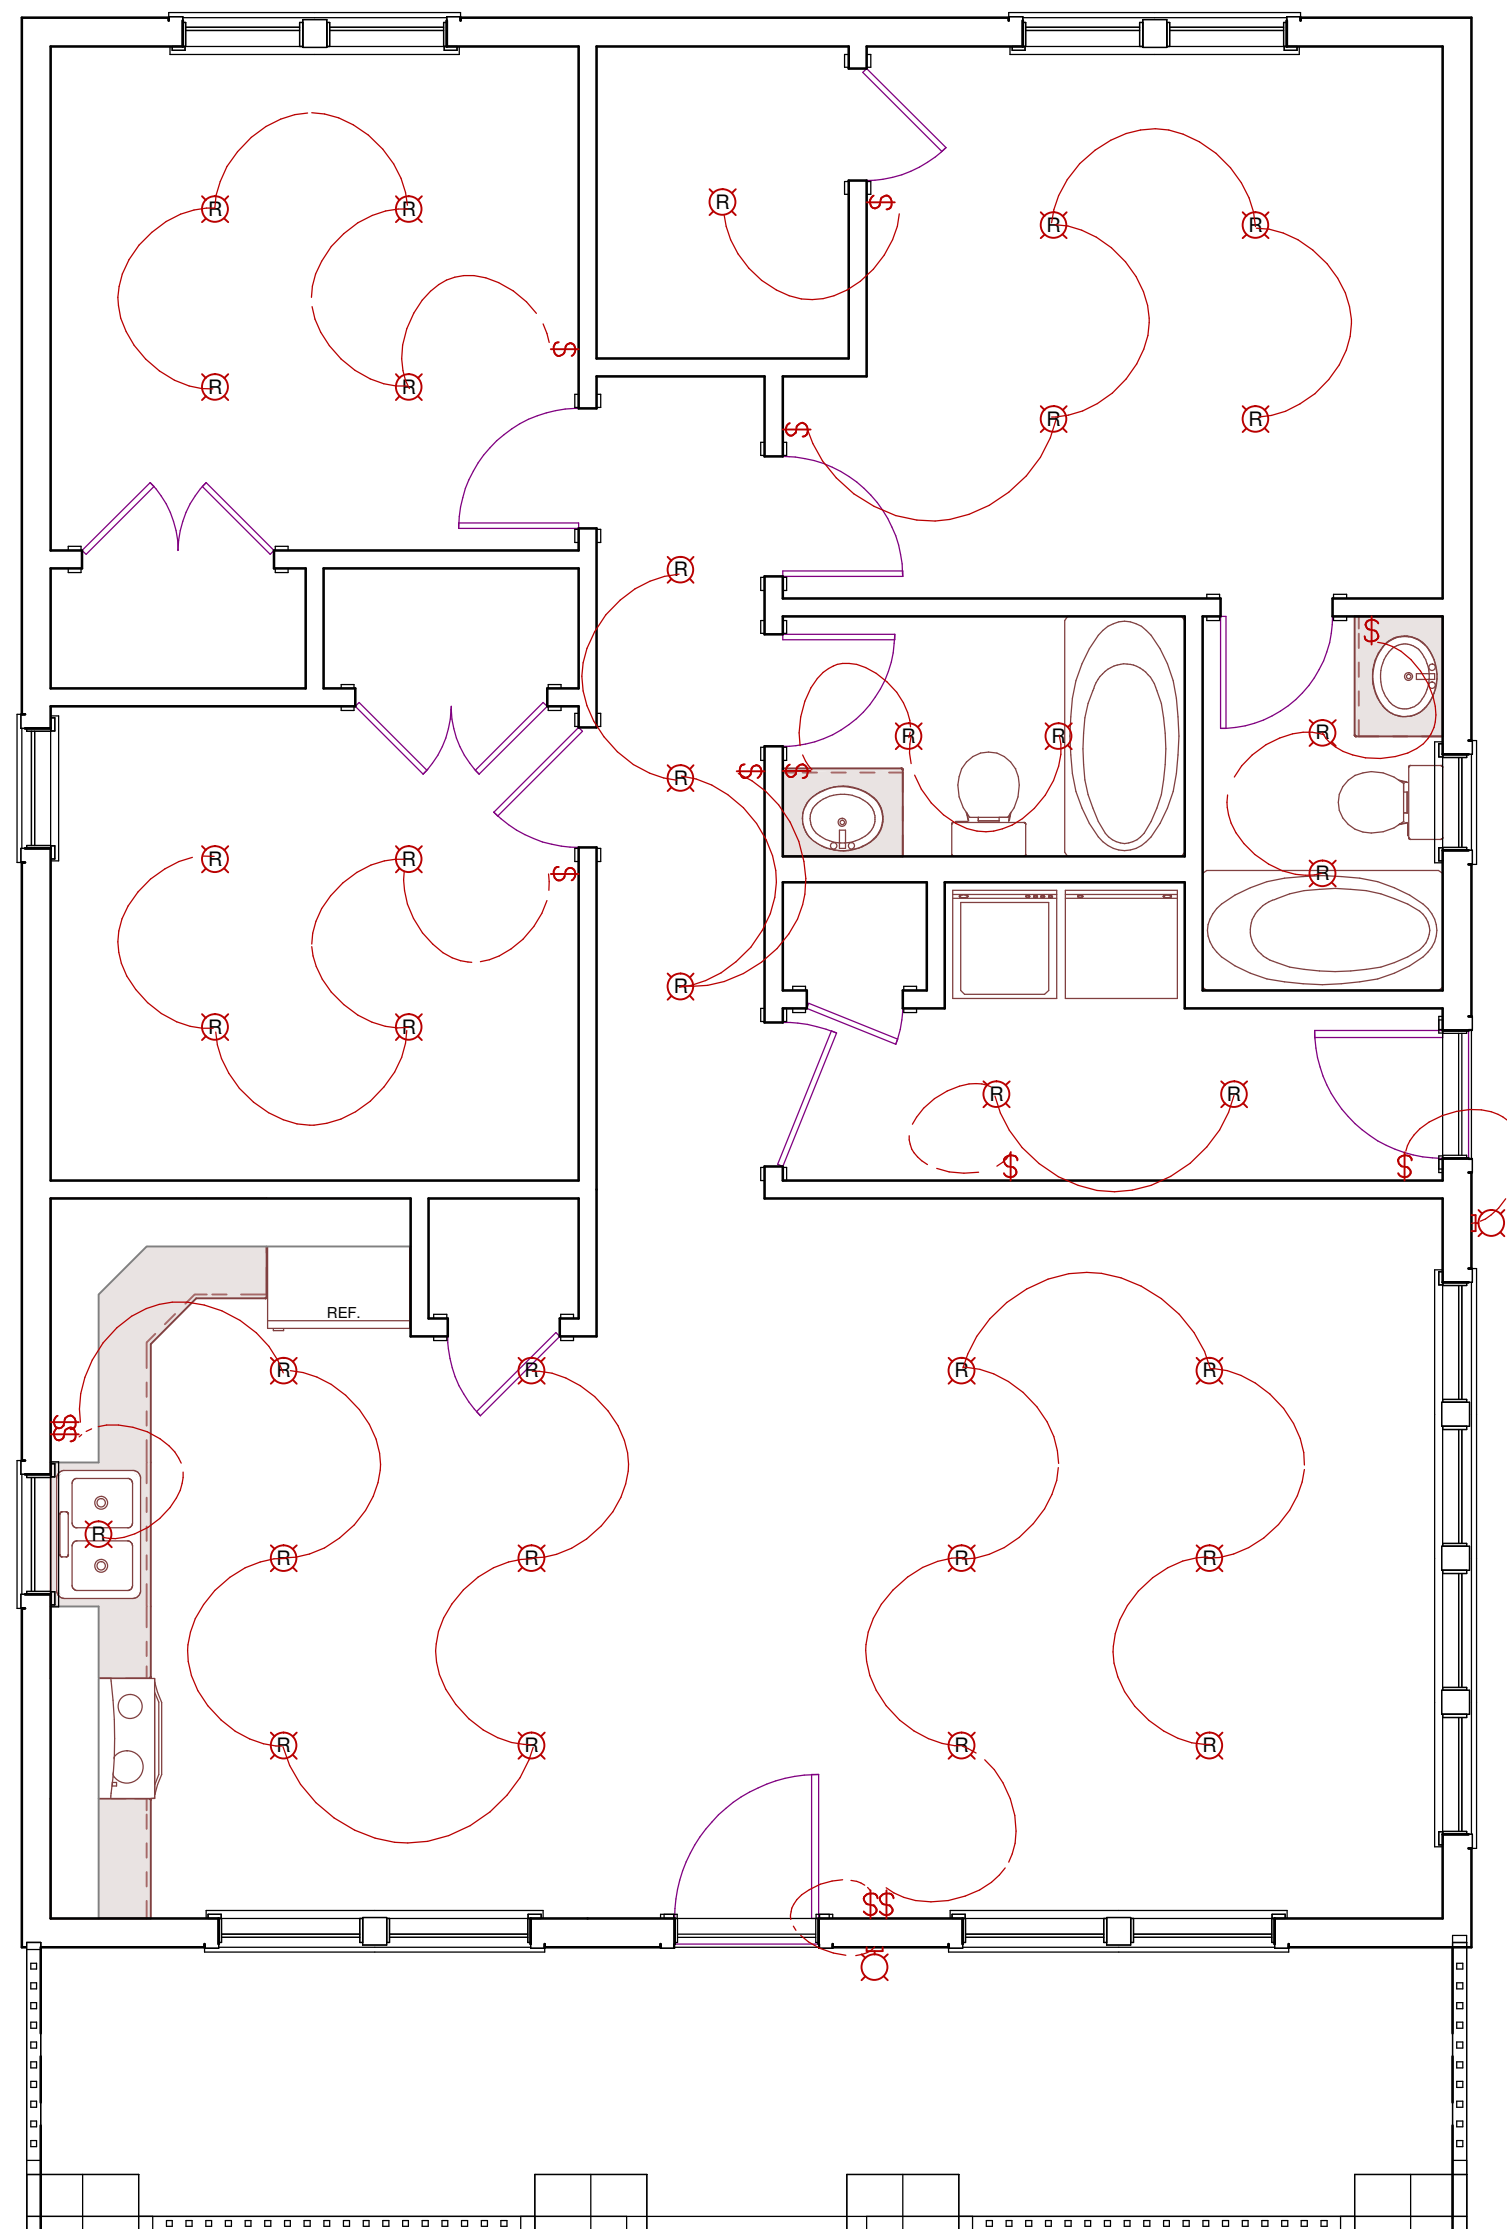

LIGHTING PLAN
SCALE: 1/4" = 1'

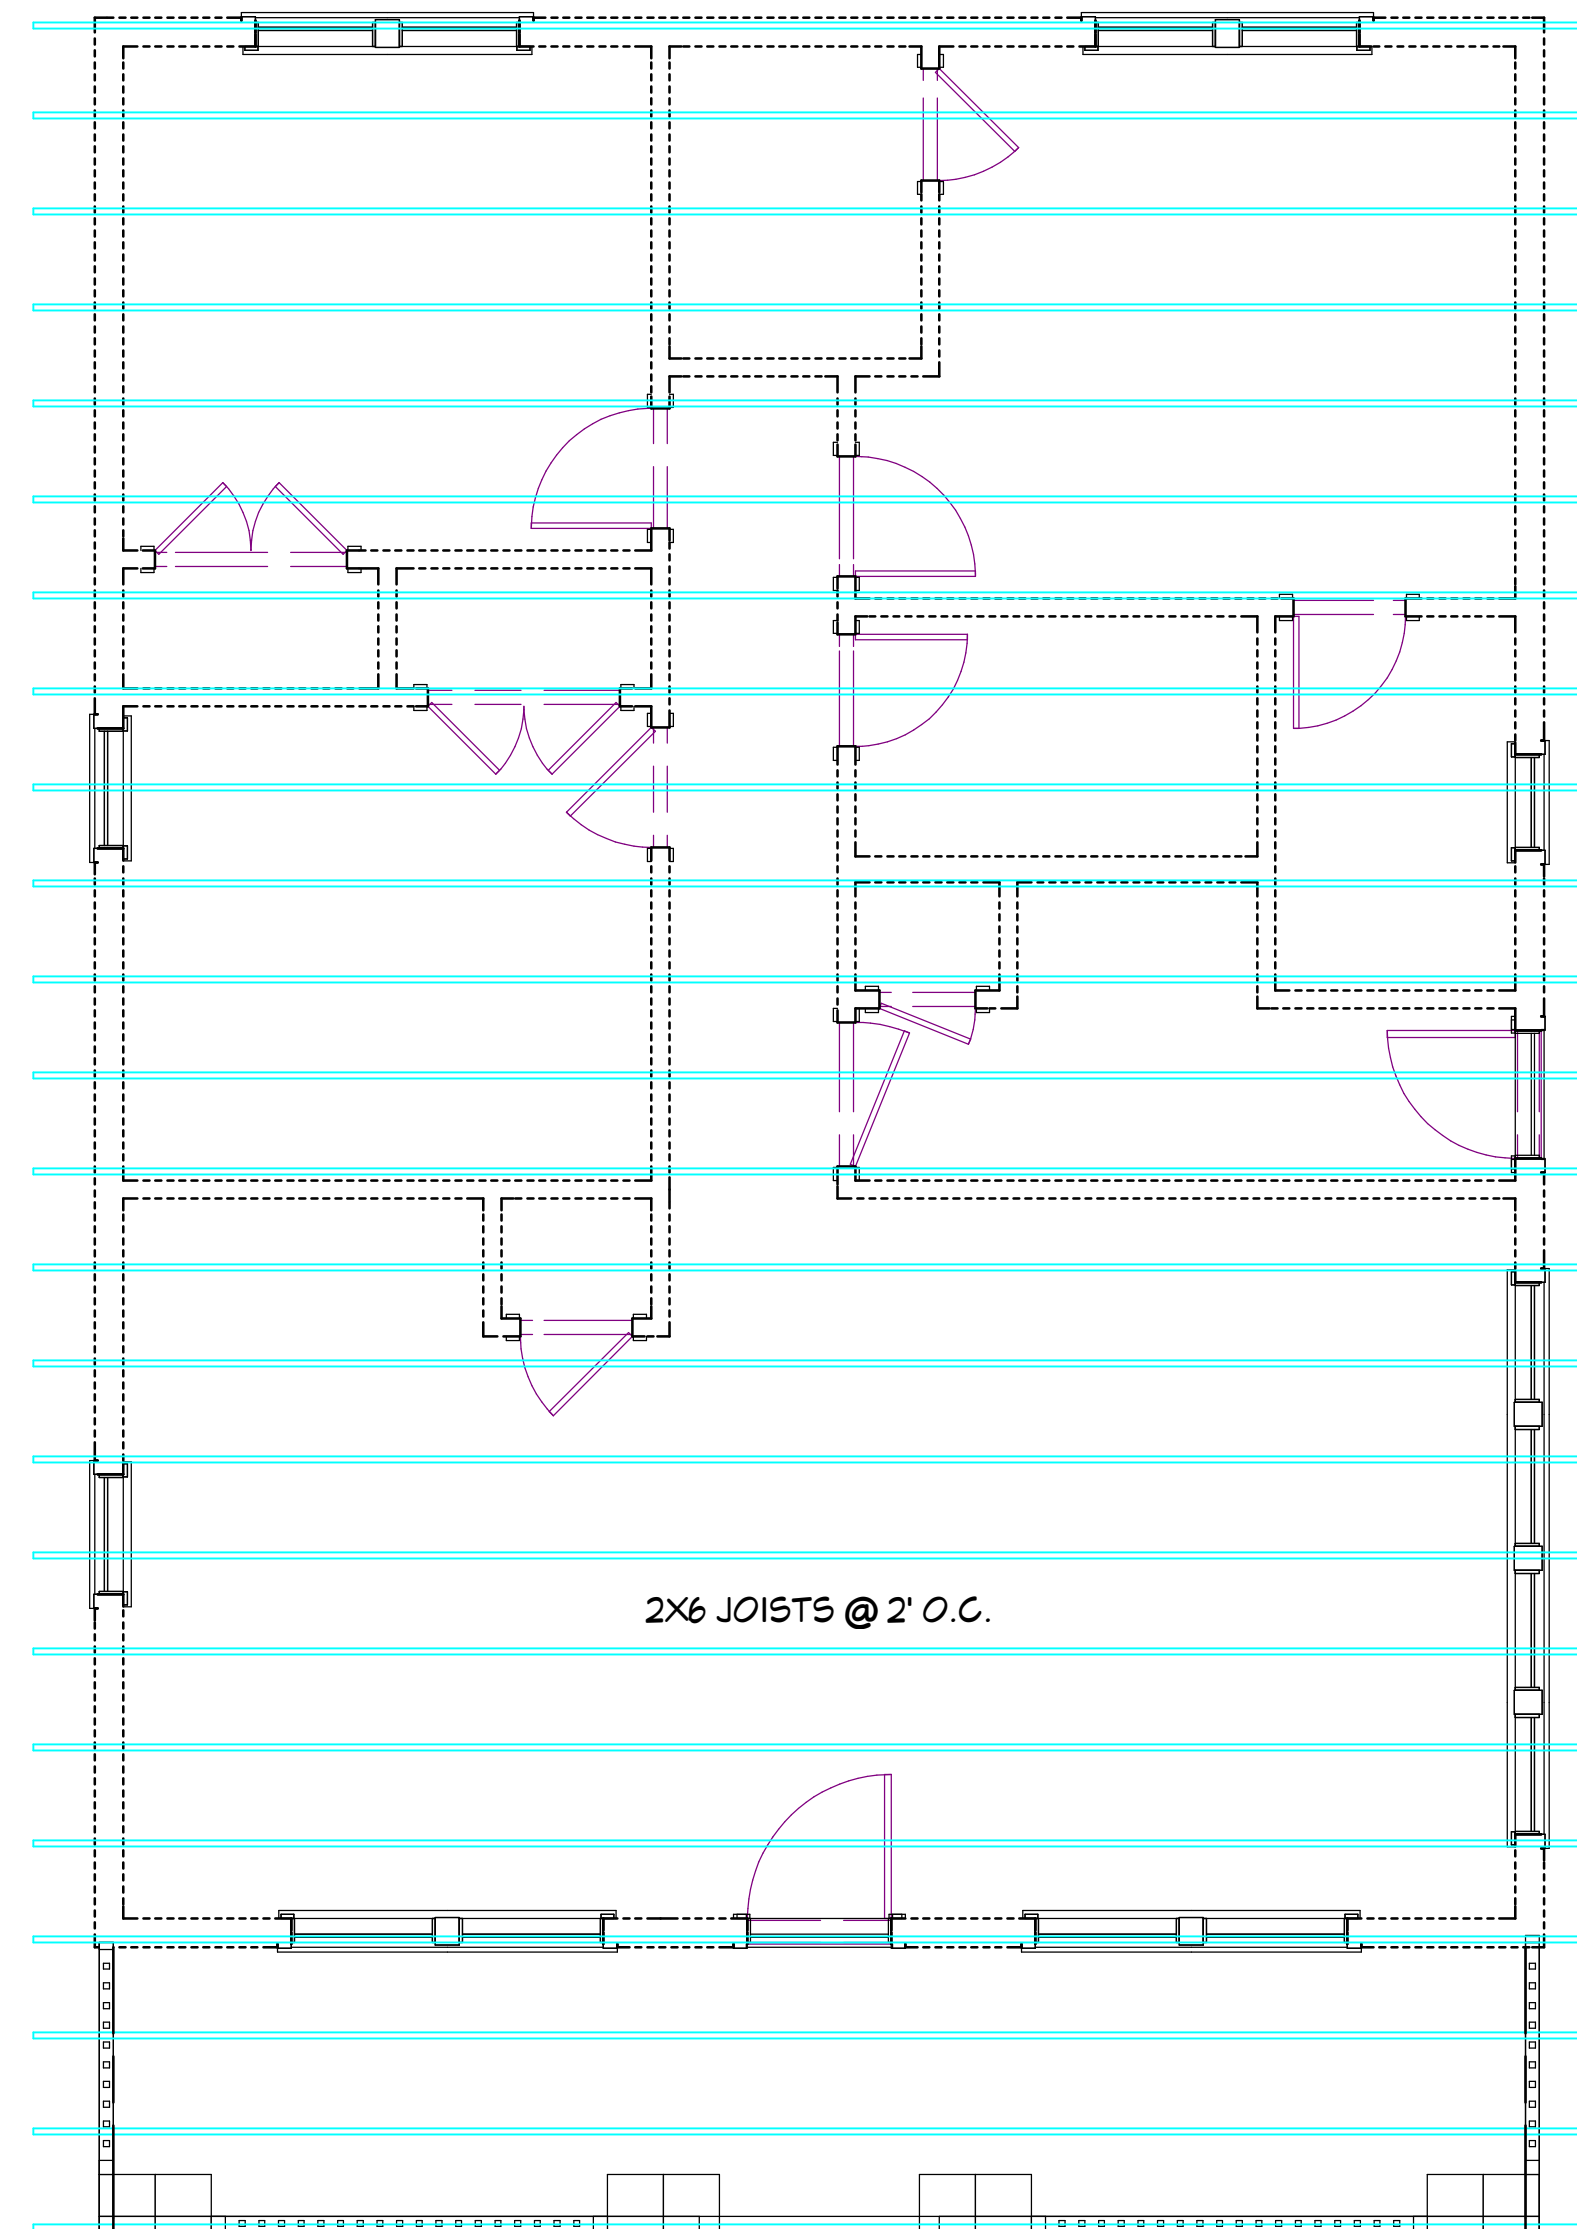

CEILING FRAMING PLAN
SCALE: 1/4" = 1'

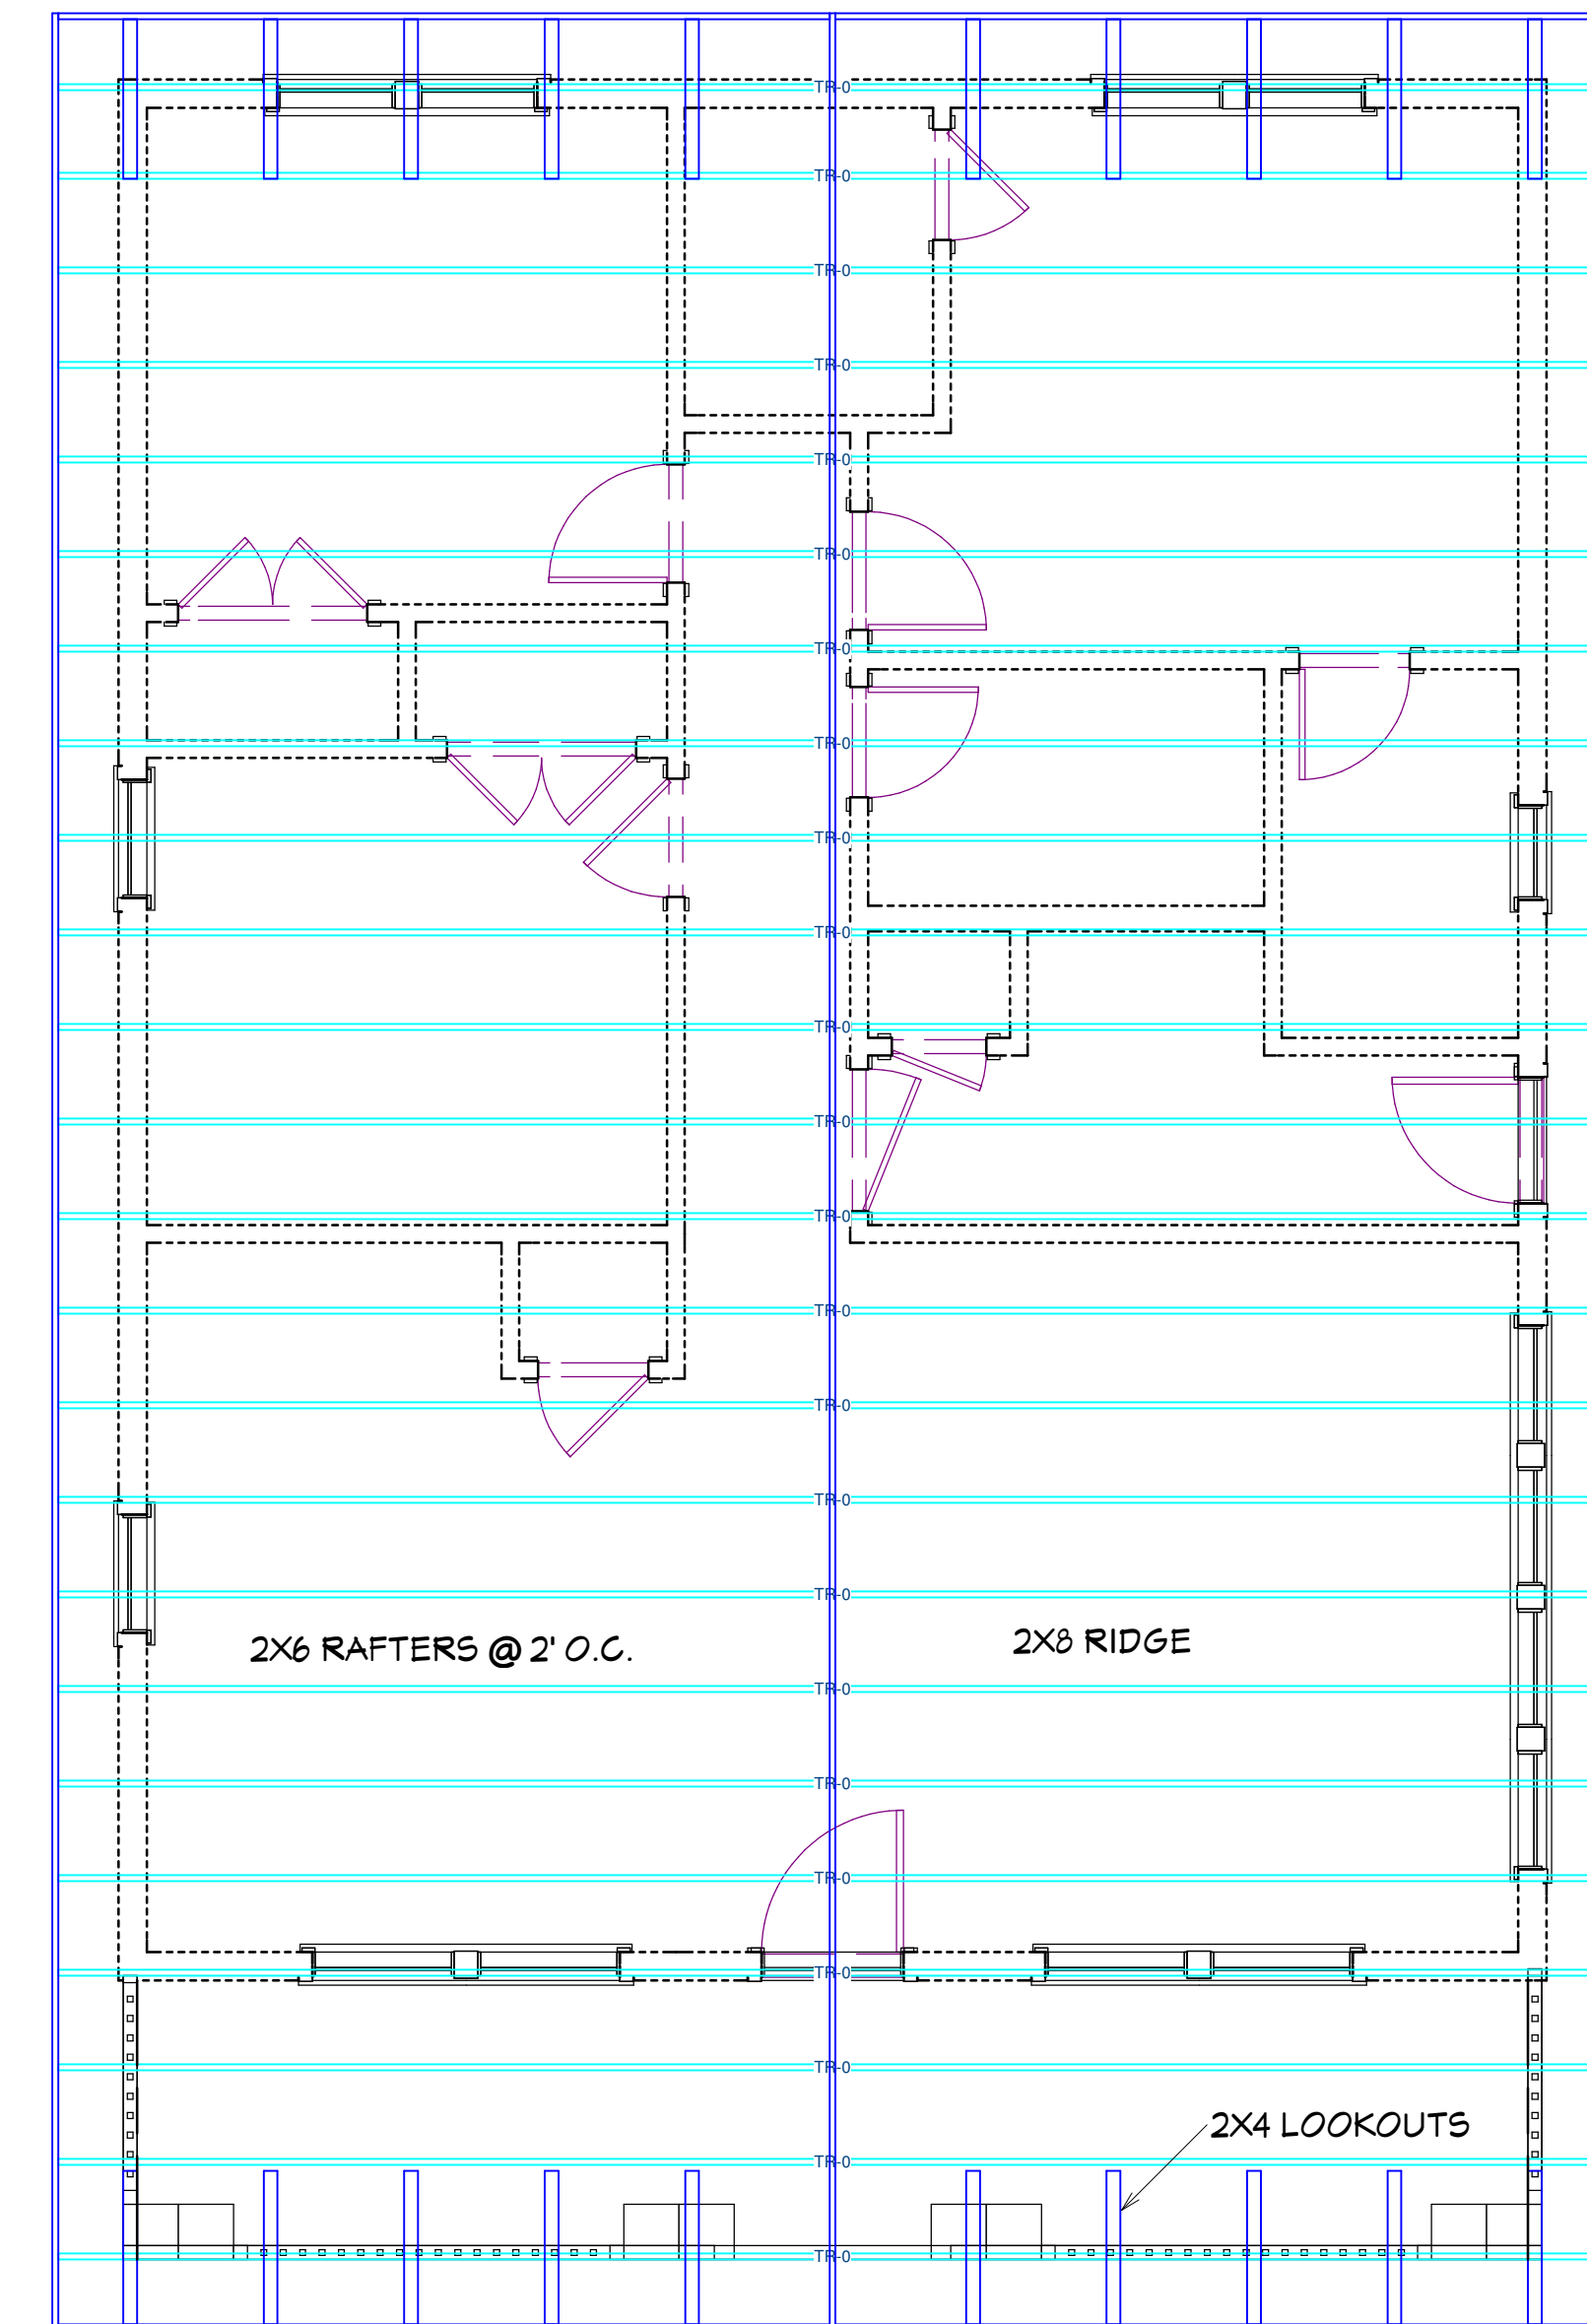

ROOF FRAMING PLAN
SCALE: 1/4" = 1'

ALL WIRING TO BE INSTALLED AS PER ACTUAL JOBSITE CONDITIONS, ELECTRICAL CODE AND HOME OWNER OR INTERIOR LIGHTING CONSULTANT. SHOWN IS SUGGESTED PLACEMENT OF LIGHTING AND SWITCHING AND MUST BE APPROVED BY HOMEOWNER PRIOR TO WORK.

- Ⓜ RECESSED DOWN LIGHT
- Ⓚ PORCH LANTERN

 
 
 
30x40 House
#30X40H3C

These plans were not prepared by nor checked by a licensed architect and/or engineer. E.F.P. does not represent or imply itself to be a licensed architect and/or licensed engineer. Enjoy these plans but use them at your own risk. Resale of these plans, in whole or part, is strictly prohibited.

Excellent Floor Plans
<https://sites.google.com/excellentfloorplans>
<https://www.ebay.com/str/excellentfloorplans>
<https://excellentfloorplans.etsy.com>

IDEAS

30x40 House
#30X40H3C



PAGE:

4

SHEETS:

4

These plans were not prepared by nor checked by a licensed architect and/or engineer.
E.F.P. does not represent or imply itself to be a licensed architect and/or licensed engineer.
Enjoy these plans but use them at your own risk.
Resale of these plans, in whole or part, is strictly prohibited.

Excellent Floor Plans

<https://sites.google.com/excellentfloorplans>

<https://www.ebay.com/str/excellentfloorplans>

<https://excellentfloorplans.etsy.com>