


ELECTRICAL PLAN

1/4" = 1'-0" 2

ELECTRICAL LEGEND

- |  |                          |                   |                                     |  |   |     |   |
|--|--------------------------|-------------------|-------------------------------------|--|---|-----|---|
|  | — CEILING FAN WITH LIGHT | ⊕                 | — SINGLE SWITCH                     |  | — TELEVISION                                  | ⋯⋯⋯ | — 36" HOLLYWOOD FIXTURE                   |
|  | — CEILING FAN            | ⊕ <sub>3</sub>    | — 3-WAY SWITCH                      |  | — TELEPHONE                                   | ⋯⋯⋯ | — 24" HOLLYWOOD FIXTURE                   |
|  | — 24"x48" FLOURESCENT    | ⊕ <sub>4</sub>    | — 4-WAY SWITCH                      |  | — SMOKE DETECTORS TO BE LOCATED UNDER CEILING |     | — PUSHBUTTON                              |
|  | — 12"x48" FLOURESCENT    | ⊕                 | — DIMMER SWITCH                     |  | — WALL MOUNT FIXTURE                          |     | — DOORBELL CHIME                          |
|  |                          | ⊕                 | — OUTLET                            |  | — CEILING MOUNT FIXTURE                       |     | — DISPOSAL                                |
|  |                          | ⊕ <sub>220V</sub> | — 220V OUTLET                       |  | — EXHAUST FAN                                 |     | — UNDERCOUNTER FLOURESCENT FIXTURE        |
|  |                          | ⊕ <sub>GF</sub>   | — GROUND FAULT OUTLET               |  | — RECESS FIXTURE                              |     | — MOTION DETECTOR WALL MOUNT PACK FIXTURE |
|  |                          | ⊕ <sub>WPF</sub>  | — WEATHER PROOF GROUND FAULT OUTLET |  | — WATER PROOF RECESS FIXTURE                  |     | — PENDANT FIXTURE                         |

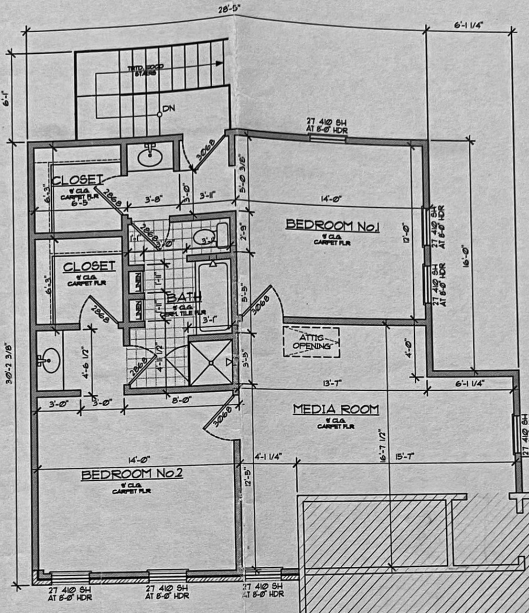

EXISTING HOUSE

SQUARE FOOTAGE  
SECOND STORY ADDITION 853 SF.

1/4" = 1'-0" 1

FLOOR PLAN

Revisions:

No.	Date	Description

**PHILIP LEUNG**  
HOUSE ADDITION  
Houston, Texas



**ESTEBAN A. RAMON**  
Space Design Solutions  
7816 N. WINDY ASH CT.  
HOUSTON, TEXAS, 77133  
Phone: (281) 331-4200 FAX: (281) 331-4201  
EMAIL: eramon@spacedesign.com

Project No: 2010-15  
Plot Date: Sept-08-10  
Issued For:  
Review \_\_\_\_\_  
Pricing \_\_\_\_\_  
Construction \_\_\_\_\_  
Drawn By: ER

Sheet Title:  
FLOOR PLAN ADDITION

**A1**