


MOONLIGHT HOUSE PLANS

324 AZALEA, LAKE JACKSON, TX. 77566
979-482-1967

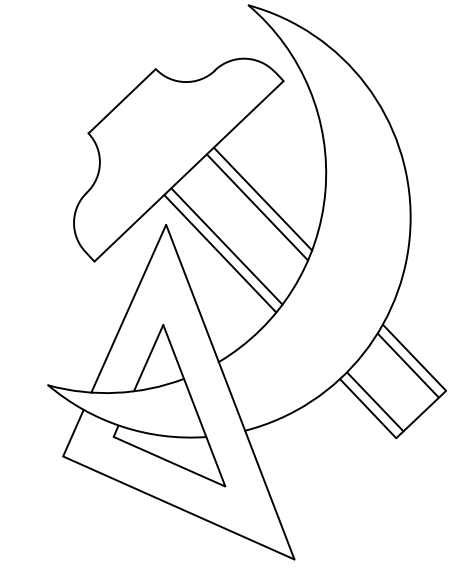

WARD


PLAN 1600 - F

PLAN#: 20212353
LIVING: 1600 SQ.FT.
GARAGE: 428 SQ.FT.
PORCH: 35 SQ.FT.
COV PATIO: 137 SQ.FT.
TOTAL: 2200 SQ.FT.


MOONLIGHT HOUSE PLANS IS A DRAFTING FIRM, NOT AN ENGINEERING, OR ARCHITECTURAL FIRM. THESE PRINTS ARE TO BE APPROVED BY A LOCAL ENGINEER FOR ALL STRUCTURAL BEINGS. MOONLIGHT HOUSE PLANS IS NOT RESPONSIBLE FOR ANY STRUCTURAL OR DESIGN MISTAKES. ALL SUBCONTRACTORS SHALL VERIFY ANY & ALL DIMENSIONS, DETAILS & SPECIFICATIONS.

DESIGNER WILL NOT BE LIABLE FOR HUMAN ERROR AFTER CONSTRUCTION IS STARTED.


THESE DRAWINGS, SPECIFICATIONS AND IDEAS ARE THE PROPERTY OF MOONLIGHT HOUSE PLANS. AND SHALL NOT BE REUSED, REPRODUCED, OR ALTERED IN ANY WAY.

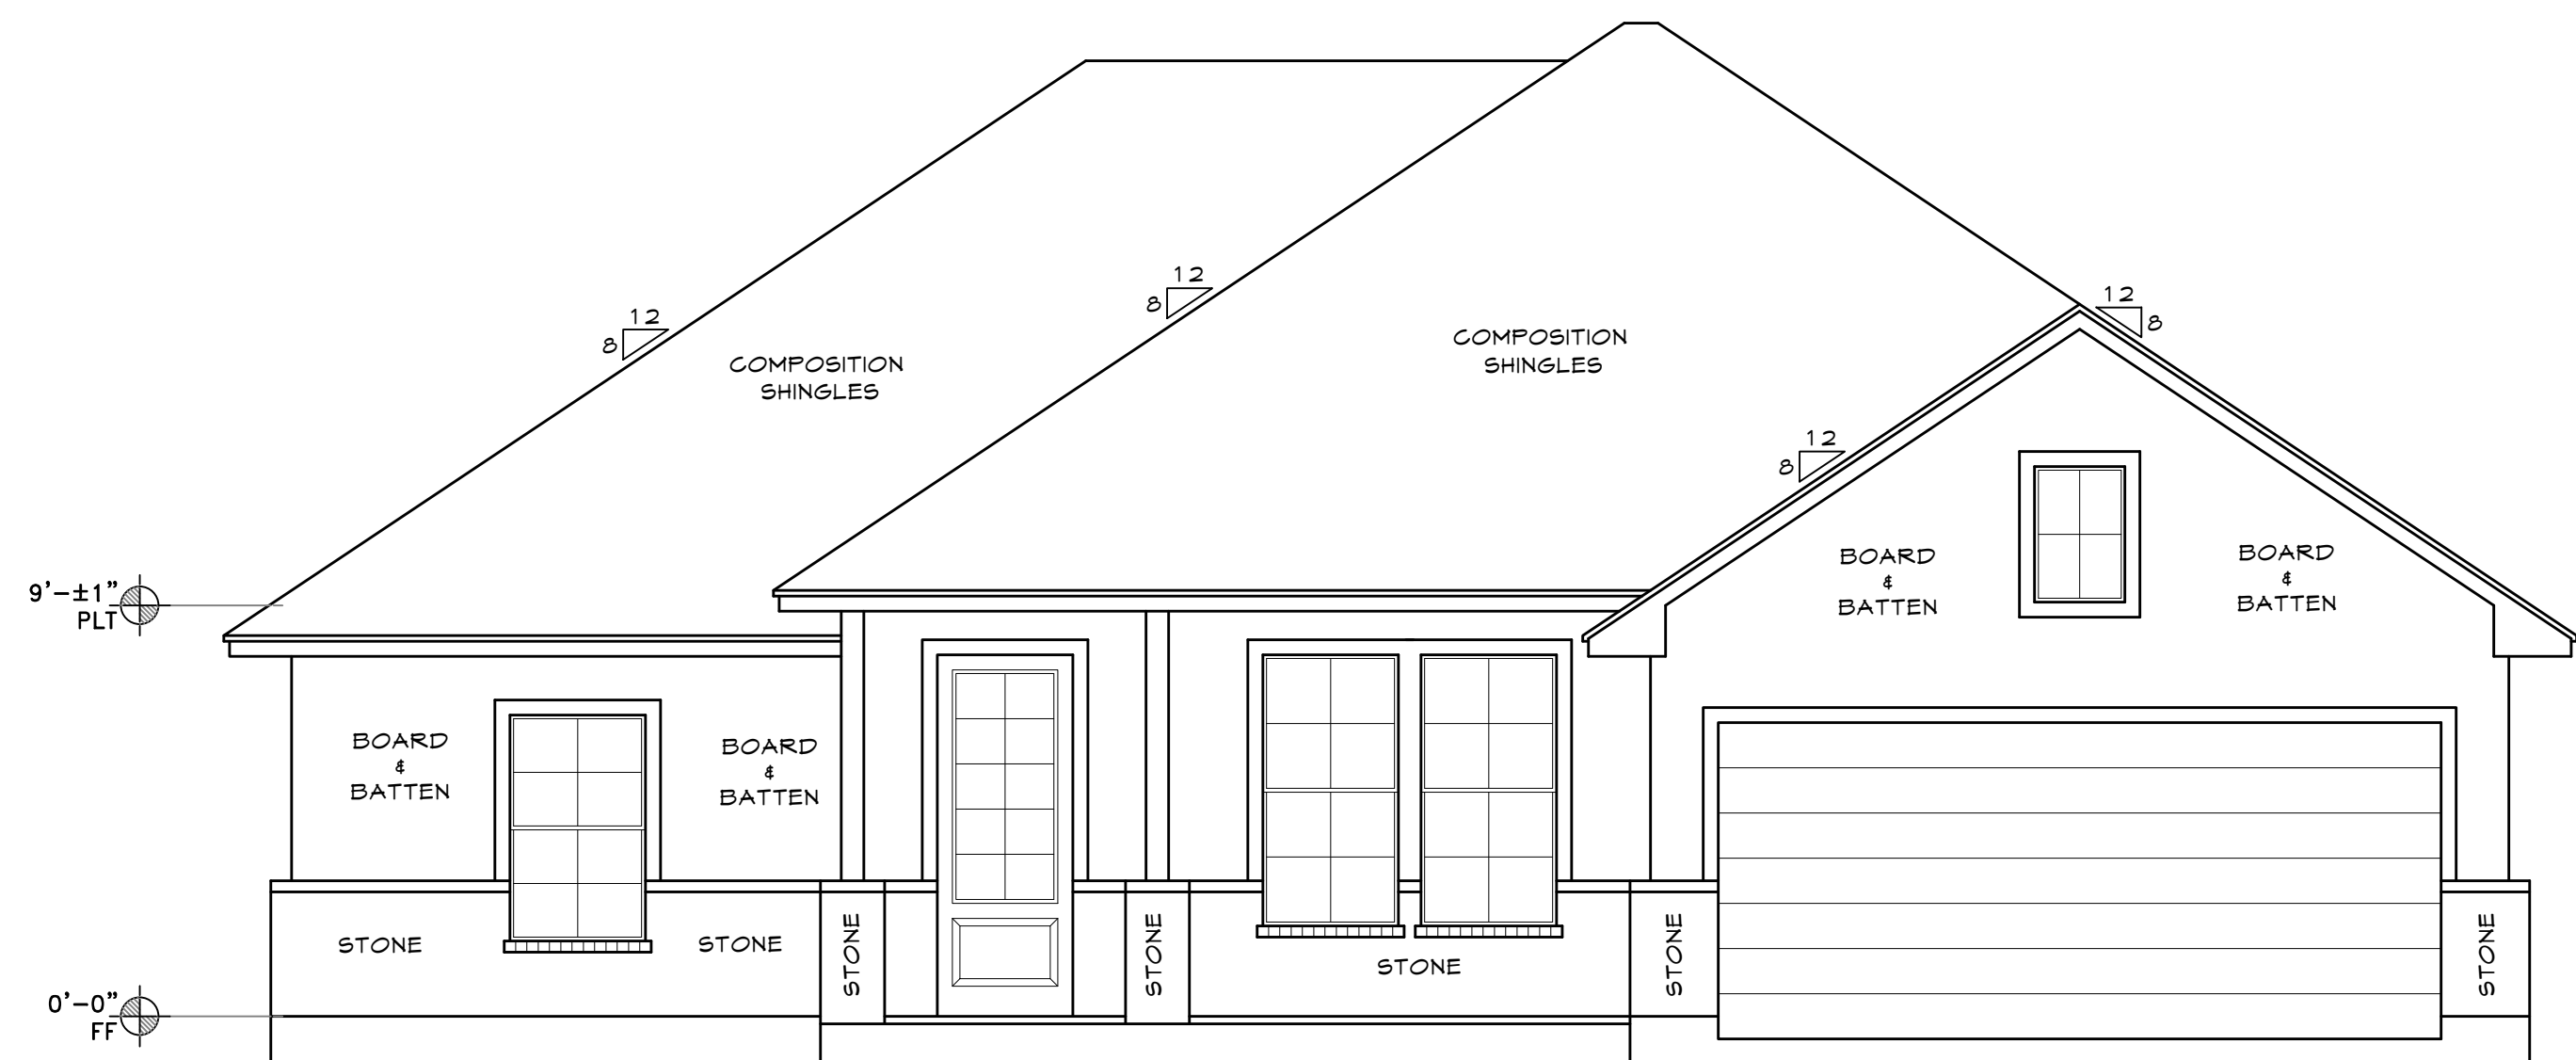


1 FRONT VIEW
A1 SCALE: 1/4" = 1'

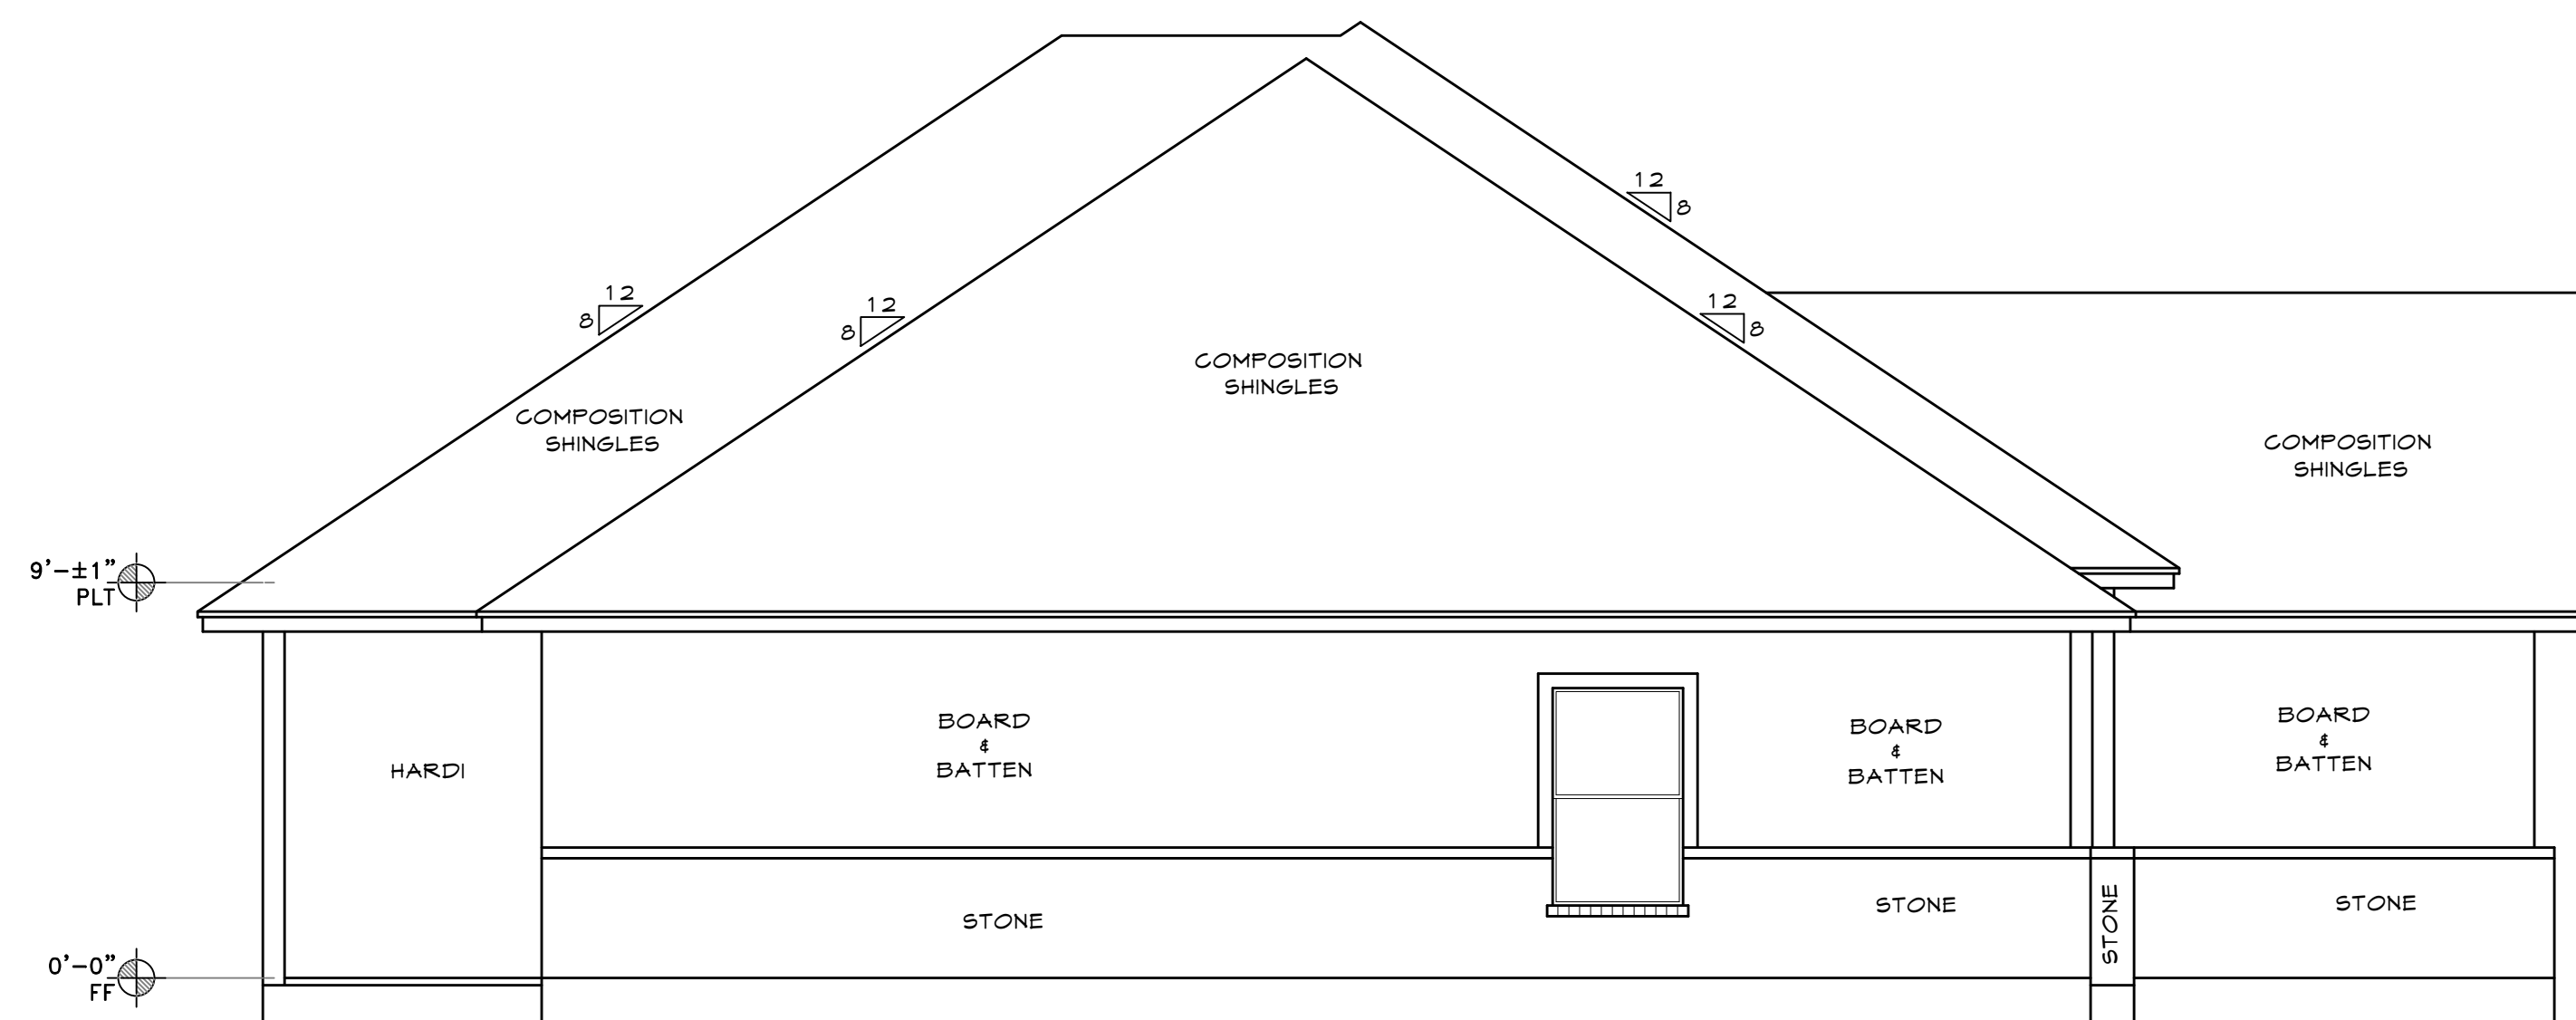

2 LEFT SIDE VIEW
A1 SCALE: 1/4" = 1'

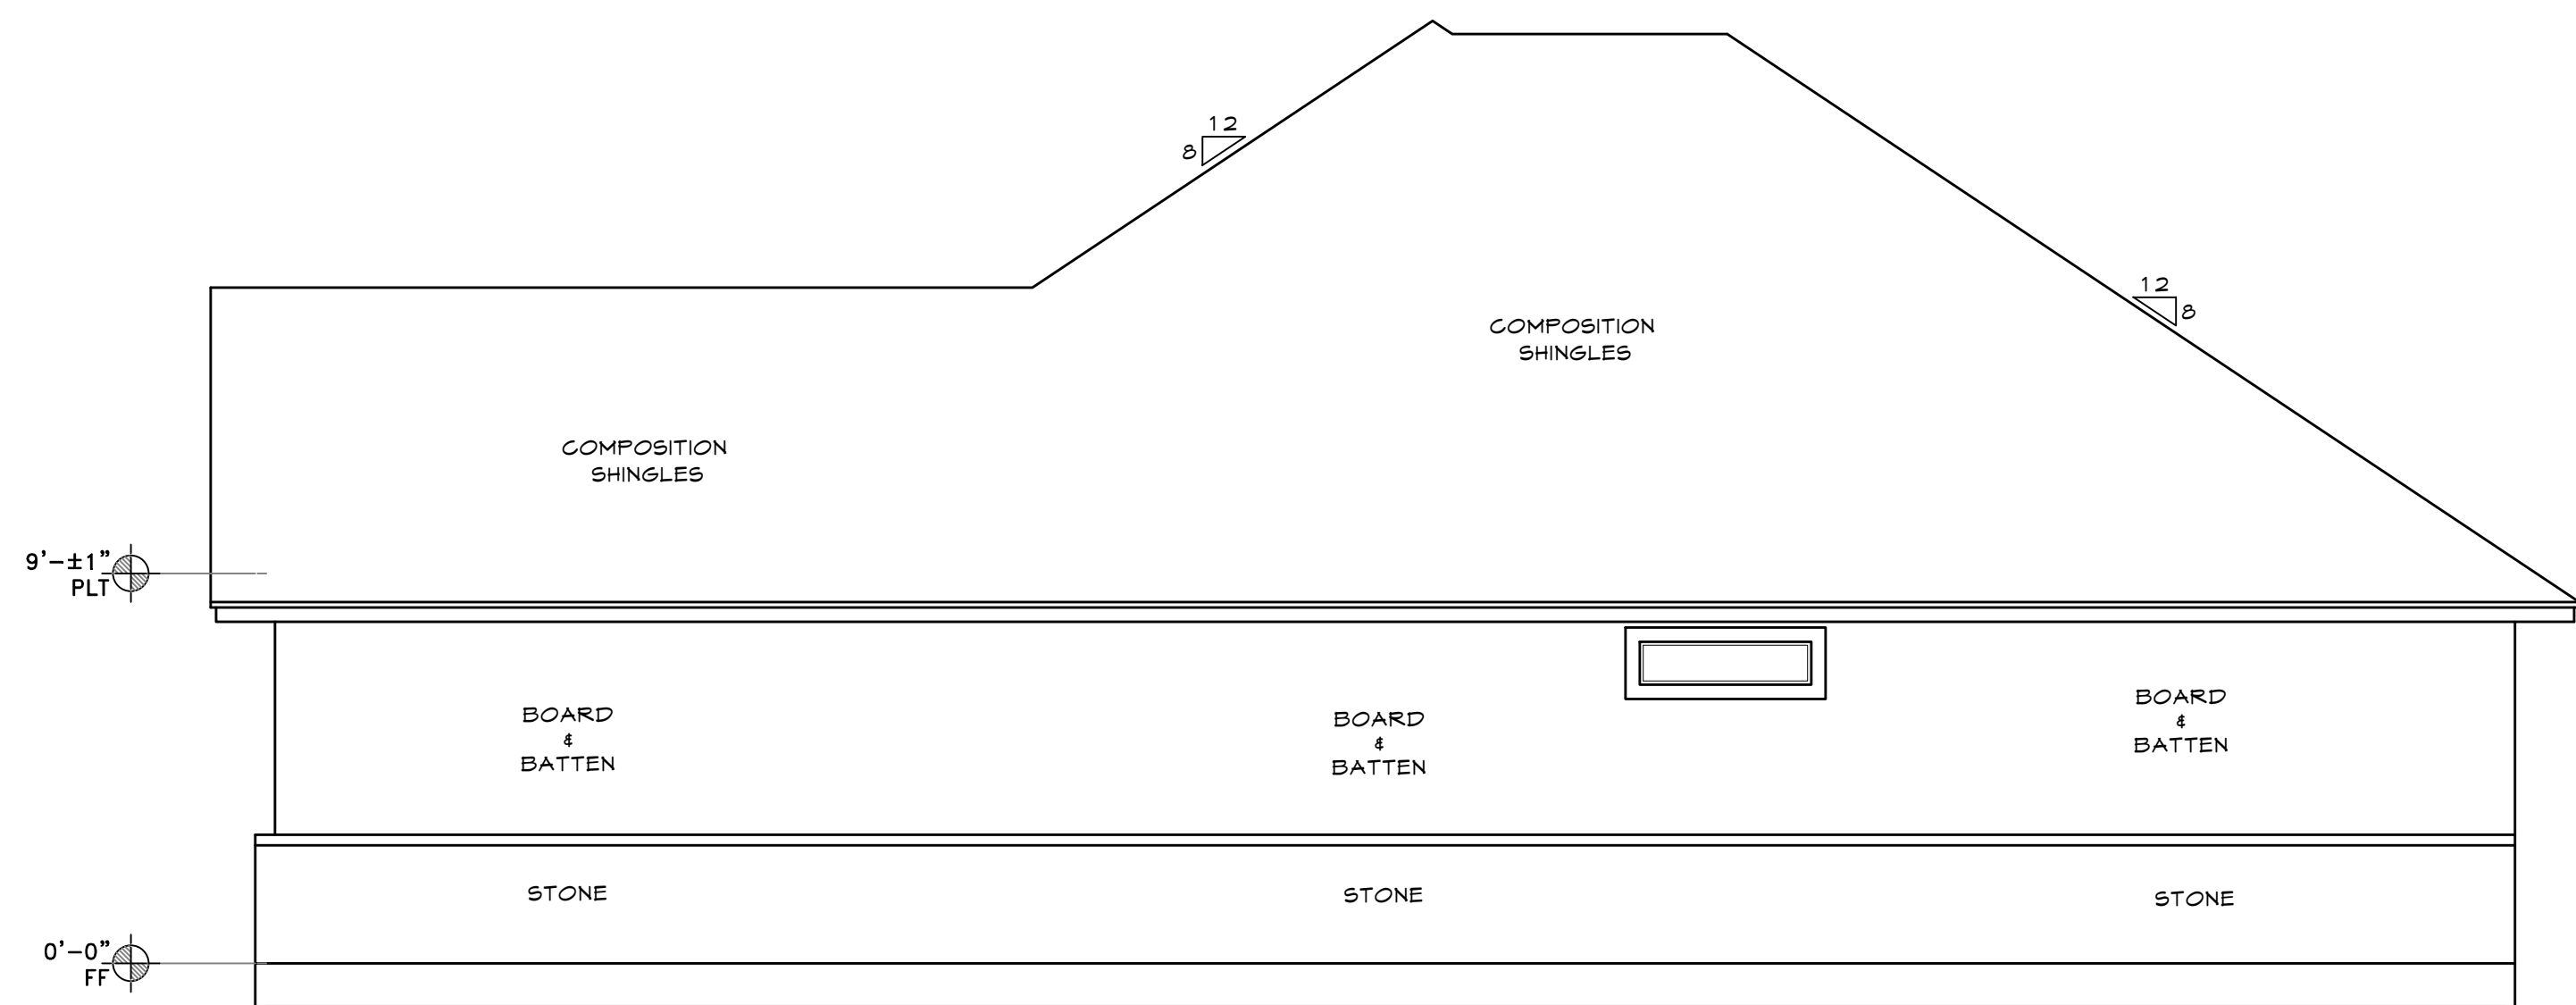

2 RIGHT SIDE VIEW
A2 SCALE: 1/4" = 1'

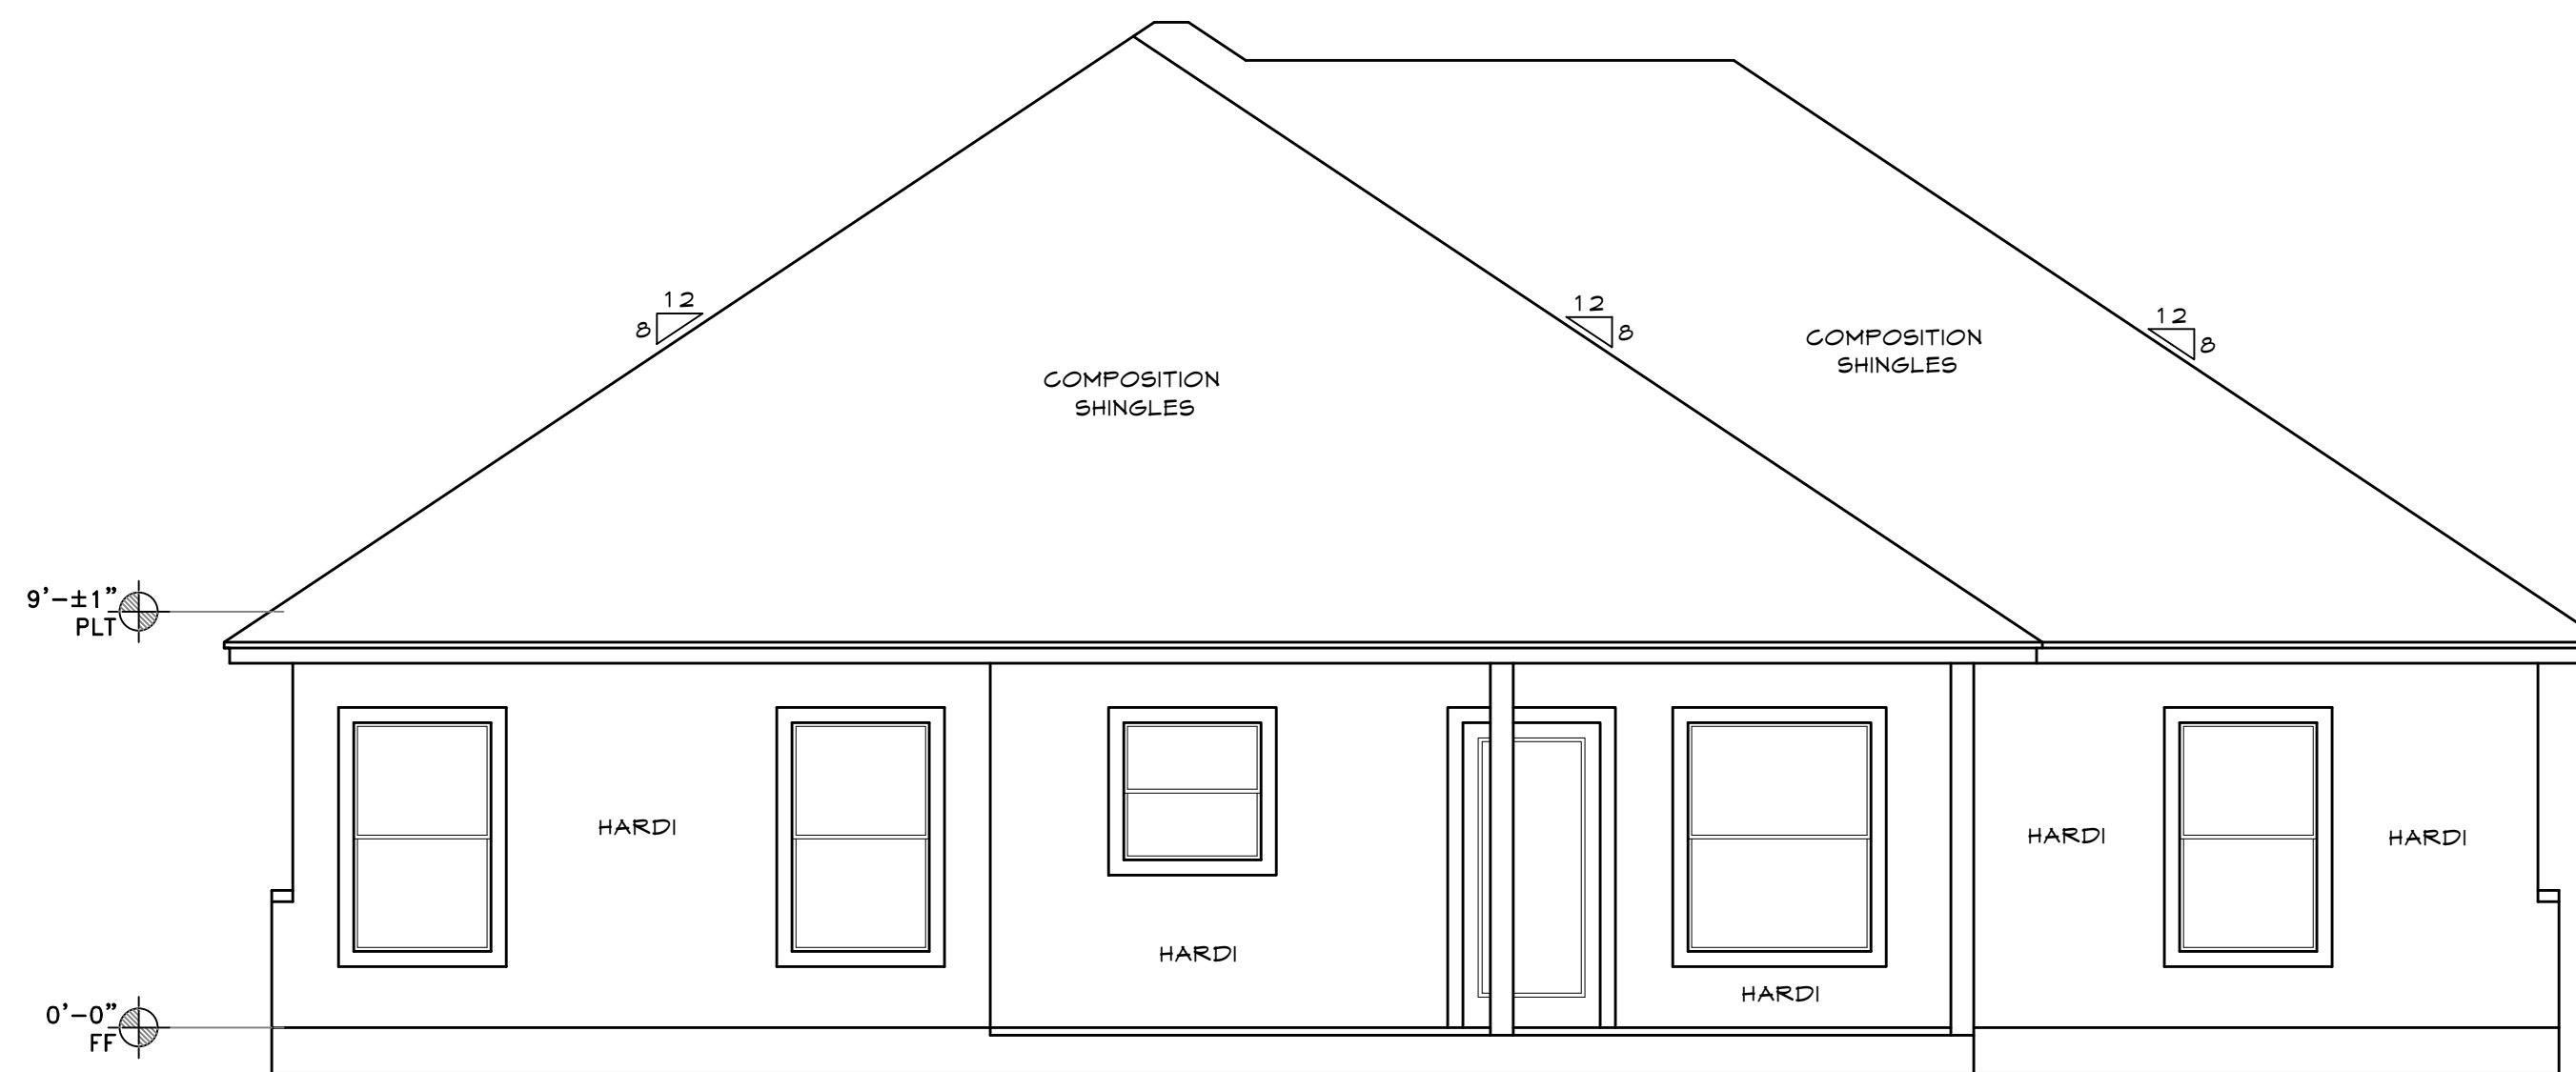

1 REAR VIEW
A2 SCALE: 1/4" = 1'

MOONLIGHT HOUSE PLANS IS A DRAFTING FIRM, NOT AN ENGINEERING OR ARCHITECTURAL FIRM. THESE PRINTS ARE NOT TO BE USED FOR CONSTRUCTION. MOONLIGHT HOUSE PLANS IS NOT RESPONSIBLE FOR ANY STRUCTURAL OR DESIGN MISTAKES, DIMENSIONS, DETAILS & SPECIFICATIONS. DESIGNER WILL NOT BE LIABLE FOR HUMAN ERRORS AFTER CONSTRUCTION IS STARTED. THESE DRAWINGS, SPECIFICATIONS AND IDEAS ARE THE PROPERTY OF MOONLIGHT HOUSE PLANS, AND SHALL NOT BE REUSED, REPRODUCED, OR ALTERED IN ANY WAY.

Moonlight House
Plans
979-482-1967


REVISION HISTORY	DATE
NUMBER	

DWG. SCALE:
1/4" = 1'-0"

ELEVATIONS
WARD
PLAN 1600-F
JOB #: 20212353

06-30-21

A2

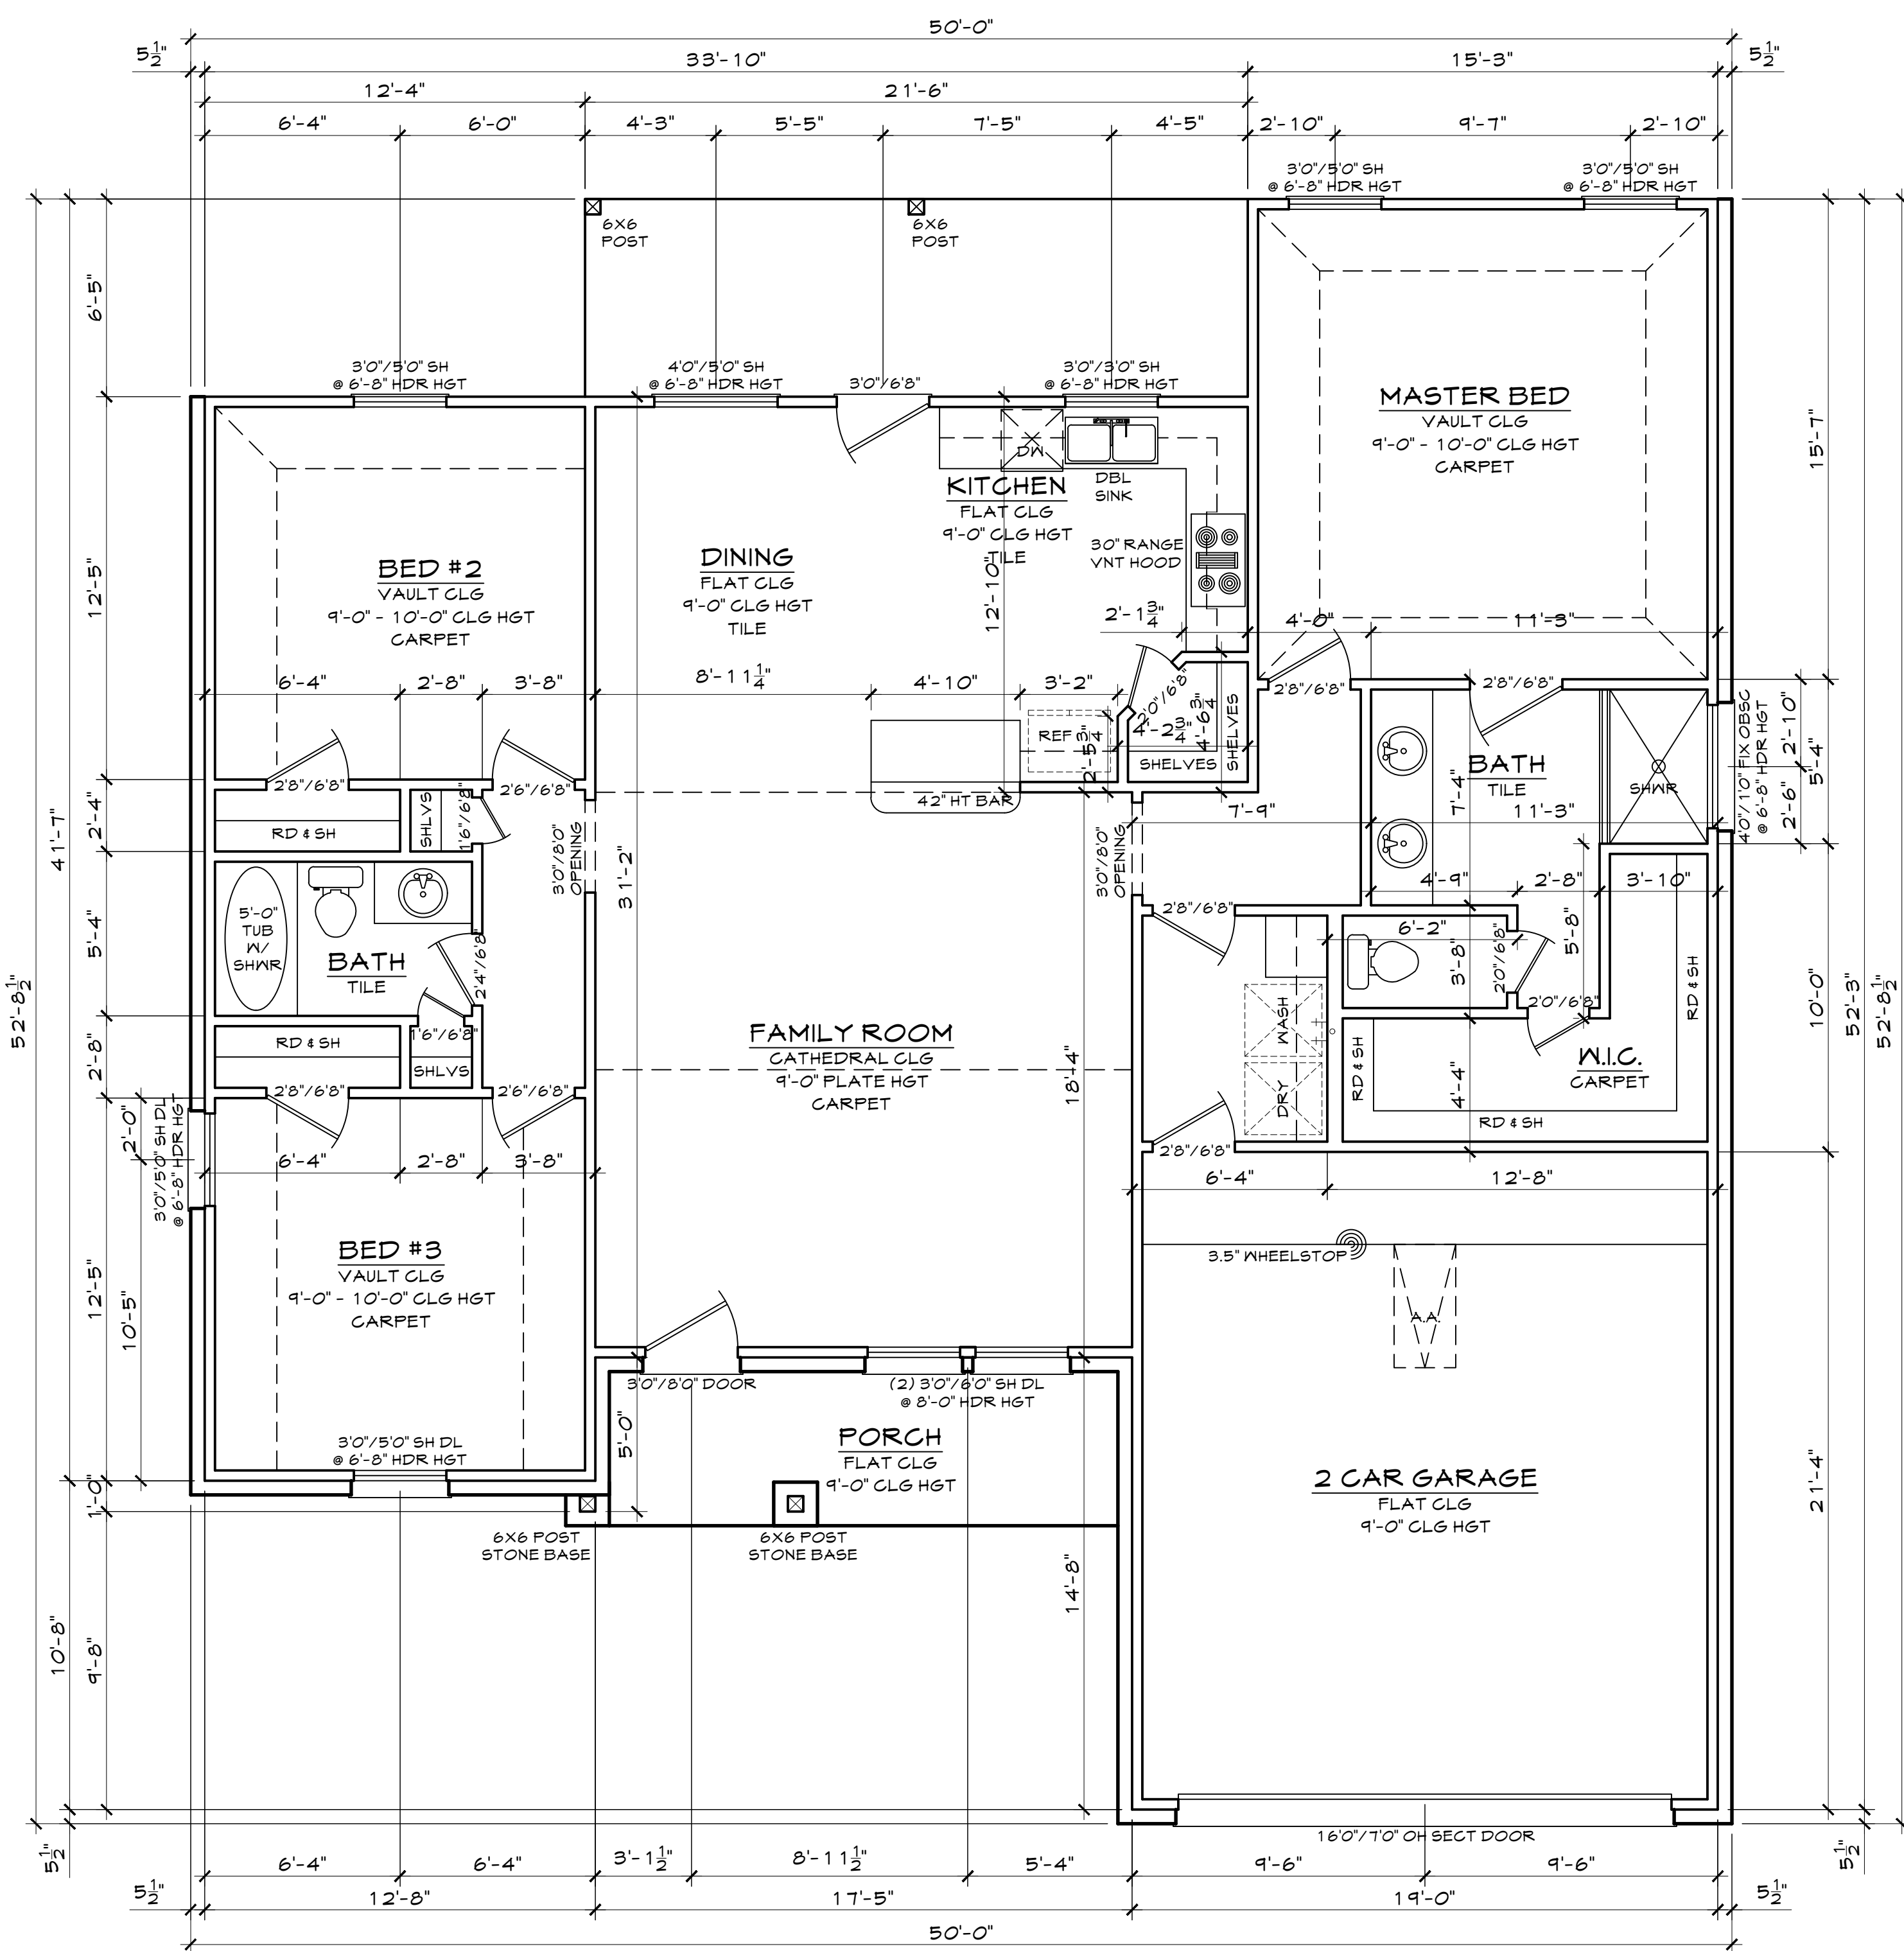


1 FLOOR PLAN
SCALE: 1/4" = 1'

ABBREVIATIONS

SH	SINGLE HUNG	EB	EYE BROW	PAN	PANTRY	W.I.C.	WALK-IN CLOSET
DL	DIVIDED LIGHTS	PKT	POCKET	RM	ROOM	DBL	DOUBLE
HD	HEADER	DR	DOOR	CLST	CLOSET	SNK	SINK
HT	HEIGHT	FG	FIXED GLASS	SHLV	SHELVES	DW	DISH WASHER
OH	OVERHEAD	OBSSG	OBSCURED GLASS	CW	COLD WATER TAP	MSTR	MASTER
SECT	SECTIONAL	/BTH	HALF BATH	CLG	CEILING		

SYMBOL	DESCRIPTION	SYMBOL	DESCRIPTION	SYMBOL	DESCRIPTION
	RECESSED LIGHT FIXTURE		110 V. DUPLEX RECEPT OUTLET		DIMMER SWITCH
	CEILING MOUNTED LIGHT FIXTURE		110 V. FLOOR OUTLET		GARAGE DOOR OPENER
	WALL MOUNT LIGHT FIXTURE		GROUND FAULT INTERRUPTER DUPLEX RECEPTACLE OUTLET		PUSH BUTTON GARAGE DOOR
	VENT		WATER PROOF OUTLET		DOOR BELL
	SMOKE DETECTOR		SINGLE POLE SWITCH		BREAKER PANEL
	220 V. DUPLEX RECEPT OUTLET		2 WAY SWITCH		TELEVISION JACK

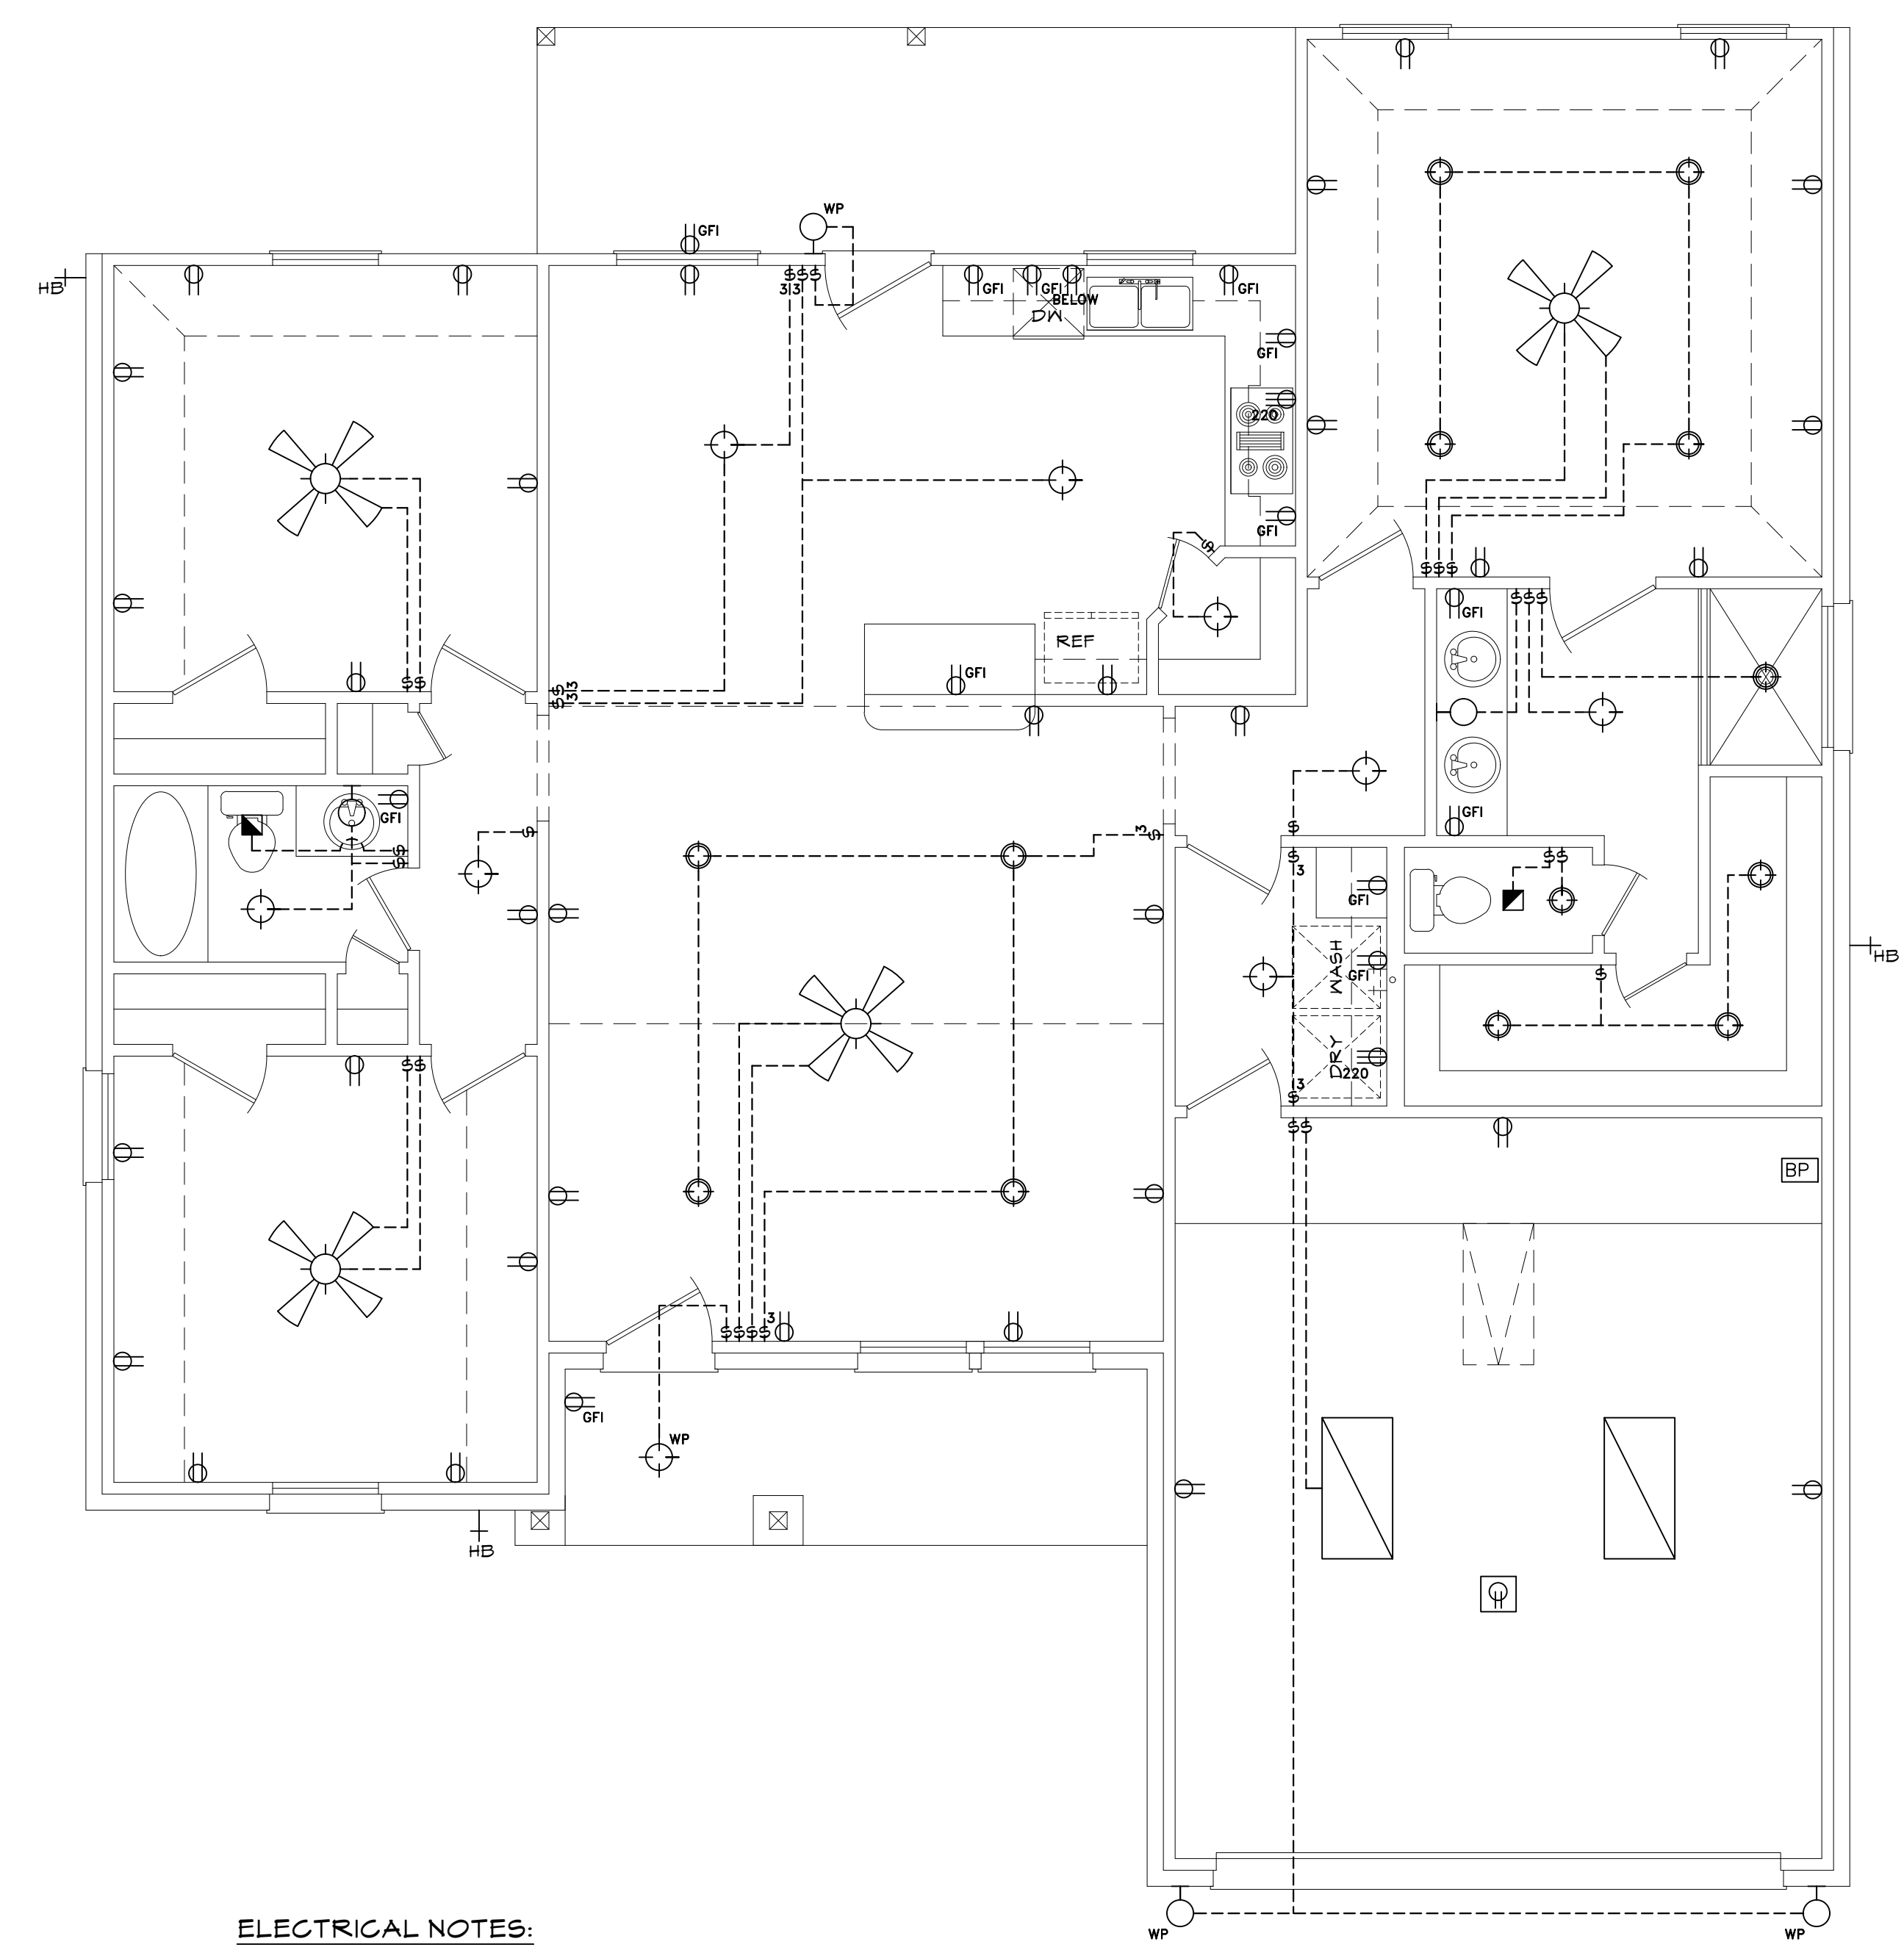

ELECTRICAL NOTES:
 -SMOKE DETECTORS IN ALL BED ROOMS, REQUIRE 110V TO HOUSE WIRING, BATTERY BACKUP & INTERCONNECT
 -VENT ALL EXHAUST FANS TO OUTSIDE
 -PROVIDE G.F.I. PROTECTION ON BATH PLUGS
 -PROVIDE LIGHT FIXTURE & SMOKE DETECTORS AT WATER HEATER & A/C UNIT
 -PROVIDE ELECTRIC DISCONNECT AT A/C UNIT

2 ELECTRICAL
SCALE: 1/4" = 1'

MOONLIGHT HOUSE PLANS IS A DRAFTING FIRM, NOT AN ENGINEERING OR ARCHITECTURAL FIRM. THESE PRINTS ARE NOT TO BE USED FOR CONSTRUCTION. MOONLIGHT HOUSE PLANS IS NOT RESPONSIBLE FOR ANY STRUCTURAL OR DESIGN MISTAKES. DIMENSIONS, DETAILS & SPECIFICATIONS.
 DESIGNER WILL NOT BE LIABLE FOR HUMAN ERROR AFTER CONSTRUCTION IS STARTED.
 THESE DRAWINGS, SPECIFICATIONS AND DECS ARE THE PROPERTY OF MOONLIGHT HOUSE PLANS, AND SHALL NOT BE REUSED, REPRODUCED, OR ALTERED IN ANY WAY.

Moonlight House Plans
979-482-1967

REVISION HISTORY	DATE
NUMBER	

DWG. SCALE: 1/4" = 1'-0"

FLOOR PLAN
WARD
PLAN 1600-F
JOB #: 20212953

06-30-21

A2