




Designer: Prisciliano Martinez






CUSTOMER: FRANCISCO CAMPOS
HOUSE REPAIRS & SMALL REMODELING
ADDRESS: 741 WINDING RD. PASADENA TX. 77504
INTERNATIONAL RESIDENTIAL CODE 2012 DETAILS

Revisions table with columns for revision number, date, and description.

Date: 09/10/21
Drawn: PM
Approved:
Cadd File No: 2021_JOBS/MTZ
C.O.H. JOB NO: Project No: 21044

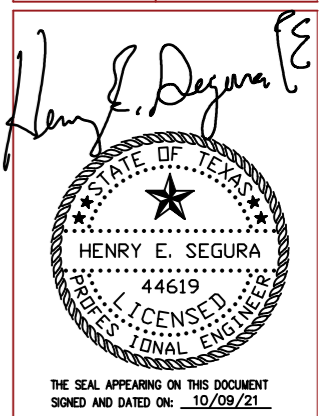

ALYSSUM BUILDING CONSULTANTS LLC
TEX ENGR. FIRM 13975
Sheet Title: IRC - 2012
G.002

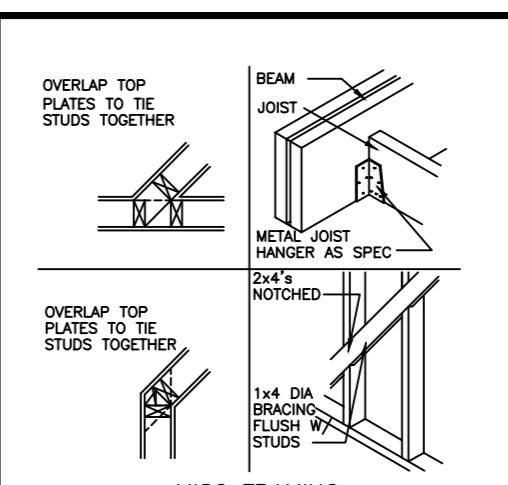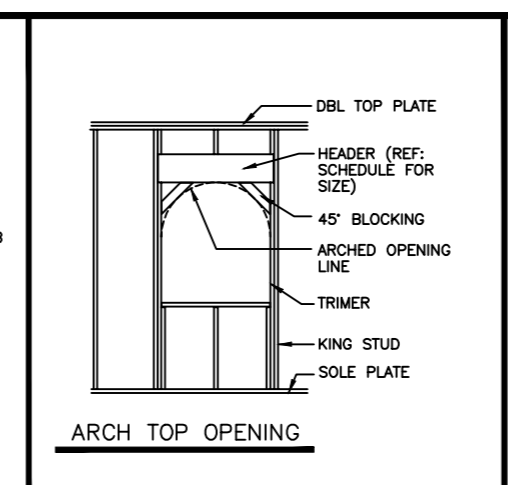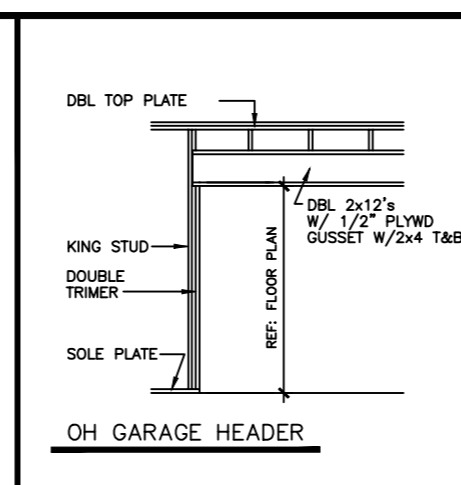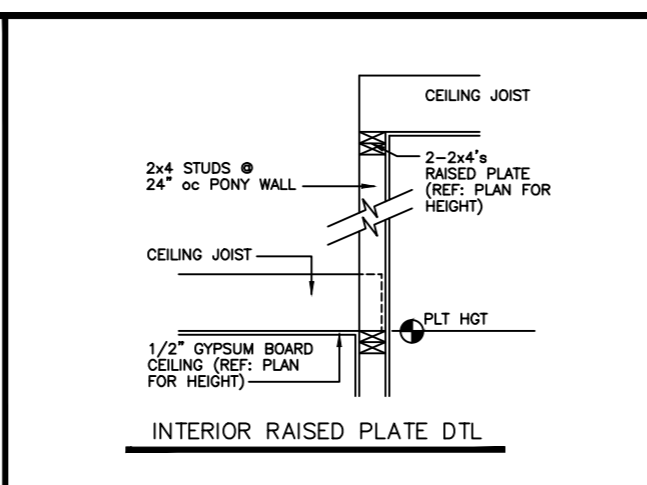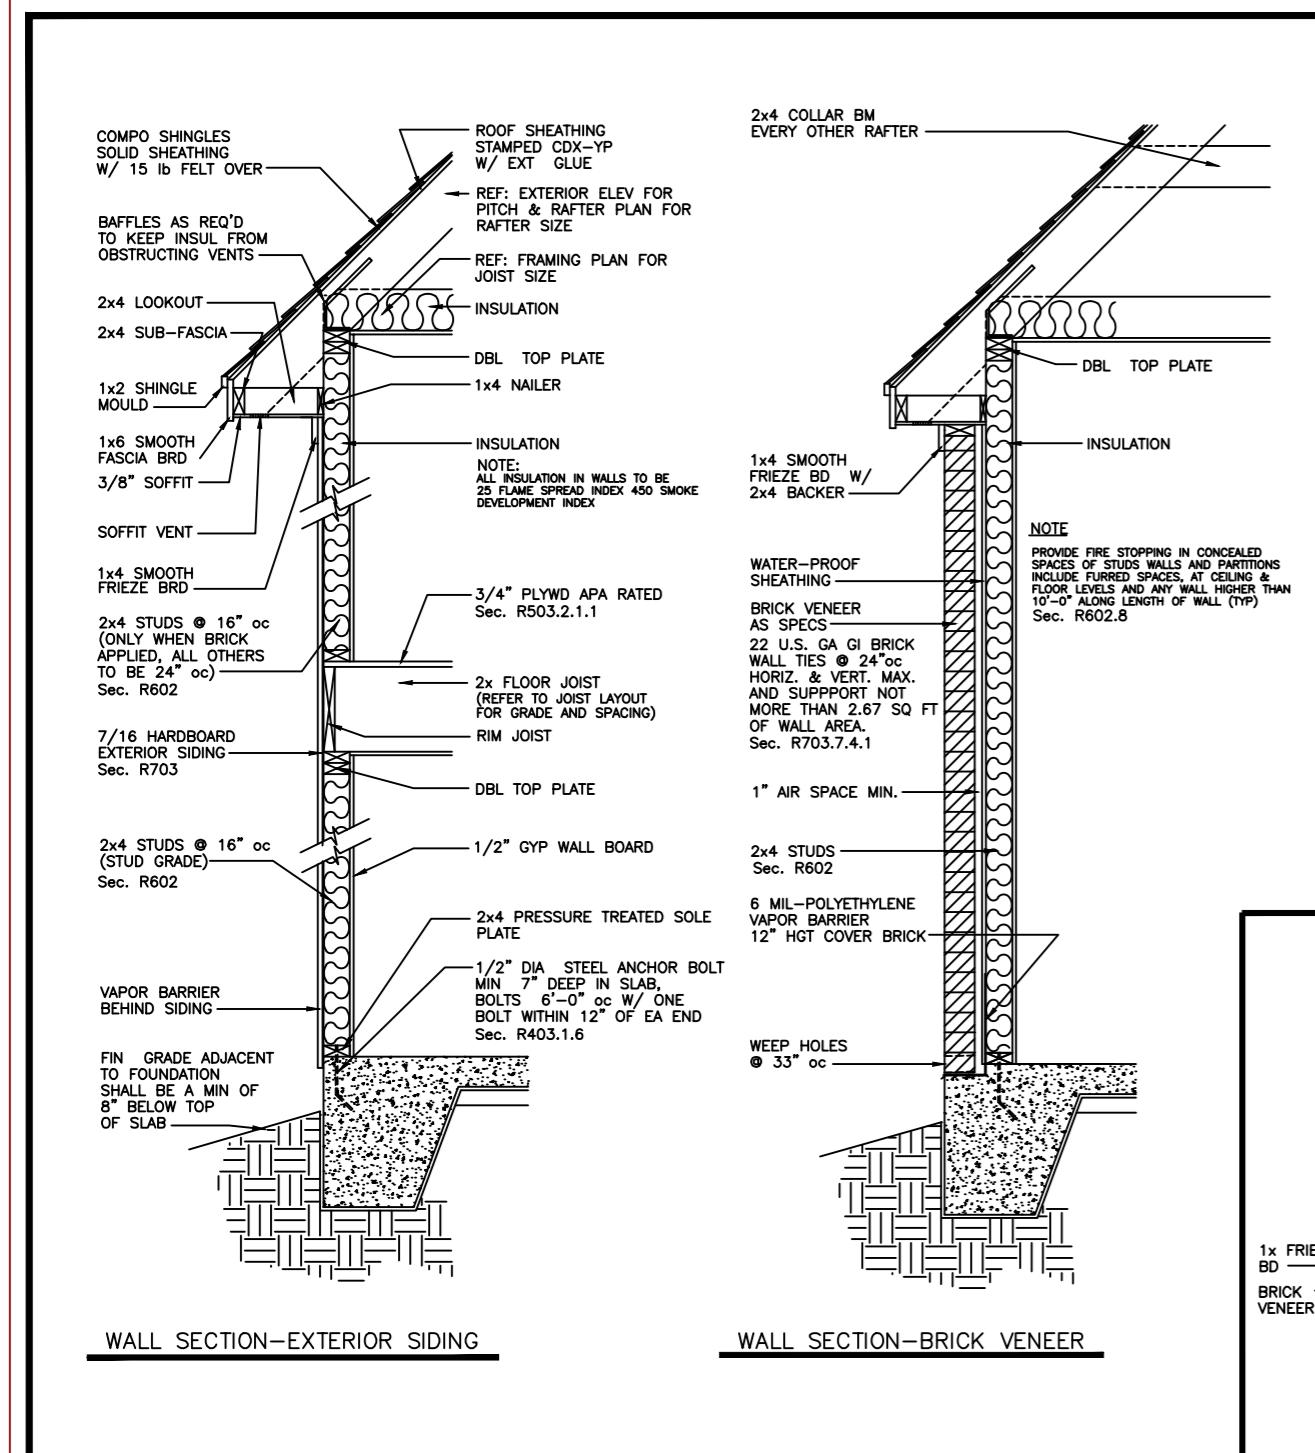

LEGEND: Symbols for electrical and plumbing fixtures. Includes STANDARD SWITCH, 3 WAY SWITCH, 4 WAY SWITCH, SWITCH WITH DIMMER, STANDARD OUTLET, 12" A F F (U N O), 220 OUTLET, UTILITY, HALF HOT OUTLET, GROUND FAULT CIRCUIT INTERRUPTOR, GROUND FAULT CIRCUIT INTERRUPTOR WATER PROOFING, HANGING FIXTURE/BLOCK, RECESS CAN LIGHT, RECESS EYE BALL, INCANDESCENT LIGHT, WALL MOUNTED LIGHT, FLUORESCENT LIGHT (REF: DRAWINGS FOR SIZE), TELEPHONE SHOWER HEAD, CABLE TV OUTLET, CHIMES (DOOR BELL), DOOR BELL, SMOKE DETECTOR, EXHAUST FAN (50 CFM), GAS, CEILING FAN W/ LIGHT, CEILING FAN W/ LIGHT, RETURN AIR, DISAPPEARING STAIRS, MEDICINE CABINET, HOSE BIBB (COLD WATER), WATER OUTLETS (COLD AND HOT), CHANGE ON FLOOR MATERIAL, SEE DETAIL.

FRAME ABBREVIATIONS table listing materials like SYP, RO, BRD, PLV, etc. and their uses.

WINDOW/DOOR ABBREVIATIONS table listing window types like H S, S V P, D V P, etc.

TRIM ABBREVIATIONS table listing trim types like IRIS, SHT, SHT, etc.

SELECTION ABBREVIATIONS table listing material selections like C T, S V Y, etc.

APPLIANCES ABBREVIATIONS table listing appliance symbols like D W, DISP, etc.

HEADERS IN BEARING WALLS table with columns for header size, span, and wall type.

STEEL LINTEL SCHEDULE table with columns for size, angle, and number of bolts.

