

**h OFFICE OF  
 design**



DATE: 06/16/22

THESE DRAWINGS AND SPECIFICATIONS AS INSTRUMENTS OF SERVICE ARE AND SHALL REMAIN THE PROPERTY OF H OFFICE OF DESIGN, LLC. THEY ARE NOT TO BE USED ON OTHER PROJECTS OR EXTENSION TO THIS PROJECT WITHOUT EXPRESS WRITTEN CONSENT FROM H OFFICE OF DESIGN, LLC.  
 ©2020 H Office Of Design, PLLC

247 JULIA ST.  
 HOUSTON, TX  
 77022


PROJECT NUMBER: 22039195

ISSUES/REVISIONS:  
 6/15/22 FOR REGULATORY APPROVAL  
 6/15/22 COH Revisions


SHEET TITLE:  
**FLOORPLAN - LEVEL 2**

SHEET:

**A2.12**

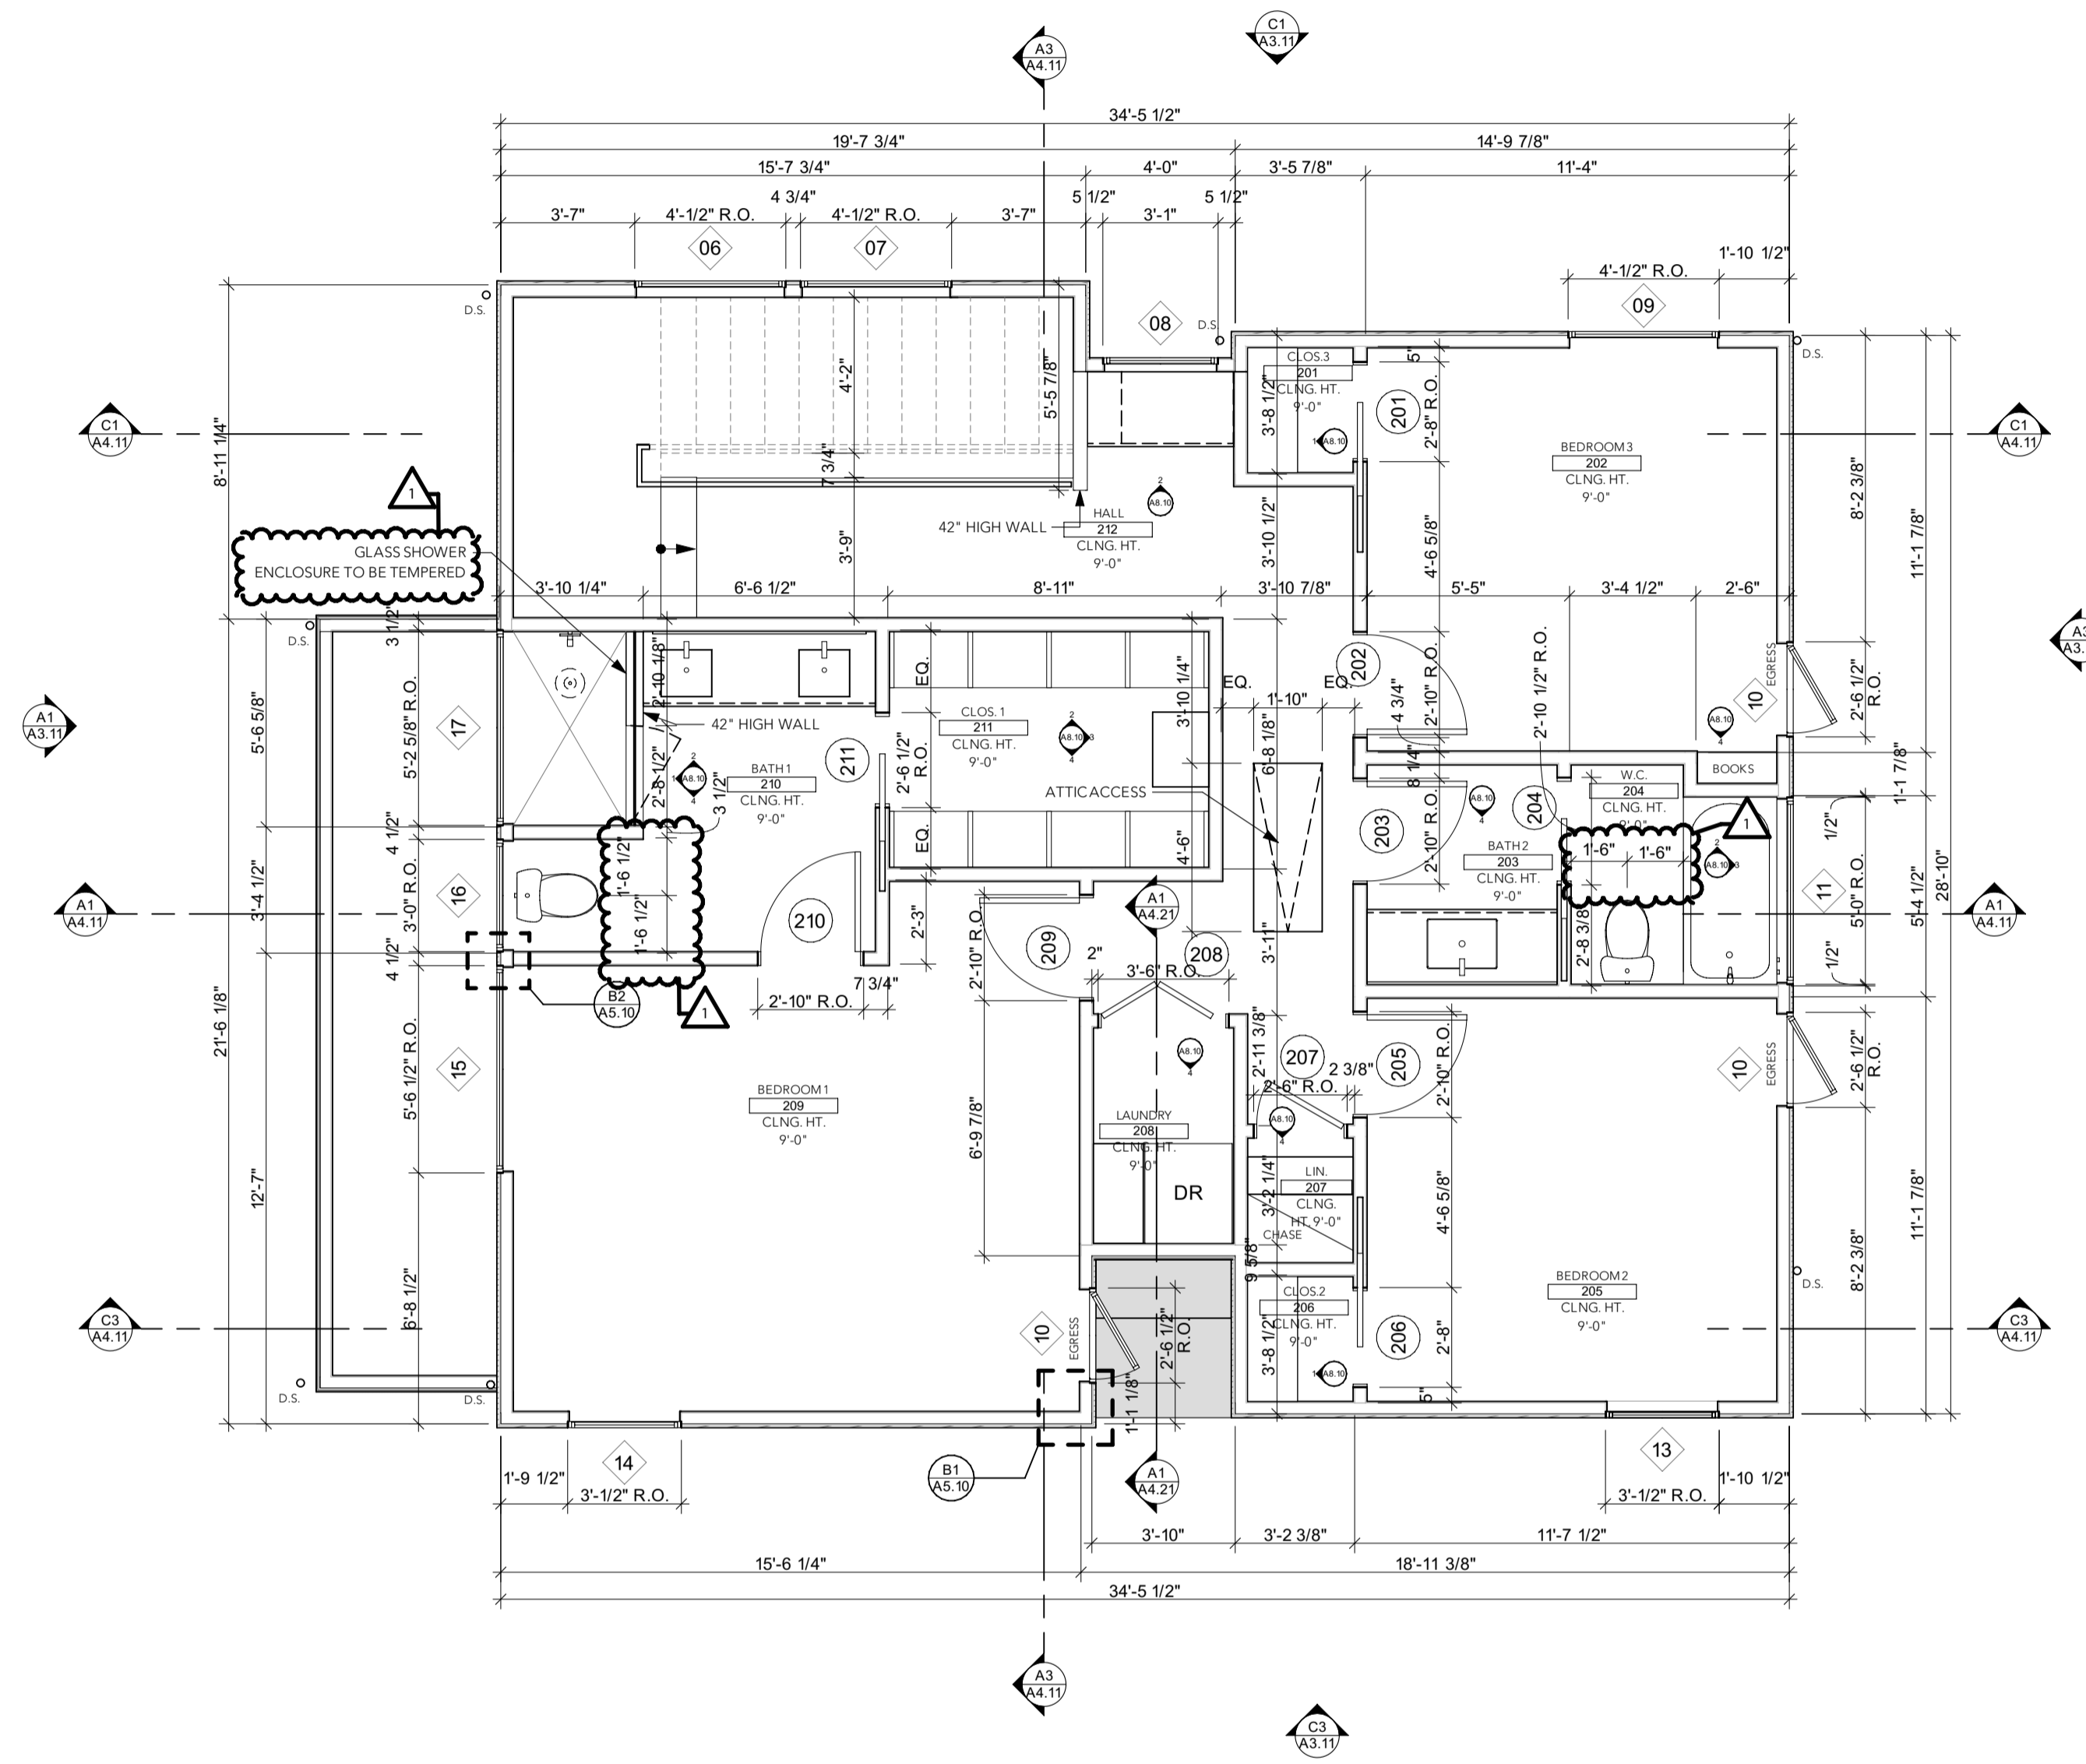

**B2 2ND FLOOR PLAN**  
 SCALE: 1/4" = 1'-0"

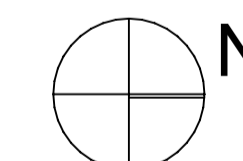

GENERAL NOTES	HANDRAIL NOTES	GUARD RAIL NOTES
<ul style="list-style-type: none"> <li>SEE DOOR SCHEDULES FOR DOOR AND DOOR FRAMING DETAILS. SEE SPECIFICATIONS FOR MATERIALS AND FINISHES.</li> <li>SEE WINDOW SCHEDULES FOR WINDOW AND WINDOW FRAMING DETAILS. SEE SPECIFICATIONS FOR MATERIALS AND FINISHES.</li> <li>SEE SPECIFICATIONS FOR ALL PLUMBING FIXTURES AND APPLIANCES.</li> <li>SEE INTERIOR ELEVATIONS, ROOM FINISH SCHEDULE, AND SPECIFICATIONS FOR ALL INTERIOR FINISH MATERIALS AND FINISHES, AND ALL CABINETS, COUNTER TOPS, AND FINISHES.</li> <li>SEE EXTERIOR ELEVATIONS AND SPECIFICATIONS FOR EXTERIOR MATERIALS AND FINISHES.</li> </ul>	<ul style="list-style-type: none"> <li>HANDRAILS MUST HAVE A MIN. HEIGHT OF 34 INCHES AND A MAX. HEIGHT OF 38 INCHES, MEASURED VERTICALLY FROM THE NOSING OF THE TREADS, AND SHALL BE PROVIDED ON AT LEAST ONE SIDE OF THE STAIRWAYS. ALL REQUIRED HANDRAILS SHALL BE CONTINUOUS THE FULL LENGTH OF THE STAIRS WITH TWO OR MORE RISERS FROM A POINT DIRECTLY ABOVE THE TOP RISER OF A FLIGHT TO A POINT DIRECTLY ABOVE THE LOWEST RISER OF THE FLIGHT. ENDS SHALL BE RETURNED, OR SHALL TERMINATE IN NEVEL POSTS OR SAFETY TERMINALS. HANDRAILS ADJACENT TO A WALL SHALL HAVE A SPACE OF NOT LESS THAN 1 1/2 INCHES BETWEEN THE WALL AND THE HANDRAIL.</li> </ul>	<ul style="list-style-type: none"> <li>PORCHES, BALCONIES OR RAISED FLOOR SURFACES LOCATED MORE THAN 30 INCHES ABOVE THE FLOOR OR GRADE BELOW SHALL HAVE GUARDS NOT LESS THAN 36 INCHES IN HEIGHT. OPEN SIDES OF STAIRS WITH A TOTAL RISE OF MORE THAN 30 INCHES ABOVE THE FLOOR OR GRADE BELOW SHALL HAVE GUARDS NOT LESS THAN 34 INCHES IN HEIGHT MEASURED VERTICALLY FROM THE NOSING OF THE TREADS. REQUIRED GUARDS SHALL HAVE INTERMEDIATE RAILS OR ORNAMENTAL CLOSURES THAT DO NOT ALLOW PASSAGE OF A SPHERE OF 4 INCHES IN DIAMETER. REQUIRED GUARDS SHALL NOT BE CONSTRUCTED WITH HORIZONTAL RAILS OR OTHER ORNAMENTAL PATTERN THAT WILL RESULT IN A LADDER EFFECT. GUARD AND HANDRAIL TO BE DESIGNED AND INSTALLED TO RESIST A 200 LB CONCENTRATED LOAD APPLIED IN ANY DIRECTION AT ANY POINT ALONG THE TOP.</li> </ul>