




ELECTRICAL LEGEND	
	CAN LIGHT
	DIRECTIONAL LIGHT
	HANGING LIGHT
	CEILING LIGHT
	WALL MOUNT FIXTURE
	UNDER CAB LIGHT
	SWITCH
	PHONE
	TV
	110 V OUTLET
	220 V OUTLET
	FLUORESCENT LIGHT
	DOUBLE FLOOD LIGHT
	EXHAUST FAN
	SMOKE ALARM
	DOOR BELL
	CHIMES
	HOSE BIB
	GAS BIB
	CEILING FAN

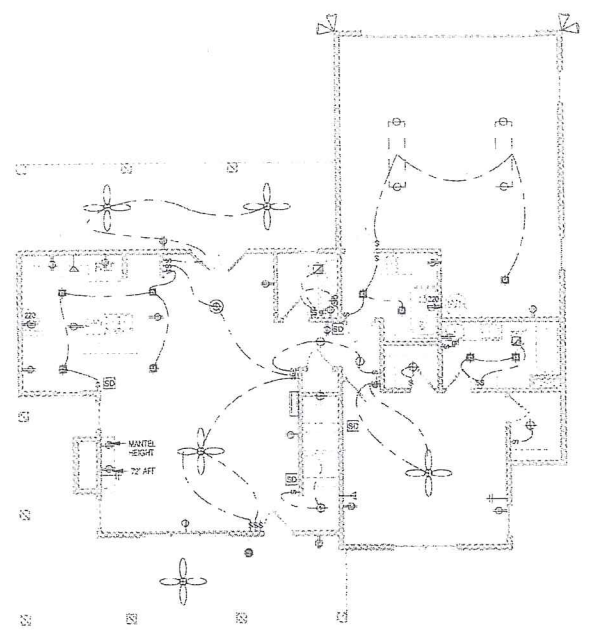


③ FIRST FLOOR - ELECTRICAL PLAN
1/8" = 1'-0"

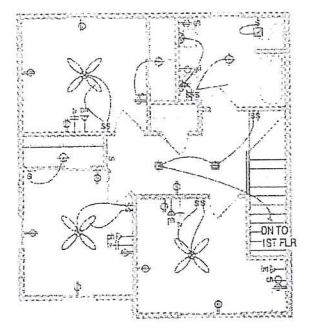

④ SECOND FLOOR - ELECTRICAL PLAN
1/8" = 1'-0"

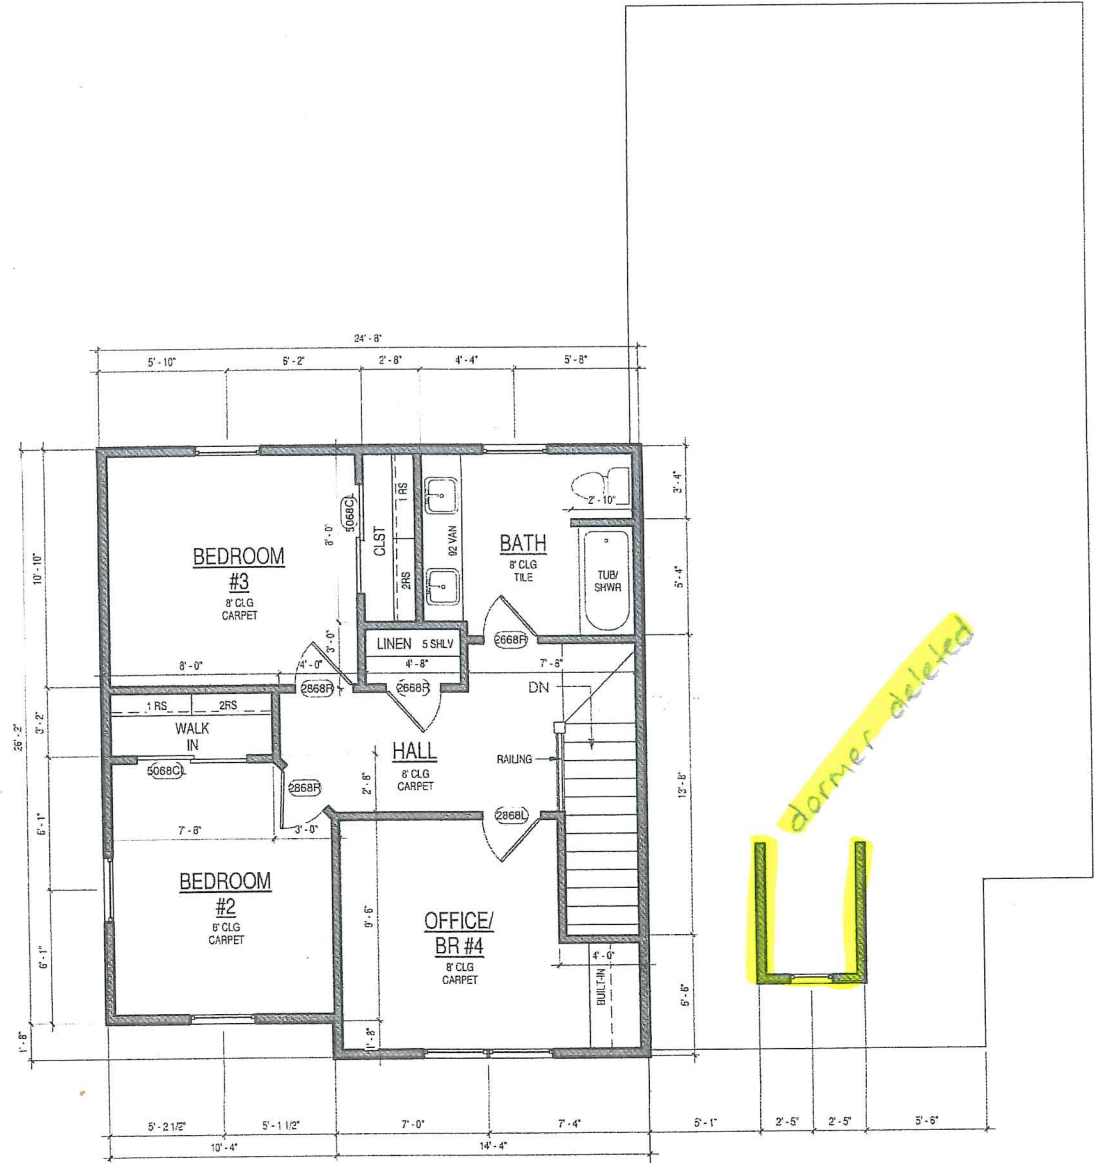

② SECOND FLOOR - PLAN
1/4" = 1'-0"

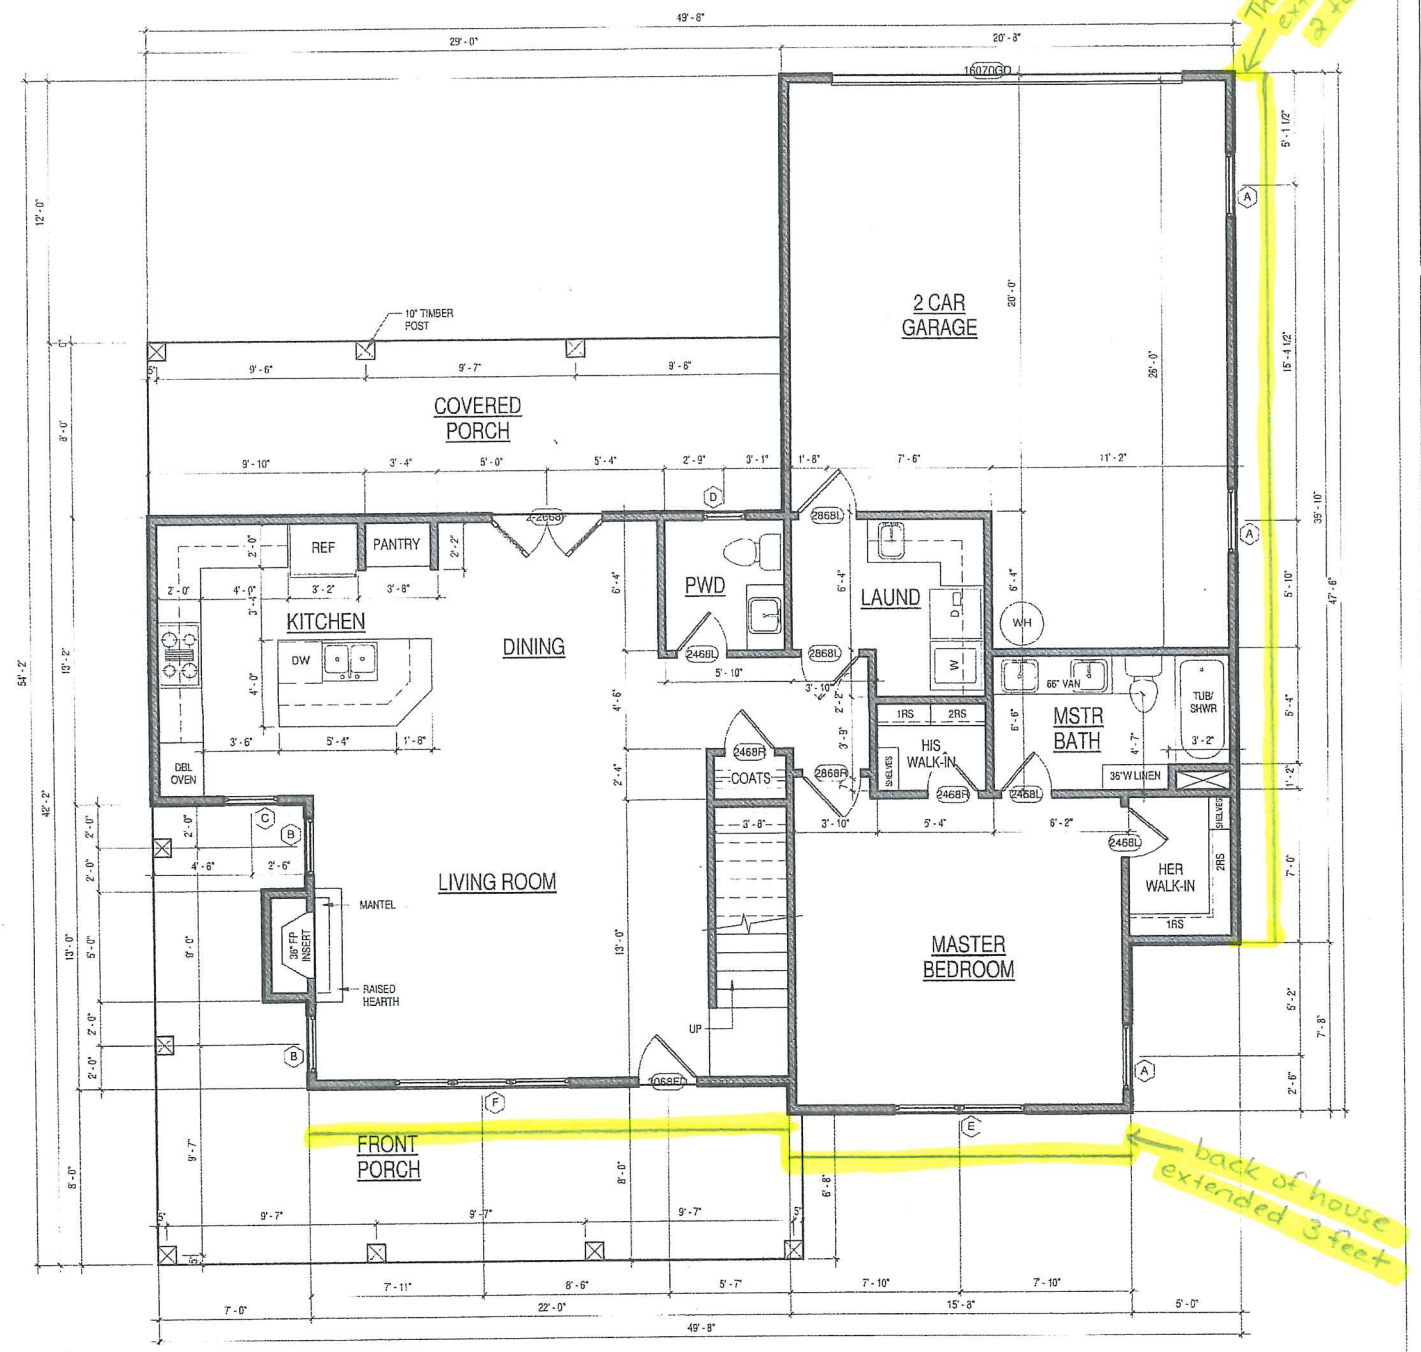

① FIRST FLOOR - PLAN
1/4" = 1'-0"

RW MARTIN
HOME PLANS & DESIGN
(256) 679-9951 / (972) 249-8623
bobby@rwmartinplans.com

© 2015, all rights reserved
All ideas, designs, arrangements, & plans indicated or represented by this drawing are the property of RW Martin Plans & Design. No part of this drawing may be reproduced, stored in a retrieval system, or transmitted in any form or by any means, including but not limited to: electronic, mechanical, photocopying, recording, or by any information storage and retrieval system, without the prior written permission of RW Martin Plans & Design. This drawing is intended for the use of the contractor and is not to be used for any other purpose. When reference is made to this drawing, it shall be understood to refer to the drawings as a whole.

DESIGNERS/BUILDERS

BROWN FAMILY
FINAL FOR REVIEW
FLOOR - PLAN

Project Number: HPD2015-017
Date: APRIL 18, 2015
Drawn by: R. MARTIN
Scale: As Indicated