


1 FLOOR PLAN
SCALE: 1/4" = 1'

ABBREVIATIONS					
SH	SINGLE HUNG	EB	EYE BROW	PAN	PANTRY
DL	DIVIDED LIGHTS	PKT	POCKET	RM	ROOM
HD	HEADER	DR	DOOR	CLST	CLOSET
HT	HEIGHT	FG	FIXED GLASS	SHLVY	SHELVES
OH	OVERHEAD	OBSSG	OBSCURED GLASS	CW	COLD WATER TAP
SECT	SECTIONAL	/BTH	HALF BATH	CLG	CEILING
				MSTR	MASTER

ELECTRICAL LEGEND					
⊕	RECESSED LIGHT FIXTURE	⊖	110 V. DUPLEX RECEIPT OUTLET	⊖	DIMMER SWITCH
⊕	CEILING MOUNTED LIGHT FIXTURE	⊖FLR	110 V. FLOOR OUTLET	⊖	GARAGE DOOR OPENER
⊕	WALL MOUNT LIGHT FIXTURE	⊖GFI	GROUND FAULT INTERRUPTER DUPLEX RECEIPTABLE OUTLET	⊖PB	PUSH BUTTON GARAGE DOOR
⊖	VENT	⊖WP	WATER PROOF OUTLET	⊖DB	DOOR BELL
⊖SD	SMOKE DETECTOR	⊖S	SINGLE POLE SWITCH	⊖CH	CHIME
⊖	220 V. DUPLEX RECEIPT OUTLET	⊖S2	2 WAY SWITCH	⊖TV	TELEVISION JACK

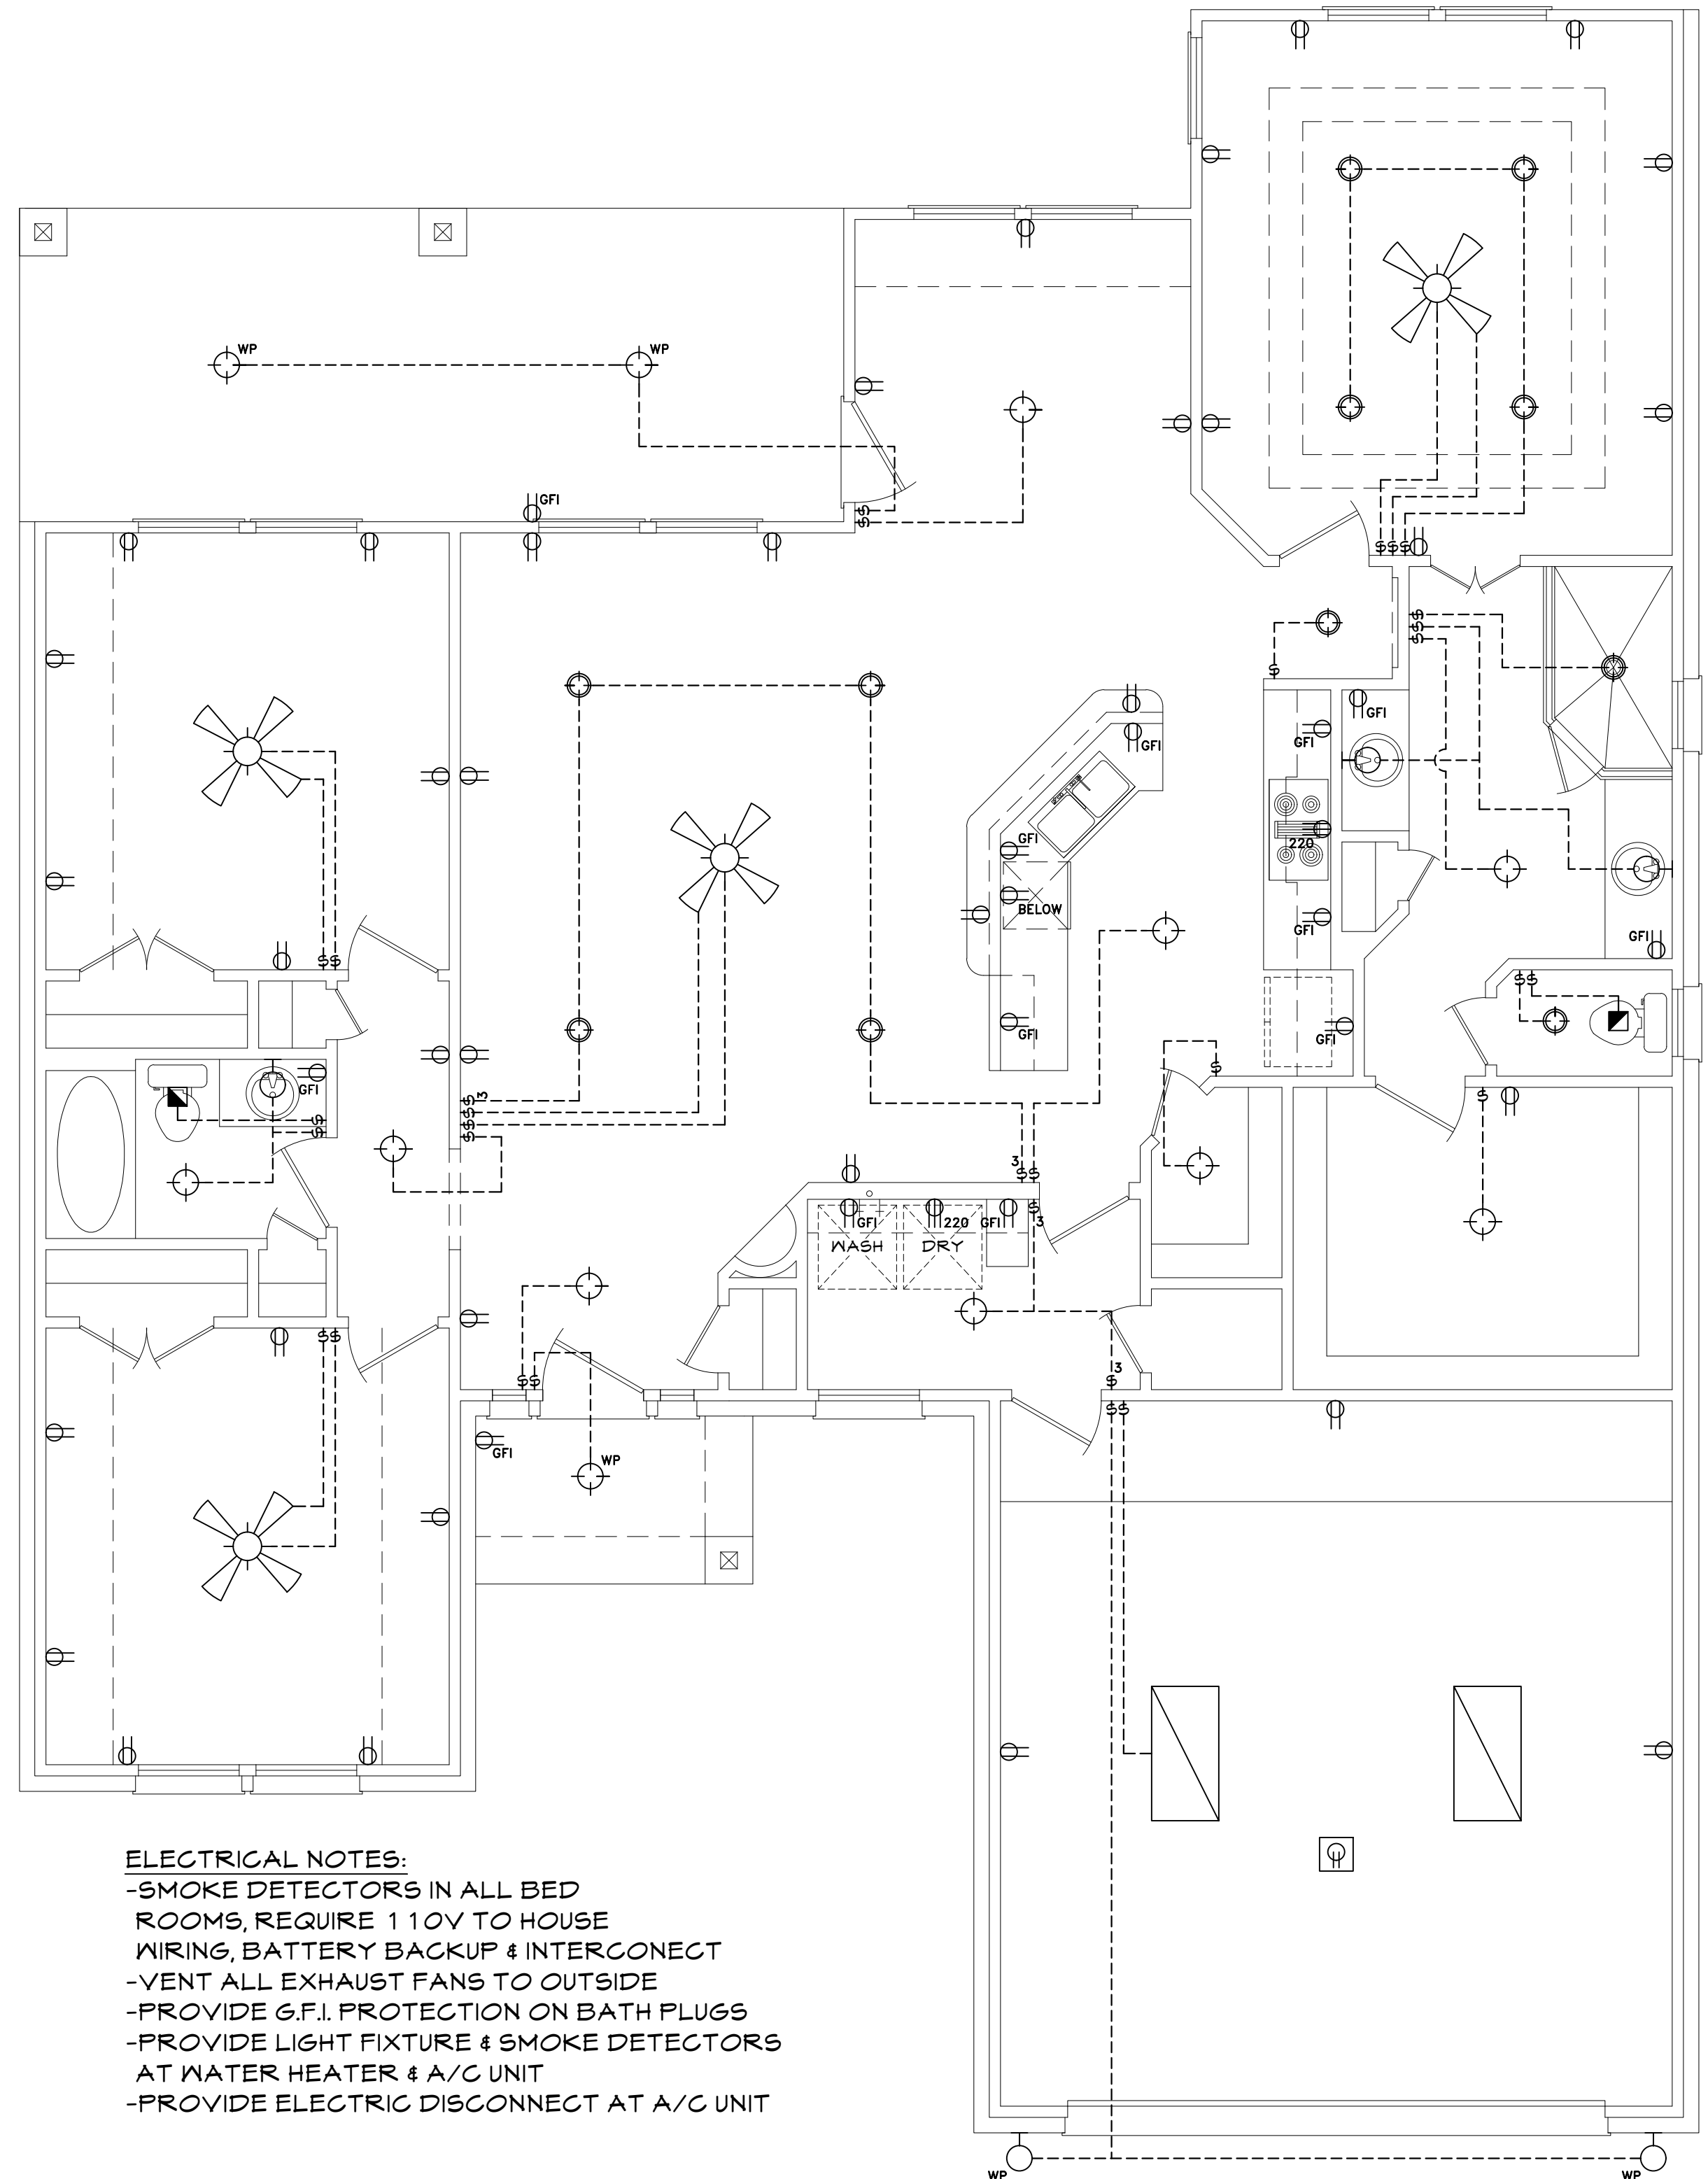

ELECTRICAL NOTES:
 -SMOKE DETECTORS IN ALL BED ROOMS, REQUIRE 110V TO HOUSE WIRING, BATTERY BACKUP & INTERCONNECT
 -VENT ALL EXHAUST FANS TO OUTSIDE
 -PROVIDE G.F.I. PROTECTION ON BATH PLUGS
 -PROVIDE LIGHT FIXTURE & SMOKE DETECTORS AT WATER HEATER & A/C UNIT
 -PROVIDE ELECTRIC DISCONNECT AT A/C UNIT

2 ELECTRICAL
SCALE: 1/4" = 1'

MOONLIGHT HOUSE PLANS IS A DRAFTING FIRM, NOT AN ENGINEERING OR ARCHITECTURAL FIRM. THESE PRINTS ARE NOT TO BE USED FOR ANY STRUCTURAL OR DESIGN MISTAKES. DIMENSIONS, DETAILS & SPECIFICATIONS. DESIGNER WILL NOT BE LIABLE FOR HUMAN ERROR AFTER CONSTRUCTION IS STARTED. THESE DRAWINGS, SPECIFICATIONS AND DECS ARE THE PROPERTY OF MOONLIGHT HOUSE PLANS, AND SHALL NOT BE REUSED, REPRODUCED, OR ALTERED IN ANY WAY.

Moonlight House Plans
979-482-1967

LIVING: 1800 SQ.FT.
GARAGE: 469 SQ.FT.
PORCH: 41 SQ.FT.
COV PATIO: 229 SQ.FT.
TOTAL: 2539 SQ.FT.

DWG. SCALE: 1/4" = 1'-0"

FLOOR PLAN
PLAN 1800
PLAN 1800-A
JOB #: 20152854

01-21-16

A3