


MOONLIGHT HOUSE PLANS

324 AZALEA, LAKE JACKSON, TX. 77566
979-482-1967

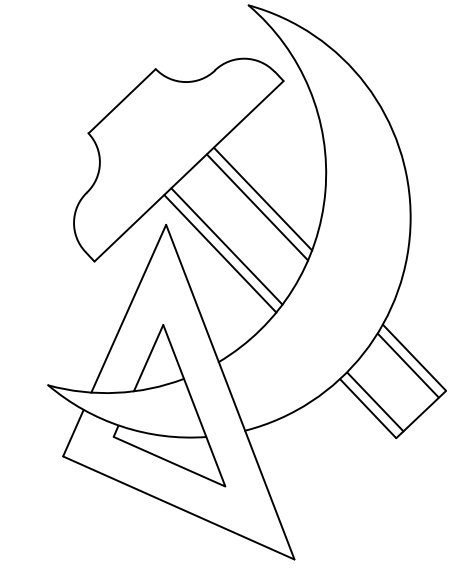

Stone - Silver Mist
Chopped

Brick - Sheltered Bluff on 3 sides in
place of Hardi

WARD

PLAN 1600 - F

PLAN#: 20212353

LIVING: 1600 SQ.FT.

GARAGE: 428 SQ.FT.

PORCH: 35 SQ.FT.


COV PATIO: 137 SQ.FT.

TOTAL: 2200 SQ.FT.


MOONLIGHT HOUSE PLANS IS A DRAFTING FIRM, NOT AN ENGINEERING, OR ARCHITECTURAL FIRM. THESE PRINTS ARE TO BE APPROVED BY A LOCAL ENGINEER FOR ALL STRUCTURAL BEINGS. MOONLIGHT HOUSE PLANS IS NOT RESPONSIBLE FOR ANY STRUCTURAL OR DESIGN MISTAKES. ALL SUBCONTRACTORS SHALL VERIFY ANY & ALL DIMENSIONS, DETAILS & SPECIFICATIONS.

DESIGNER WILL NOT BE LIABLE FOR HUMAN ERROR AFTER CONSTRUCTION IS STARTED.


THESE DRAWINGS, SPECIFICATIONS AND IDEAS ARE THE PROPERTY OF MOONLIGHT HOUSE PLANS. AND SHALL NOT BE REUSED, REPRODUCED, OR ALTERED IN ANY WAY.

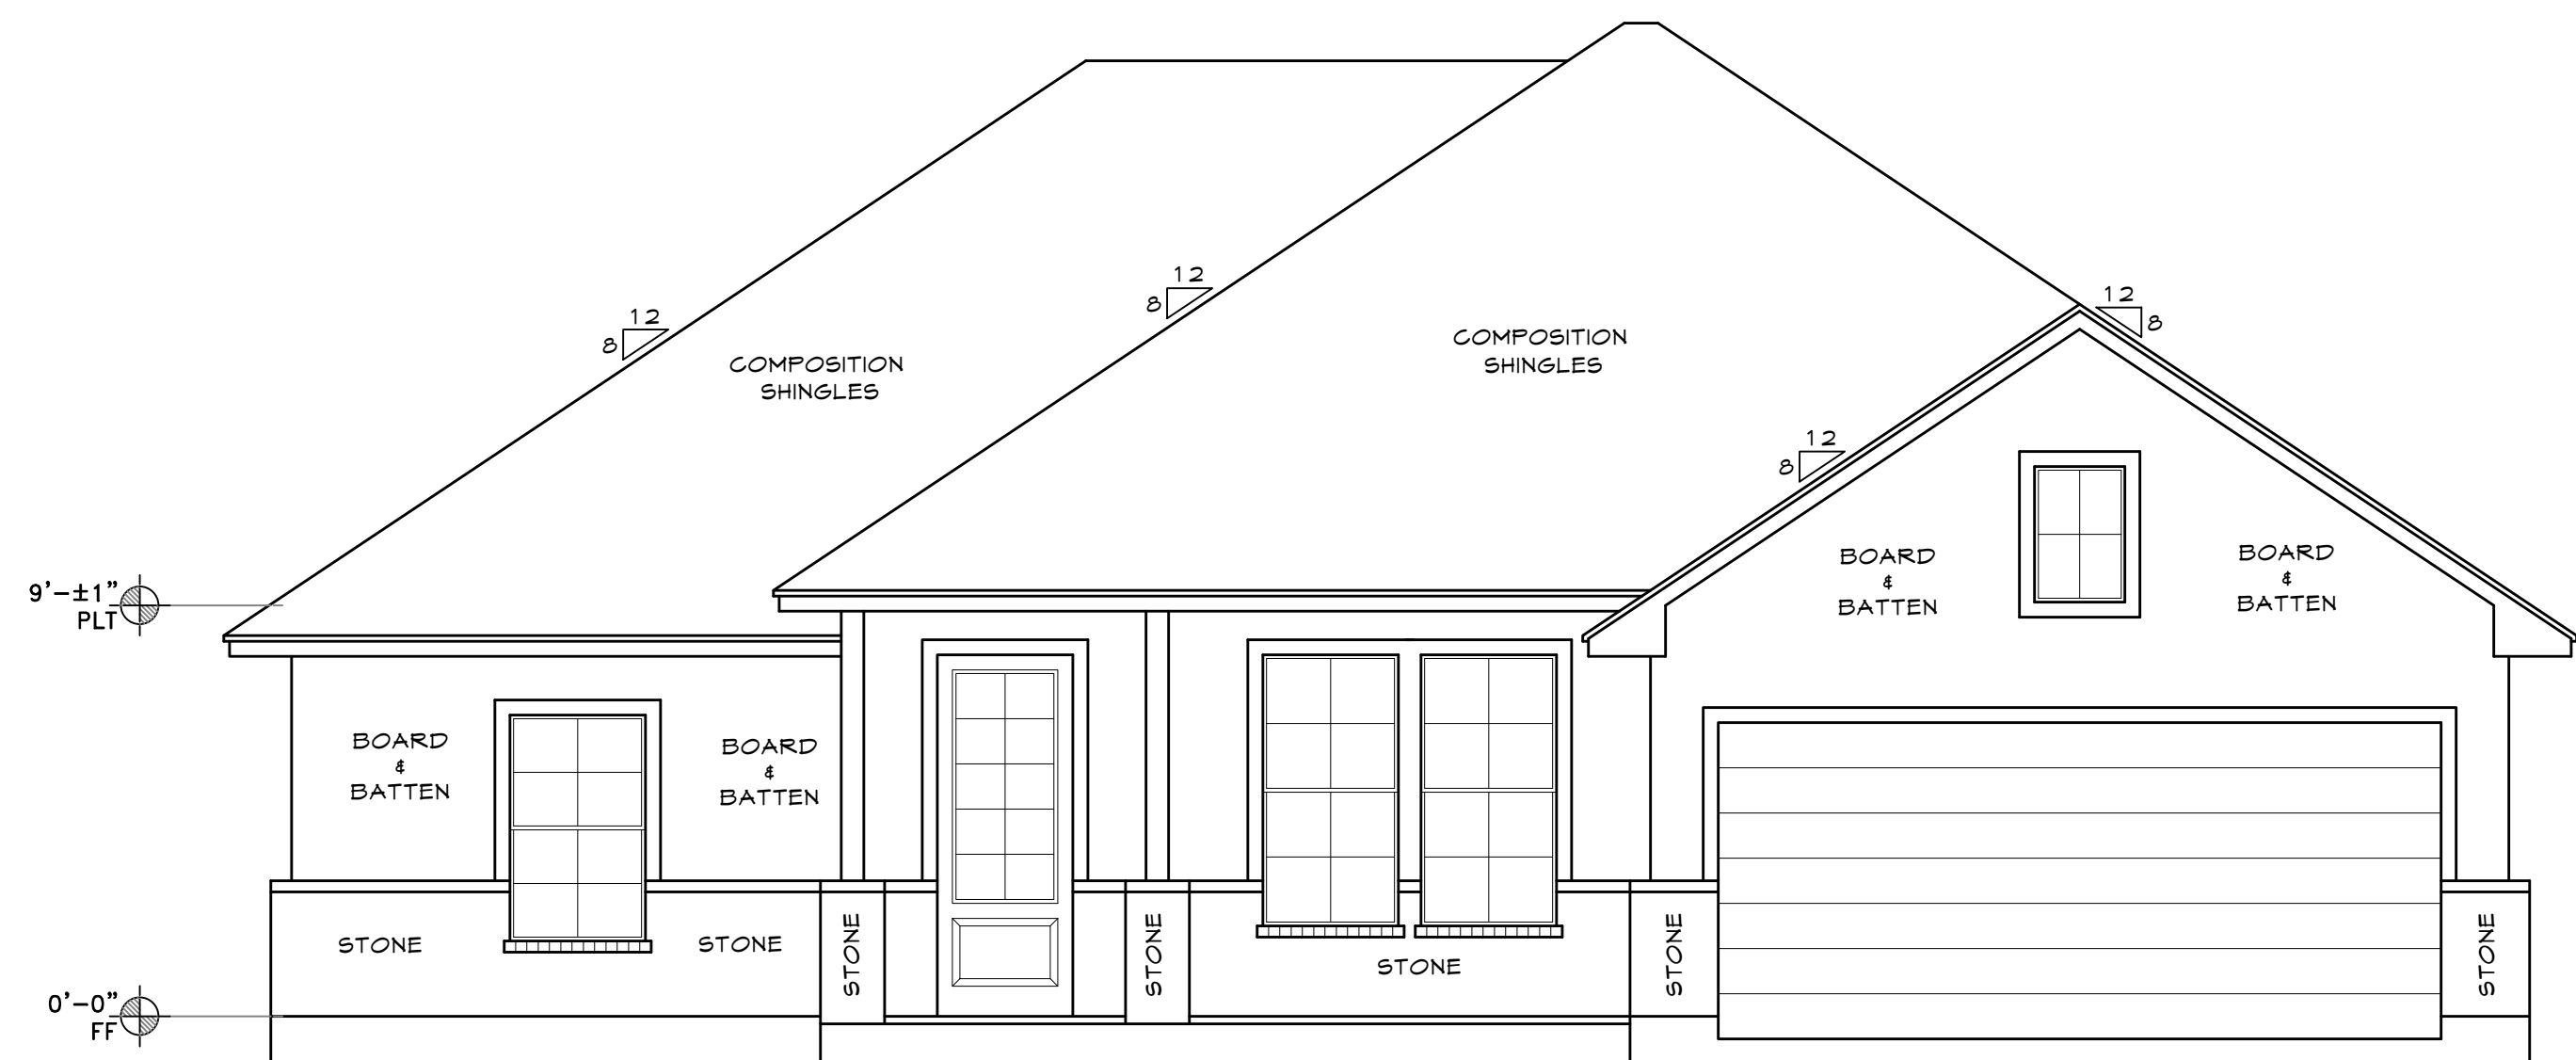


1 FRONT VIEW
A1 SCALE: 1/4" = 1'

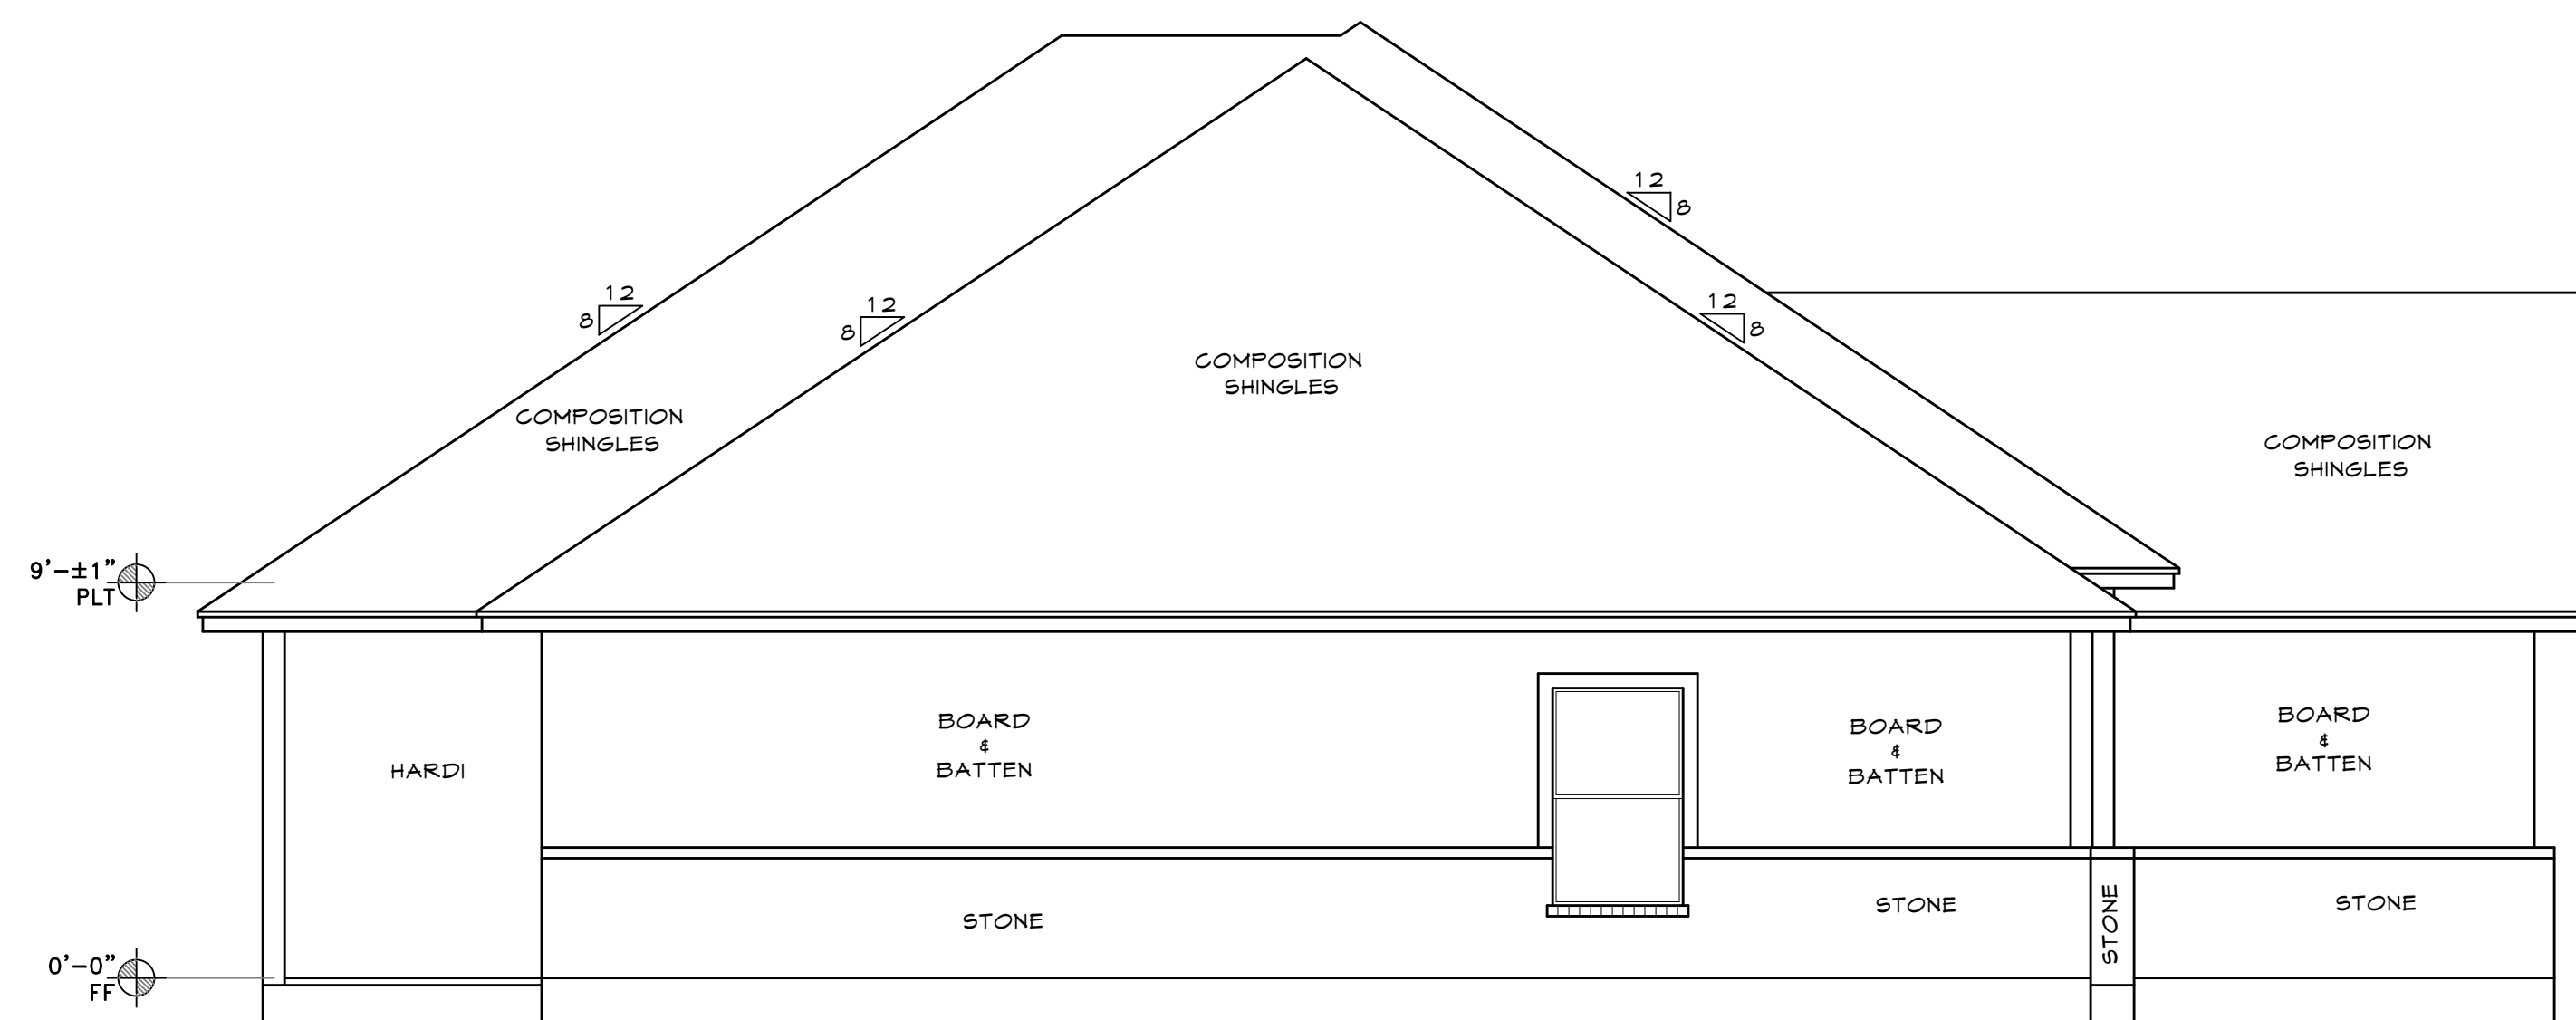

2 LEFT SIDE VIEW
A1 SCALE: 1/4" = 1'

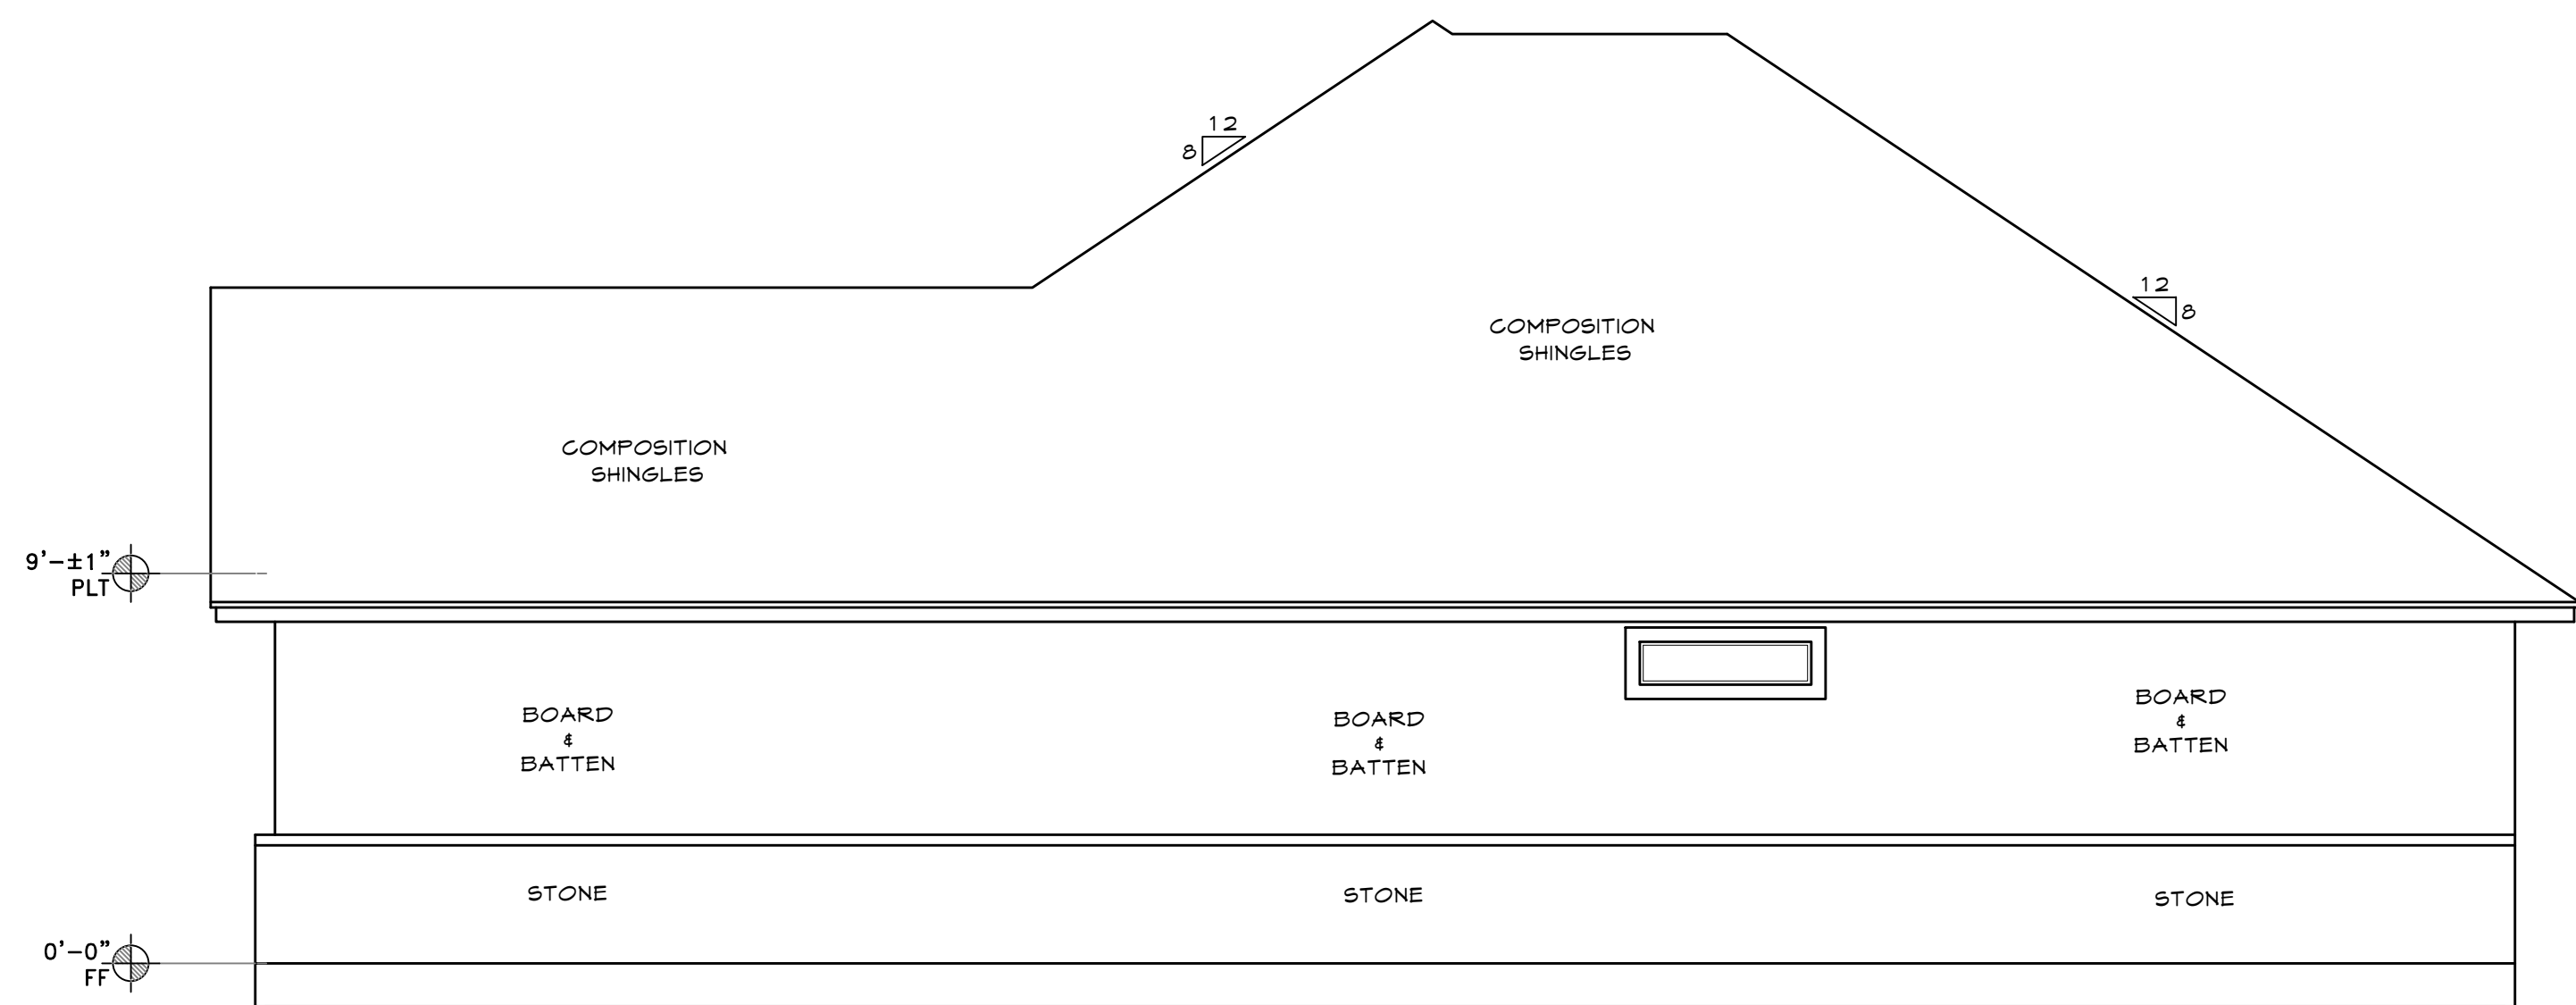

2 RIGHT SIDE VIEW
A2 SCALE: 1/4" = 1'

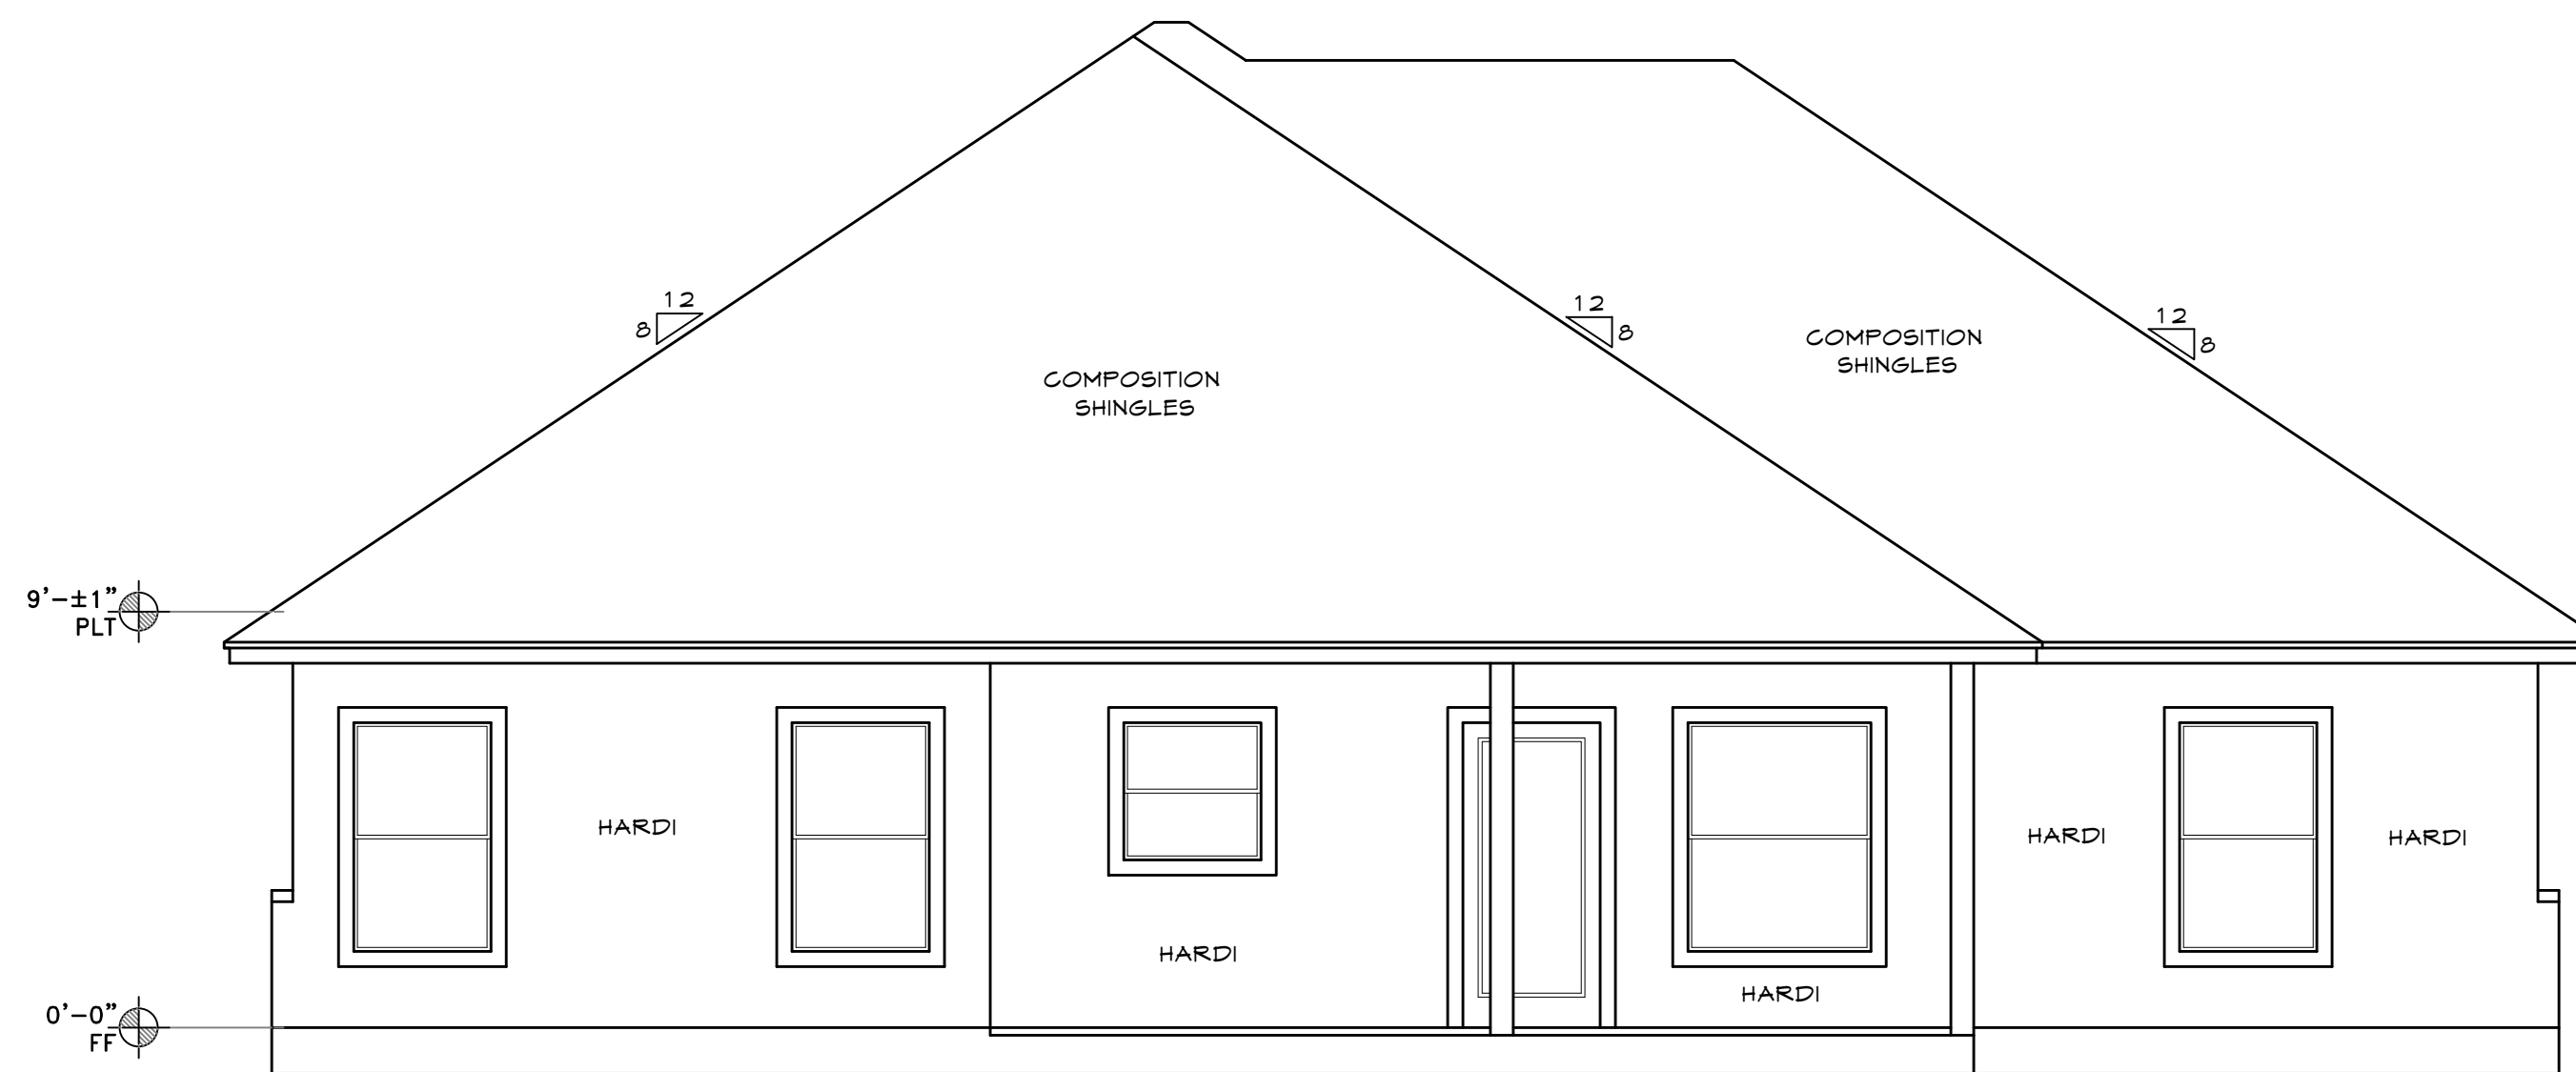

1 REAR VIEW
A2 SCALE: 1/4" = 1'

MOONLIGHT HOUSE PLANS IS A DRAFTING FIRM, NOT AN ENGINEERING OR ARCHITECTURAL FIRM. THESE PRINTS ARE NOT TO BE USED FOR CONSTRUCTION. MOONLIGHT HOUSE PLANS IS NOT RESPONSIBLE FOR ANY STRUCTURAL OR DESIGN MISTAKES, DIMENSIONS, DETAILS & SPECIFICATIONS. DESIGNER WILL NOT BE LIABLE FOR HUMAN ERRORS AFTER CONSTRUCTION IS STARTED. THESE DRAWINGS, SPECIFICATIONS AND IDEAS ARE THE PROPERTY OF MOONLIGHT HOUSE PLANS, AND SHALL NOT BE REUSED, REPRODUCED, OR ALTERED IN ANY WAY.

Moonlight House
Plans
979-482-1967


REVISION HISTORY	DATE
NUMBER	

DWG. SCALE:
1/4" = 1'-0"


ELEVATIONS
WARD
PLAN 1600-F
JOB #: 20212353

06-30-21

A2

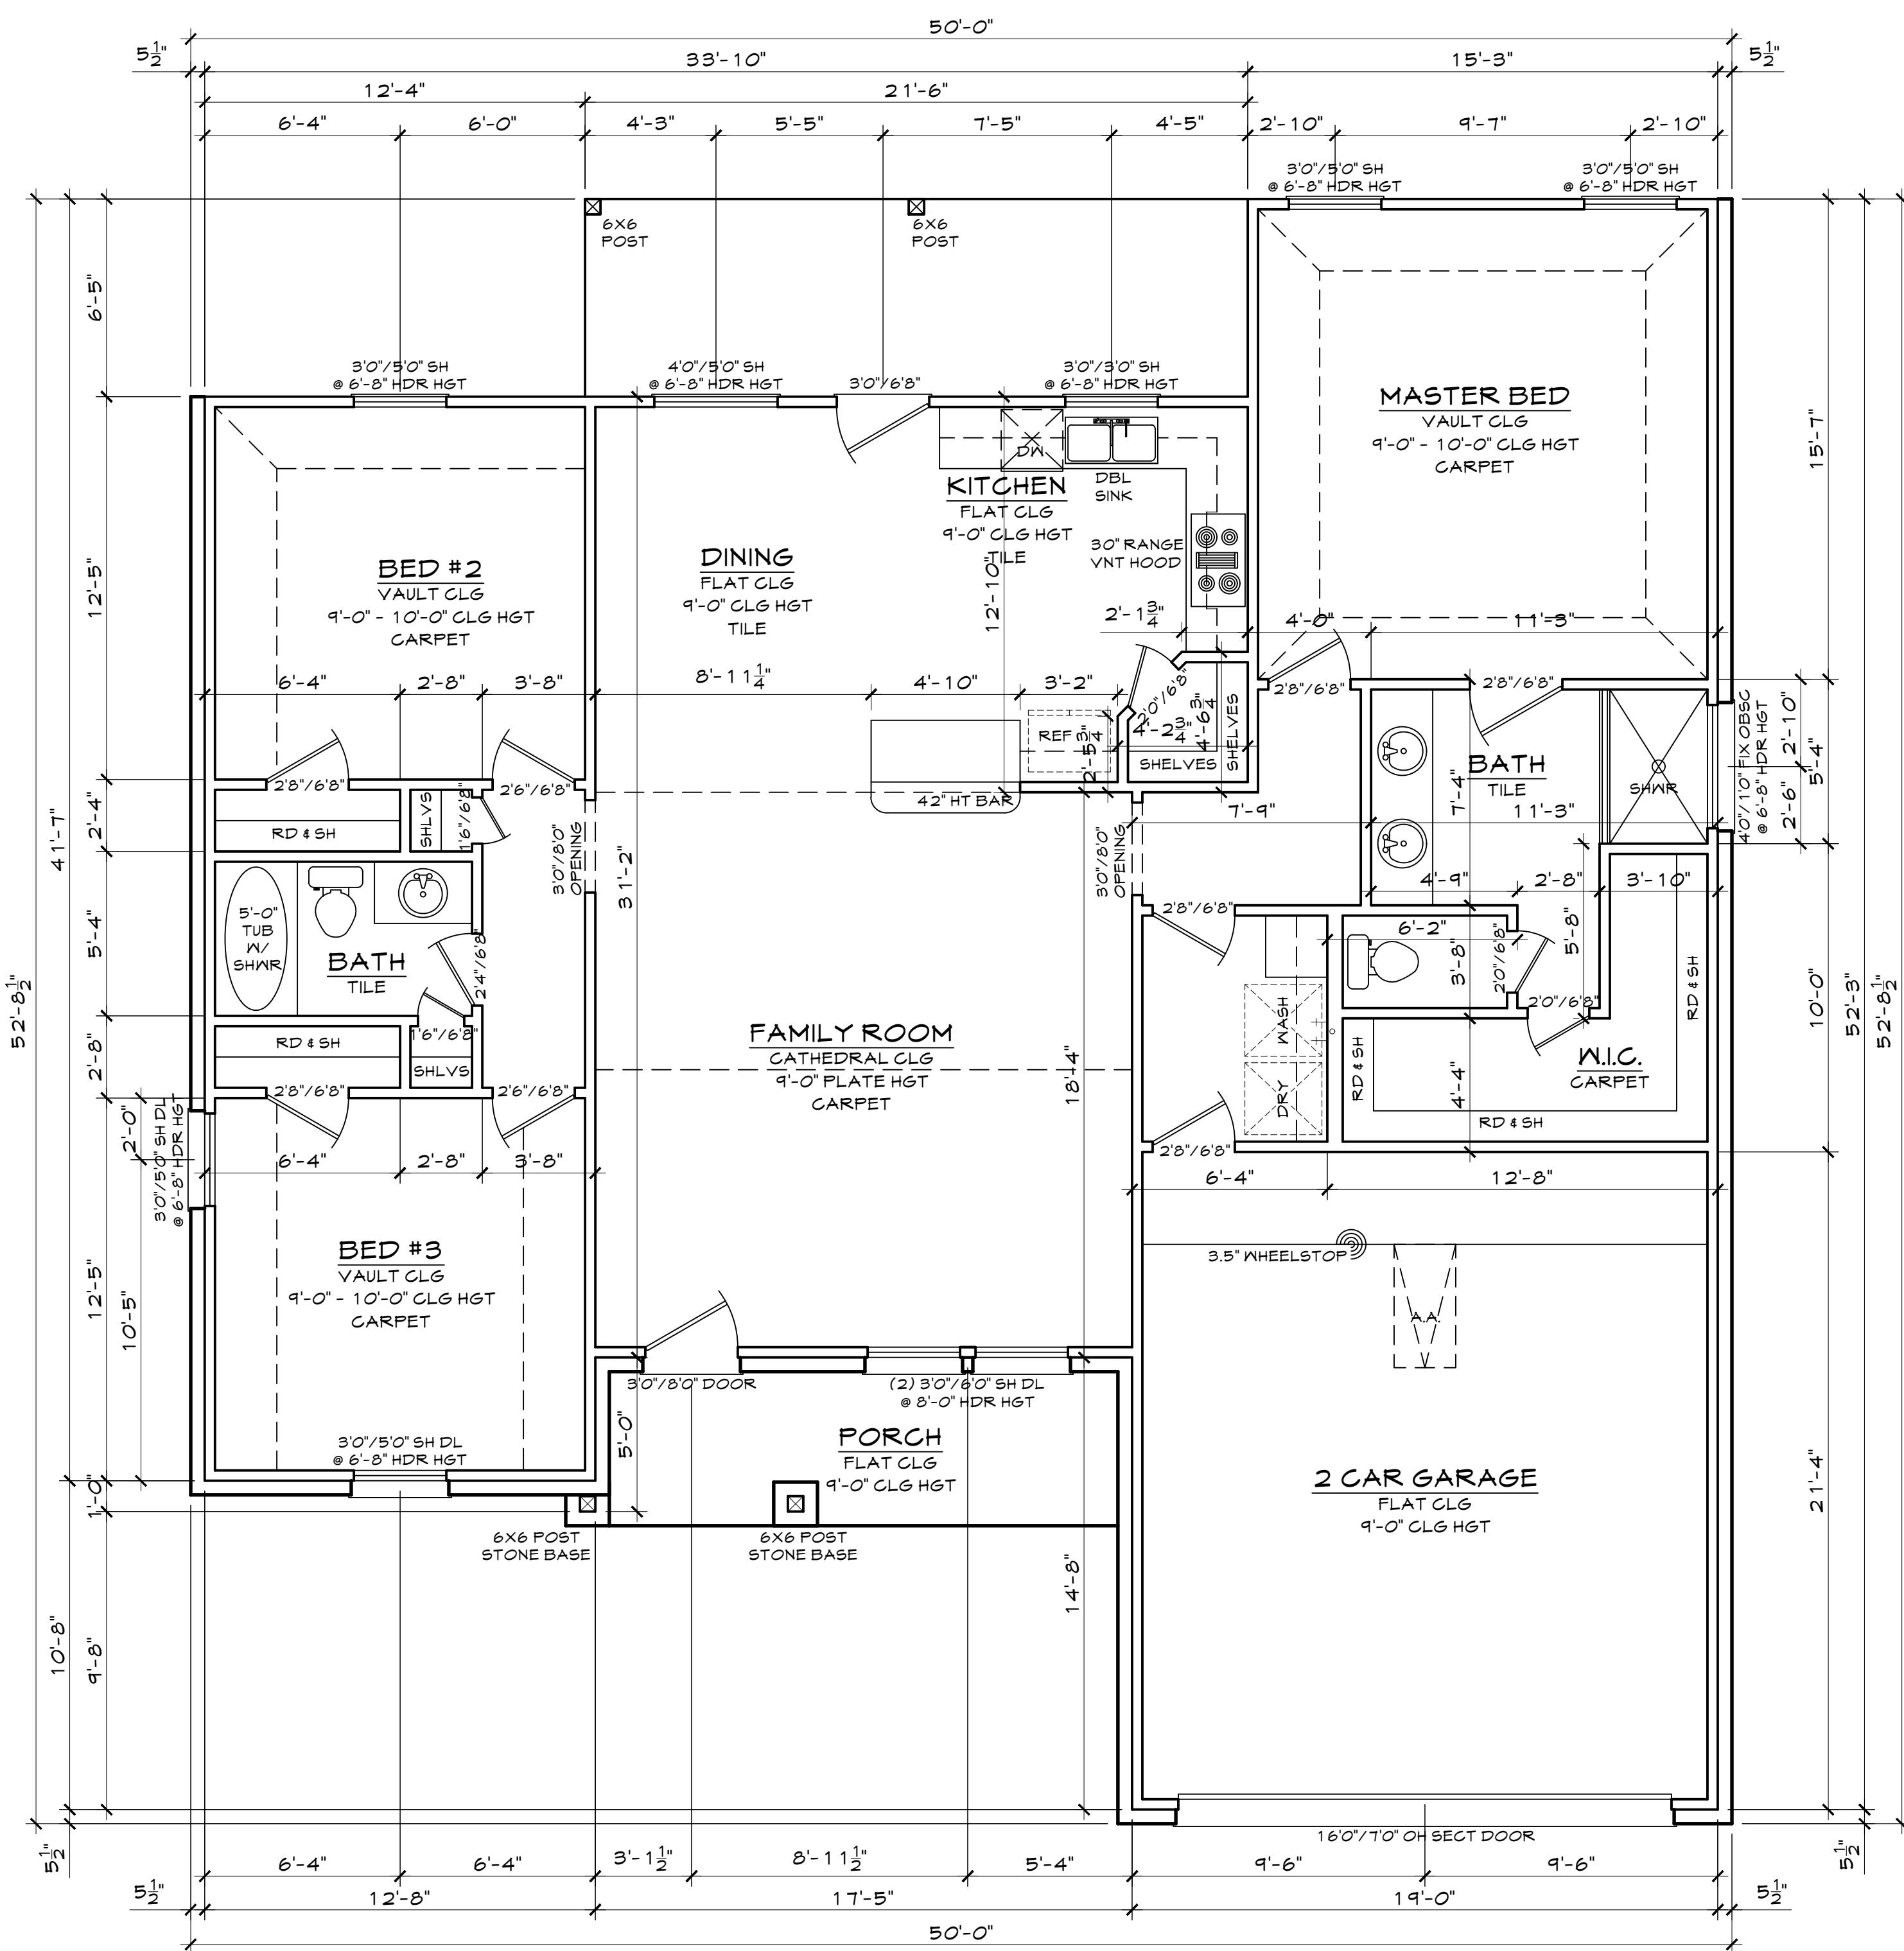

ELECTRICAL LEGEND					
SYMBOL	DESCRIPTION	SYMBOL	DESCRIPTION	SYMBOL	DESCRIPTION
⊕	RECESSED LIGHT FIXTURE	⊖	110 V. DUPLEX RECEPT OUTLET	⊖	DIMMER SWITCH
⊕	CEILING MOUNTED LIGHT FIXTURE	⊖FLR	110 V. FLOOR OUTLET	⊖	GARAGE DOOR OPENER
⊕	WALL MOUNT LIGHT FIXTURE	⊖GFI	GROUND FAULT INTERRUPTER DUPLEX RECEPTACLE OUTLET	⊖PB	PUSH BUTTON GARAGE DOOR
⊖	VENT	⊖WP	WATER PROOF OUTLET	⊖DB	DOOR BELL
⊖SD	SMOKE DETECTOR	⊖	SINGLE POLE SWITCH	⊖BP	BREAKER PANEL
⊖	220 V. DUPLEX RECEPT OUTLET	⊖S	2 WAY SWITCH	⊖TV	TELEVISION JACK

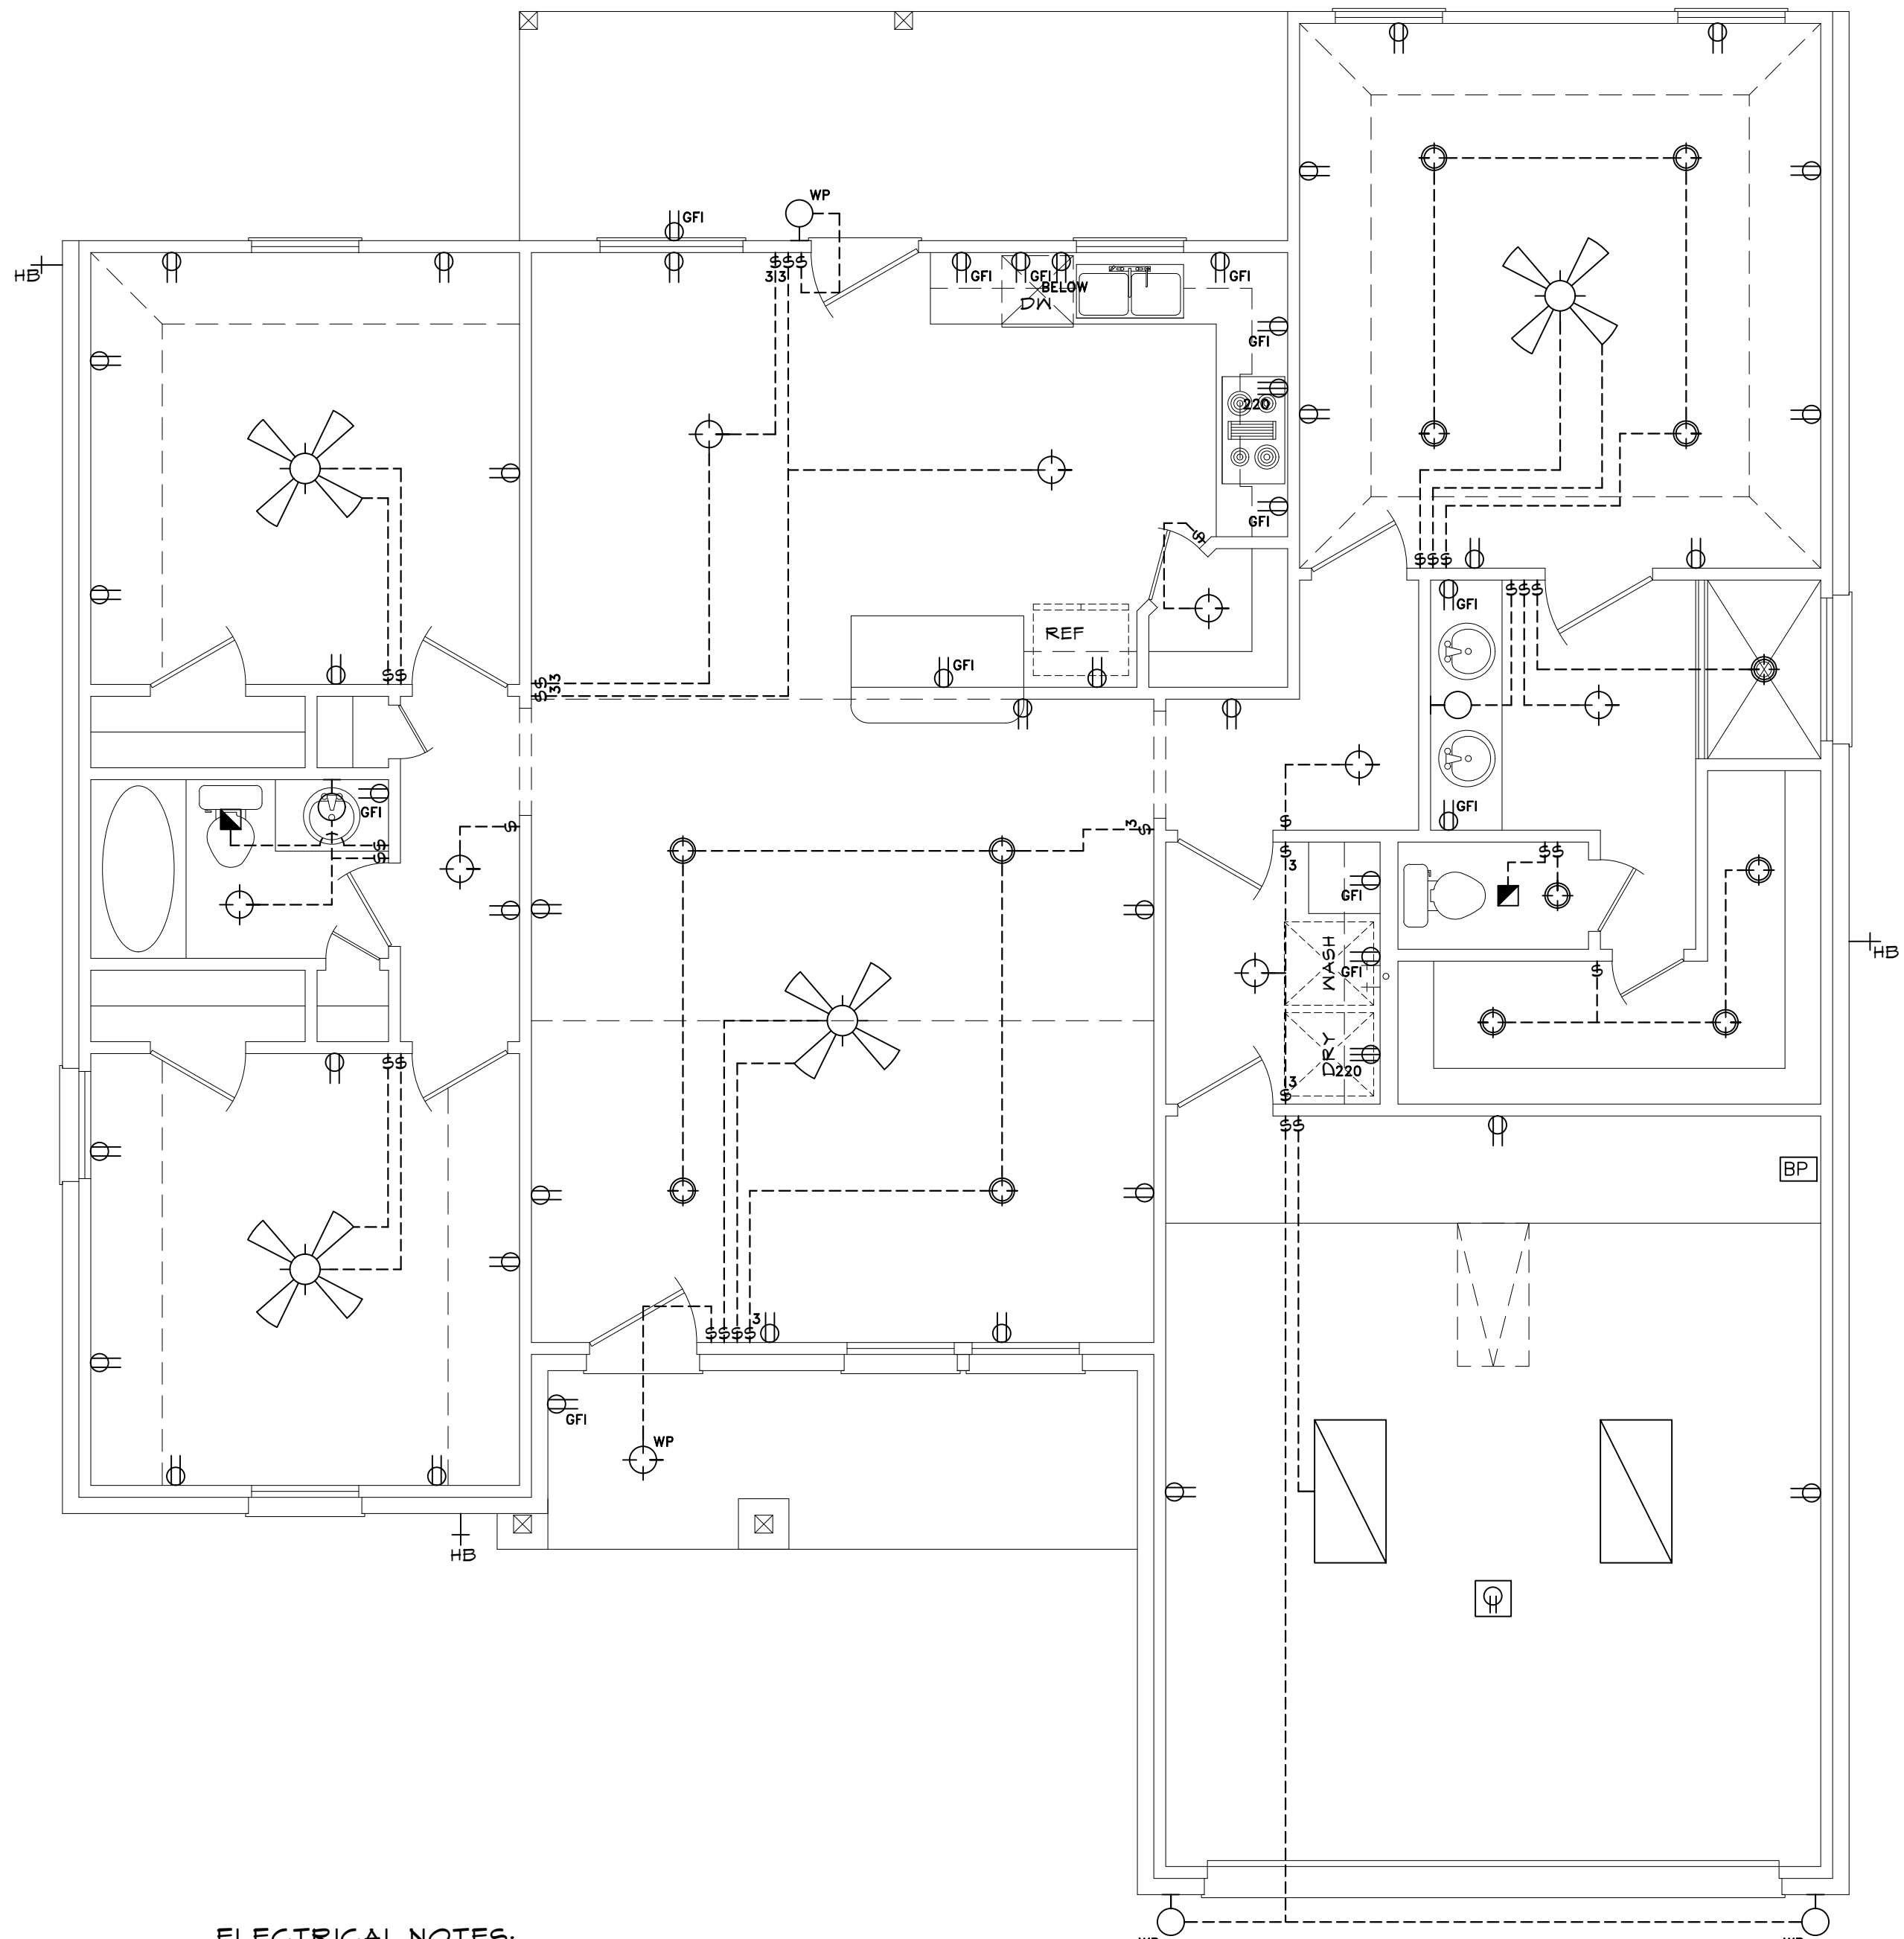

ELECTRICAL NOTES:
 -SMOKE DETECTORS IN ALL BED ROOMS, REQUIRE 110V TO HOUSE WIRING, BATTERY BACKUP & INTERCONNECT
 -VENT ALL EXHAUST FANS TO OUTSIDE
 -PROVIDE G.F.I. PROTECTION ON BATH PLUGS
 -PROVIDE LIGHT FIXTURE & SMOKE DETECTORS AT WATER HEATER & A/C UNIT
 -PROVIDE ELECTRIC DISCONNECT AT A/C UNIT

ABBREVIATIONS					
SH	SINGLE HUNG	EB	EYE BROW	PAN	PANTRY
DL	DIVIDED LIGHTS	PKT	POCKET	RM	ROOM
HD	HEADER	DR	DOOR	CLST	CLOSET
HT	HEIGHT	FG	FIXED GLASS	SHLVS	SHELVES
OH	OVERHEAD	OBSSG	OBSCURED GLASS	CW	COLD WATER TAP
SECT	SECTIONAL	/BTH	HALF BATH	CLG	CEILING
				MSTR	MASTER

1 FLOOR PLAN
 SCALE: 1/4" = 1'

2 ELECTRICAL
 SCALE: 1/4" = 1'

MOONLIGHT HOUSE PLANS IS A DRAFTING FIRM, NOT AN ENGINEERING OR ARCHITECTURAL FIRM. THESE PRINTS ARE NOT TO BE USED FOR CONSTRUCTION. MOONLIGHT HOUSE PLANS IS NOT RESPONSIBLE FOR ANY STRUCTURAL OR DESIGN MISTAKES. DIMENSIONS, DETAILS & SPECIFICATIONS.
 DESIGNER WILL NOT BE LIABLE FOR HUMAN ERROR AFTER CONSTRUCTION IS STARTED.
 THESE DRAWINGS, SPECIFICATIONS AND DECS ARE THE PROPERTY OF MOONLIGHT HOUSE PLANS, AND SHALL NOT BE REUSED, REPRODUCED, OR ALTERED IN ANY WAY.

Moonlight House Plans
 979-482-1967

REVISION HISTORY	DATE
NUMBER	

DWG. SCALE:
 1/4" = 1'-0"

FLOOR PLAN
WARD
 PLAN 1600-F
 JOB #: 20212953

06-30-21

A2