


ELECTRICAL PLAN
THIS IS AN ALL ELECTRIC HOME
ARTISAN FEATURE LEVEL
COH WINDSTORM

ALL KITCHEN BACKSPLASH
 OUTLETS TO BE INSTALLED ON
 BOTTOM OF UPPER CABINETS
 AND NOT IN BACKSPLASH. FIELD
 VERIFY LOCATION/OUTLET TYPE.

FIELD LOCATE FOLLOWING:
 1. (1) HOH (2 CAT5e & 1 RG6)
 DROP
 2. (1) DMARC RUNS INCLUDE
 CAT5e(2), RG6(2) & 16/2
 POWER

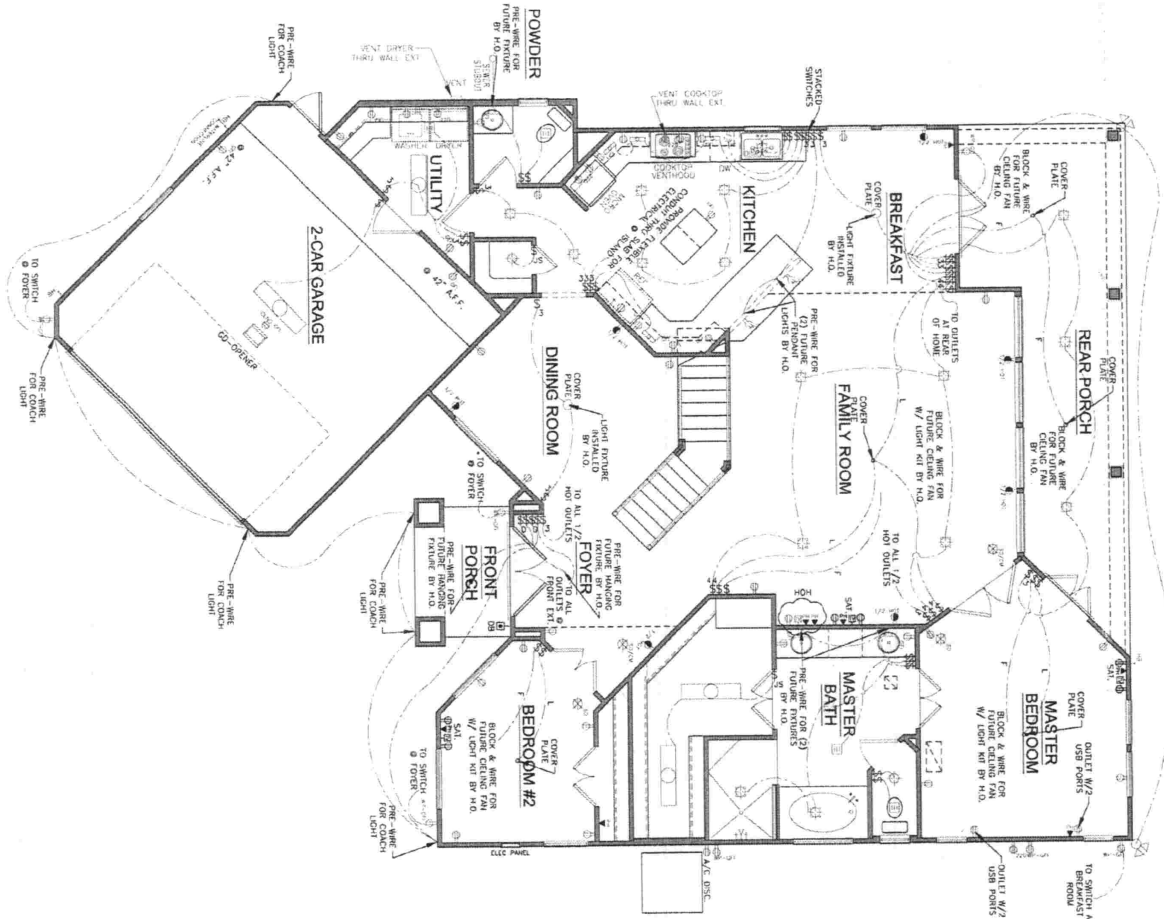

Homeowner's Name: Gisela Enowoldsen
Homeowner's Signature of Approval:
Sale's Consultant's Name: Robin Robinson
Sale's Consultant's Signature of Approval:
FINAL PLAN
Drawn By: RNU
Checked By: JEB
Date: 10/24/2014
Scale: 1/8" = 1'-0"
Sheet Number: 5 of 12
Electrical Plan

DESIGN TECH HOMES
CUSTOM BUILDER

1	REVISED
2	REVISED
3	REVISED
4	REVISED
5	REVISED
6	REVISED
7	REVISED
8	REVISED
9	REVISED
10	REVISED

Bastrop
 Houston
 San Antonio
 www.dth.com

THIS PLAN IS PROTECTED UNDER THE FEDERAL COPYRIGHT ACT BY DESIGN TECH HOMES LLP. THE USE OR REPRODUCTION OF THIS PLAN MAY BE AN INFRINGEMENT OF THE FEDERAL COPYRIGHT ACT.

