

DATE: DECEMBER 2020  
 CHECKED BY: PRASAD  
 DRAWN BY: SUDHA  
 SCALE: 1/4" = 1'-0"  
 JOB No: 20074  
 FILE: W:\2020 RESIDENTIAL\20074\WCS\ARCH


LIGHTING LAYOUT PLAN FOR  
 SINGLE FAMILY RESIDENCE  
 LOCATED AT  
 4313 LAVAYETTE ST.  
 BELLAIRE, TX 77401

VATANI CONSULTING ENGINEERS, PLLC  
 DESIGN CONSULTANTS  
 TYPE # 4268  
 5200 MITCHELLS  
 SUITE F-27  
 HOUSTON, TEXAS 77052  
 PHONE: (713) 954-5555  
 EMAIL: info@vatani.com


NIRE ELECTRIC  
 8206-0606-11  
 8206-0606-11  
 8206-0606-11  
 HOUSTON, TX 77081

THIS DRAWING IS PROPERTY OF VATANI CONSULTING ENGINEERS, PLLC AND IS NOT TO BE REPRODUCED OR TRANSMITTED IN ANY FORM OR BY ANY MEANS, ELECTRONIC OR MECHANICAL, INCLUDING PHOTOCOPYING, RECORDING, OR BY ANY INFORMATION STORAGE AND RETRIEVAL SYSTEM. CONTRACTOR IS RESPONSIBLE FOR ANY DISCREPANCIES ON FIELD CONDITIONS. CONTRACTOR SHALL BE RESPONSIBLE FOR ADJUSTMENT OR REVISIONS FOR A PERIOD OF 30 DAYS.

NO.	DATE	DESCRIPTION
1		
2		
3		
4		
5		
6		

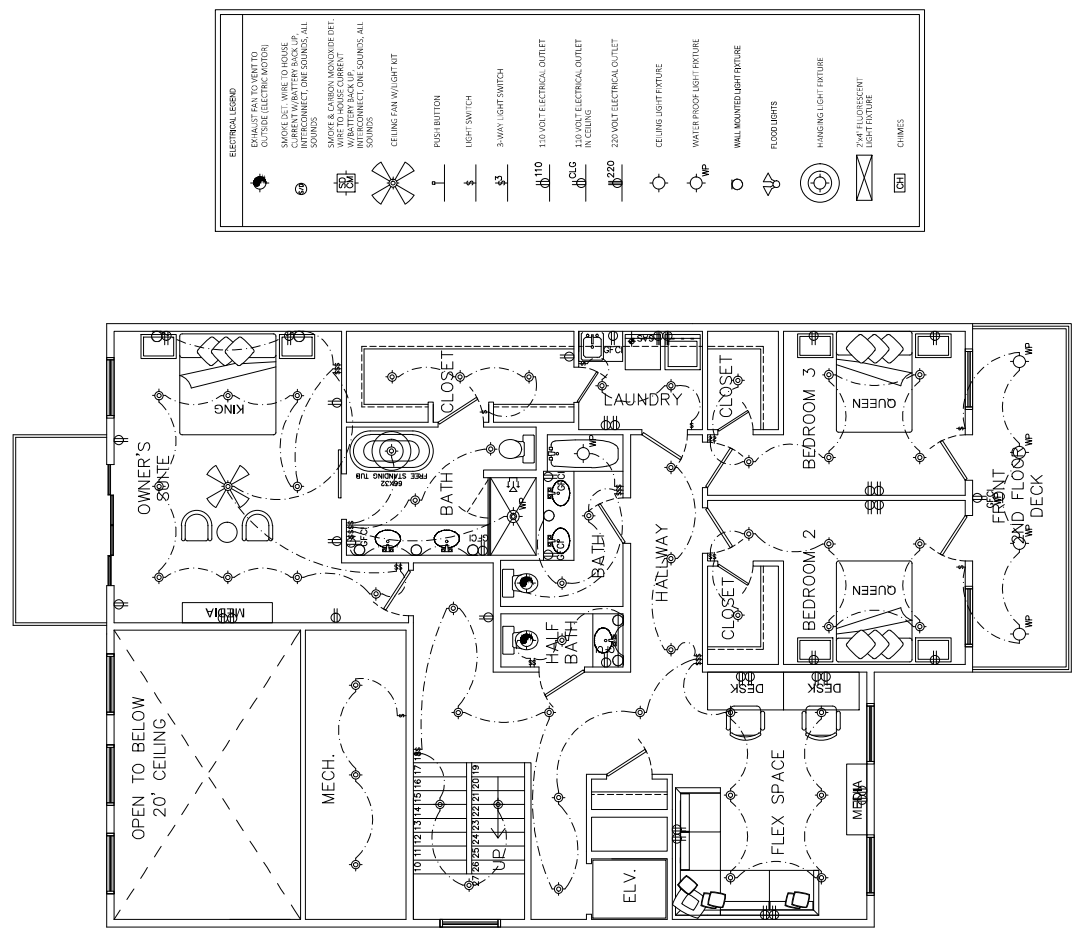

2ND FLOOR

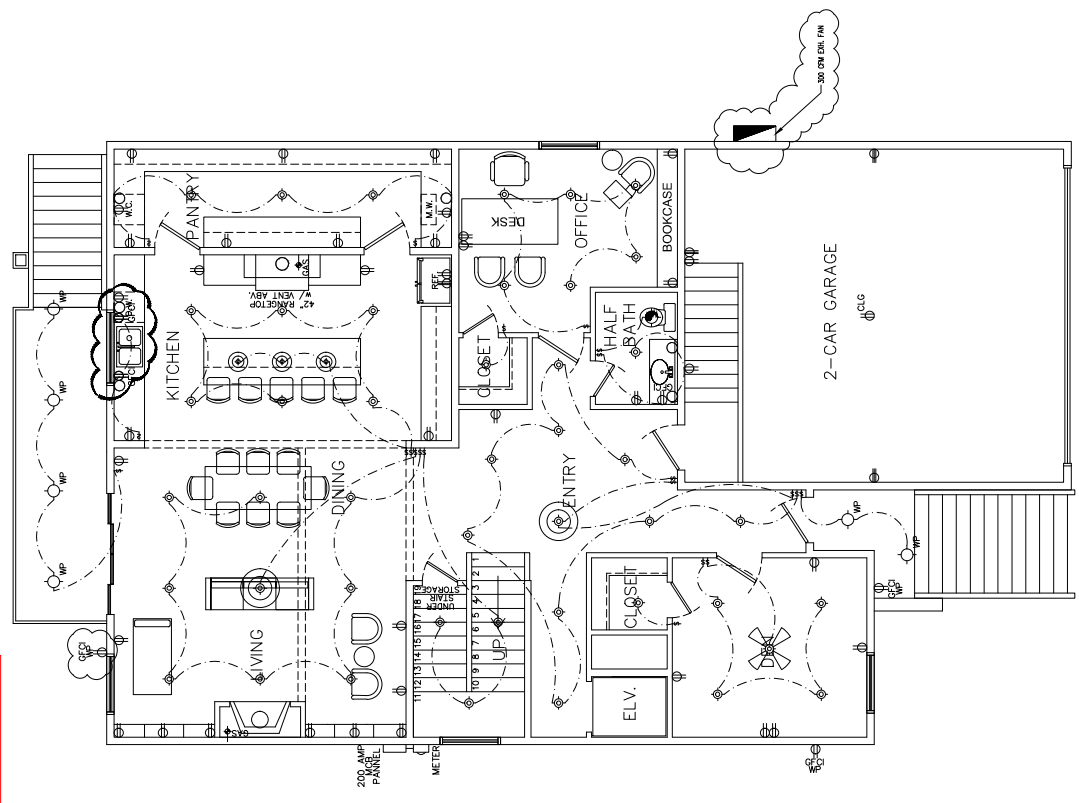

1ST FLOOR

