


1 FLOOR PLAN
SCALE: 1/4" = 1'

ABBREVIATIONS

SH	SINGLE HUNG	EB	EYE BROW	PAN	PANTRY	N.I.C.	WALK-IN CLOSET
DL	DIVIDED LIGHTS	PKT	POCKET	RM	ROOM	DBL	DOUBLE
HD	HEADER	DR	DOOR	CLST	CLOSET	SNK	SINK
HT	HEIGHT	FG	FIXED GLASS	CLST	CLOSET	SNK	SINK
OH	OVERHEAD	FG	FIXED GLASS	SHLYS	SHELVES	DW	DISH WASHER
SECT	SECTIONAL	OBSS	OBSCURED GLASS	CW	COLD WATER TAP	MSTR	MASTER
		/BTH	HALF BATH	CLG	CEILING		

ELECTRICAL LEGEND					
SYMBOL	DESCRIPTION	SYMBOL	DESCRIPTION	SYMBOL	DESCRIPTION
⊕	RECESSED LIGHT FIXTURE	⊕	110 V. DUPLEX RECEPT OUTLET	⊕	DIMMER SWITCH
⊕	CEILING MOUNTED LIGHT FIXTURE	⊕	110 V. FLOOR OUTLET	⊕	GARAGE DOOR OPENER
⊕	WALL MOUNT LIGHT FIXTURE	⊕	GROUND FAULT INTERRUPTER DUPLEX RECEPTACLE OUTLET	⊕	PUSH BUTTON GARAGE DOOR
⊕	VENT	⊕	WATER PROOF OUTLET	⊕	DOOR BELL
⊕	SMOKE DETECTOR	⊕	SINGLE POLE SWITCH	⊕	BREAKER PANEL
⊕	220 V. DUPLEX RECEPT OUTLET	⊕	2 WAY SWITCH	⊕	TELEVISION JACK

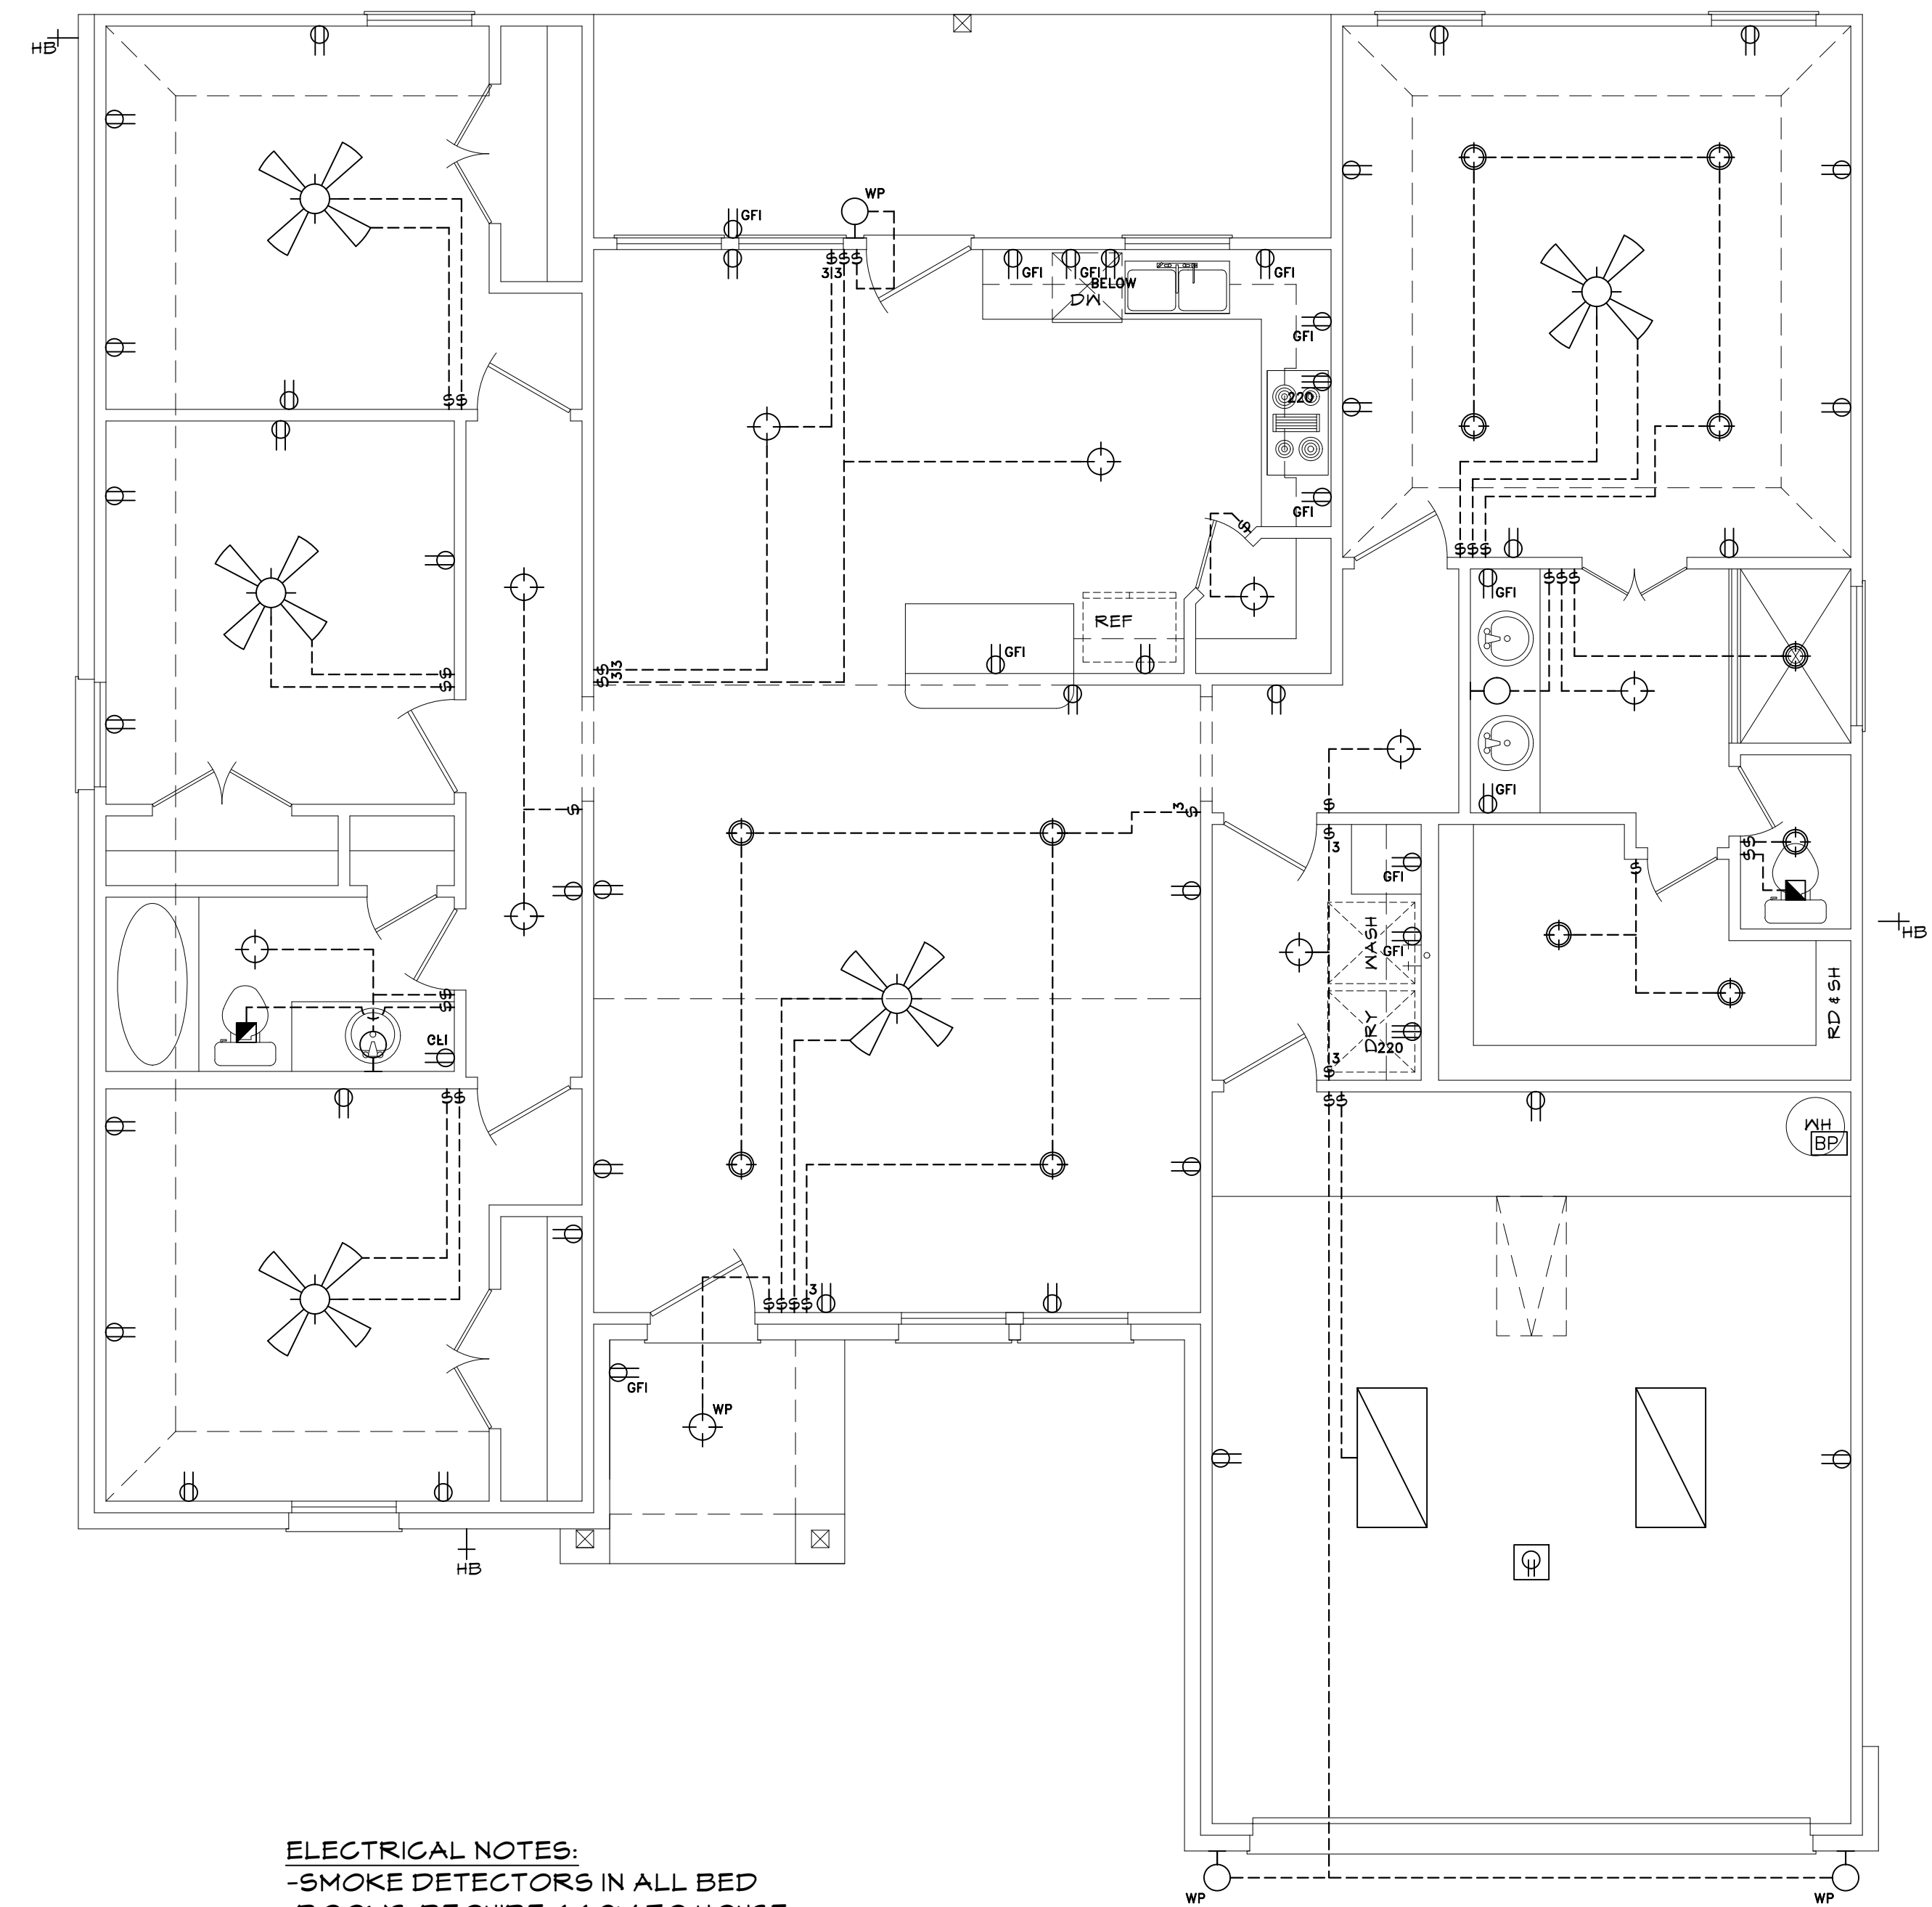

ELECTRICAL NOTES:
 -SMOKE DETECTORS IN ALL BED ROOMS, REQUIRE 110V TO HOUSE WIRING, BATTERY BACKUP & INTERCONNECT
 -VENT ALL EXHAUST FANS TO OUTSIDE
 -PROVIDE G.F.I. PROTECTION ON BATH PLUGS
 -PROVIDE LIGHT FIXTURE & SMOKE DETECTORS AT WATER HEATER & A/C UNIT
 -PROVIDE ELECTRIC DISCONNECT AT A/C UNIT

2 ELECTRICAL
SCALE: 1/4" = 1'

MOONLIGHT HOUSE PLANS IS A DRAFTING FIRM, NOT AN ENGINEERING OR ARCHITECTURAL FIRM. THESE PRINTS ARE FOR INFORMATION ONLY. MOONLIGHT HOUSE PLANS IS NOT RESPONSIBLE FOR ANY STRUCTURAL OR DESIGN MISTAKES. DIMENSIONS, DETAILS & SPECIFICATIONS SHALL GOVERN OVER ALL OTHERS.
 DESIGNERS WILL NOT BE LIABLE FOR HUMAN ERROR AFTER CONSTRUCTION IS STARTED.
 THESE DRAWINGS, SPECIFICATIONS AND IDEAS ARE THE PROPERTY OF MOONLIGHT HOUSE PLANS, AND SHALL NOT BE REUSED, REPRODUCED, OR ALTERED IN ANY WAY.

Moonlight House Plans
979-482-1967

REVISION HISTORY	DATE
NUMBER	

DWG. SCALE: 1/4" = 1'-0"

FLOOR PLAN
WARD
PLAN 1761
JOB #: 20183001

02-01-18

A2