

FLOOR PLAN

DOOR SCHEDULE			
QTY	RL	SIZE	TYPE
5	R	20'x68"	INT. HC.
10	L	20'x68"	INT. HC.
1	R	24'x68"	INT. HC.
1	L	24'x68"	INT. HC.
2	R	26'x68"	INT. HC.
1	L	26'x68"	INT. HC.
2	L	28'x68"	INT. HC.
1		2120'x68"	INT. FR. DBL. @ STUDY
1	L	28'x68"	INT. SC. @ GARAGE
1	R	24'x68"	EXT. FR. @ SCREEN PATIO
1	L	28'x68"	EXT. FR. @ OPEN PATIO
1	L	30'x80"	EXT. SPECIAL FRONT DOOR
1		80'x70"	MTL. SECT. GARAGE DOOR
1		160'x70"	MTL. SECT. GARAGE DOOR

WINDOW SCHEDULE		
QTY	SIZE	TYPE
3	40'x60"	SH. DL.
1	30'x50"	FX. DL. @ DUTCH HIP UPPER
1	(3)26'x70"	FX. DL. (MULL)
1	30'x20"	FX. DL. TRANS.
3	30'x60"	SH.
3	30'x60"	FX.
3	40'x70"	FX.
1	40'x50"	FX. OBS. TEMPERED

AREA	SQ. FT.
A/C FRAME	2992
PORCH	136
PATIO	403
GARAGE	800
TOTAL A.U.R. FRAME	4331
SLAB	4477
WIDTH	80'-0.5"
DEPTH	59'-10"

ALL COPY RIGHTS ARE THE SOLE PROPERTY OF HOMESTEAD DESIGNS

**Homestead Designs**  
 Plano, TEXAS  
 214-215-1013  
 e-mail: [homestead.designs@verizon.net](mailto:homestead.designs@verizon.net)


BUILDER/OWNER  
 FEDASCO LLC  
 6623 PROVIDENCE RIVER LANE  
 PARK ROW, TEXAS 77943  
 PHONE: 832-495-5632

REVISION DATE  
 11-30-2017 BLP  
 PROJECT ADDRESS:  
 115 BIRDIE DRIVE  
 HEMPSTEAD, TEAXS 77445

PLAN NUMBER  
 2992

DESIGNED AND DRAWN BY:  
 HOMESTEAD DESIGNS  
 B.L.PHILLIPS  
 FOUNDER-DESIGNER  
 214-215-1013

SCALE:  
 1/8"=1'-0" (11x17) SHEET  
 1/4"=1'-0" (22x34) SHEET

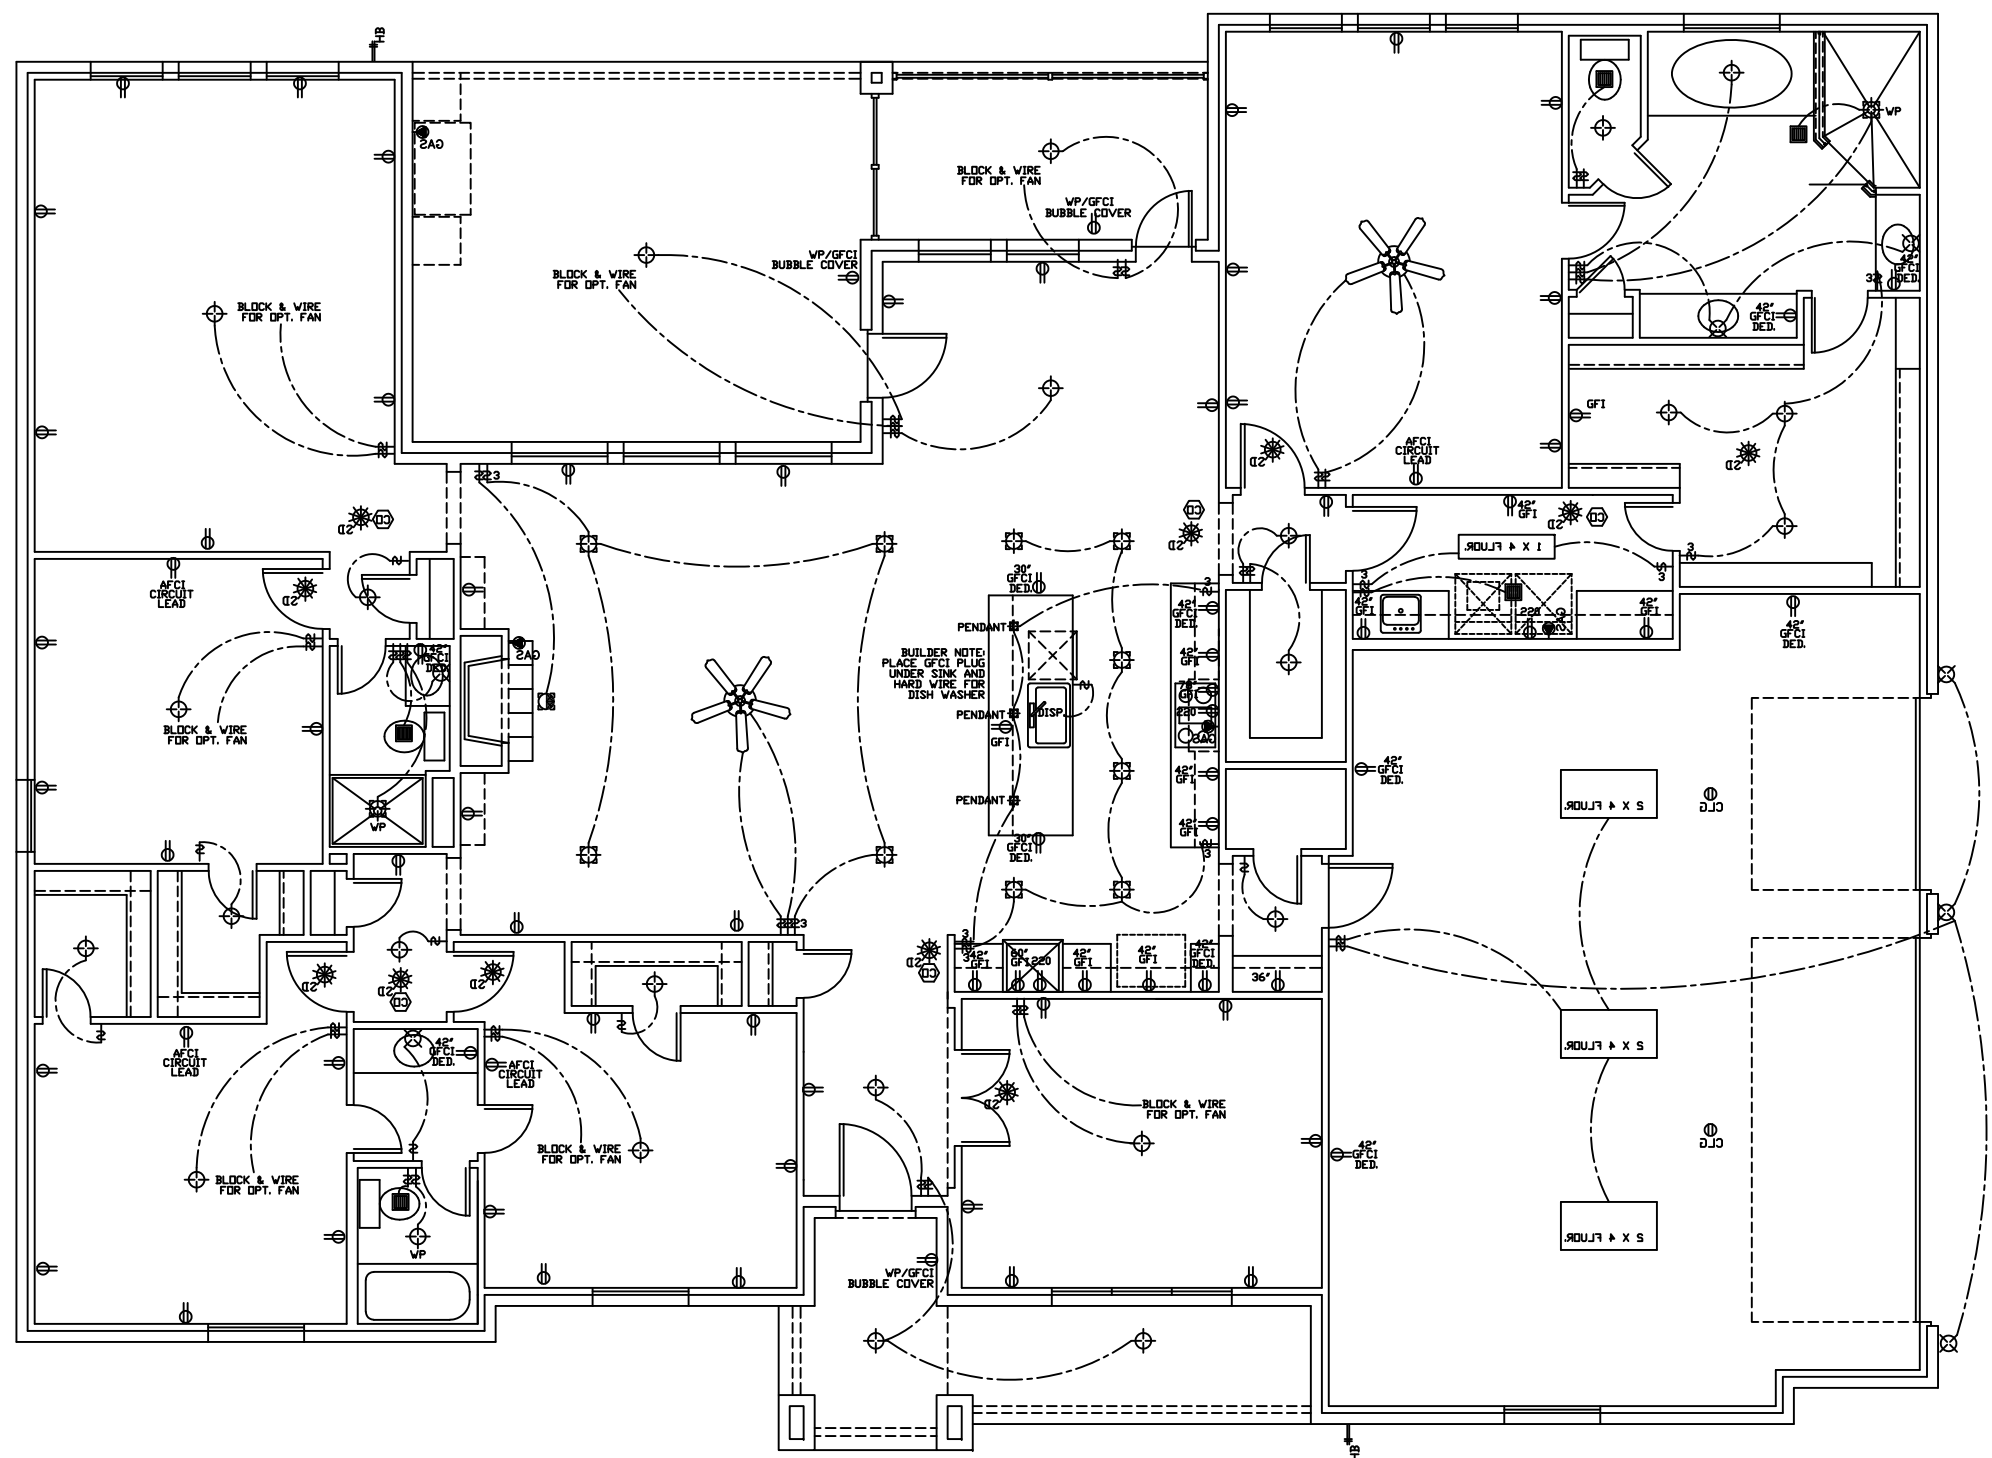

ELECTRICAL PLAN

ELECTRICAL LEGEND			
	HOSE BIBB		CEILING DUPLEX
	SWITCH		FLOOR DUPLEX
	THREE-WAY SWITCH		PHONE OUTLET
	FOUR-WAY SWITCH		TV OUTLET
	RHEOSTAT		GAS OUTLET
	DUPLEX		JUNCTION
	COUNTERTOP DUPLEX		220 VOLT OUTLET
	SPLIT WIRED DUPLEX		LANDSCAPING LIGHT
	QUADRUPLEX		FLOODLIGHT
	CEILING LIGHT		RECESSED CEILING LIGHT
	WALL HUNG LIGHT		WALL HUNG FAN
	RECESSED EYEBALL LIGHT		VENT
	VENT AND LIGHT		HEAT AND LIGHT
	HEAT AND VENT		HEAT, VENT AND LIGHT

ALL COPY RIGHTS ARE THE SOLE PROPERTY OF HOMESTEAD DESIGNS

**Homestead Designs**  
 Plano, TEXAS  
 214-215-1013  
 e-mail: homestead.designs@verizon.net

BUILDER/OWNER  
 FEDASCO LLC  
 6623 PROVIDENCE RIVER LANE  
 PARK ROW, TEXAS 77943

PHONE:  
 832-495-5632

REVISION DATE  
 11-30-2017 BLP

PROJECT ADDRESS:  
 115 BIRDIE DRIVE  
 HEMPSTEAD, TEXAS 77445

PLAN NUMBER  
 2992

DESIGNED AND DRAWN BY:  
 HOMESTEAD DESIGNS  
 B.L.PHILLIPS  
 FOUNDER-DESIGNER  
 214-215-1013

SCALE:  
 1/8"=1'-0" (11x17) SHEET  
 1/4"=1'-0" (22x34) SHEET

PAGE # 2

ALL COPY RIGHTS ARE THE SOLE PROPERTY OF HOMESTEAD DESIGNS

**Homestead Designs**

Plano, TEXAS  
214-215-1013  
e-mail: [homestead.designs@verizon.net](mailto:homestead.designs@verizon.net)

BUILDER/OWNER  
FEDASCO LLC  
6623  
PROVIDENCE  
RIVER LANE  
PARK ROW,  
TEXAS 77943

PHONE:  
832-495-5632

REVISION DATE  
11-30-2017 BLP


PROJECT ADDRESS:  
115 BIRDIE DRIVE  
HEMPSTEAD,  
TEXAS 77445

PLAN NUMBER  
2992


DESIGNED AND DRAWN BY:  
HOMESTEAD  
DESIGNS  
B.L.PHILLIPS  
FOUNDER-  
DESIGNER  
214-215-1013

SCALE:  
1/8"=1'-0" (11x17) SHEET  
1/4"=1'-0" (22x34) SHEET



PAGE # 3

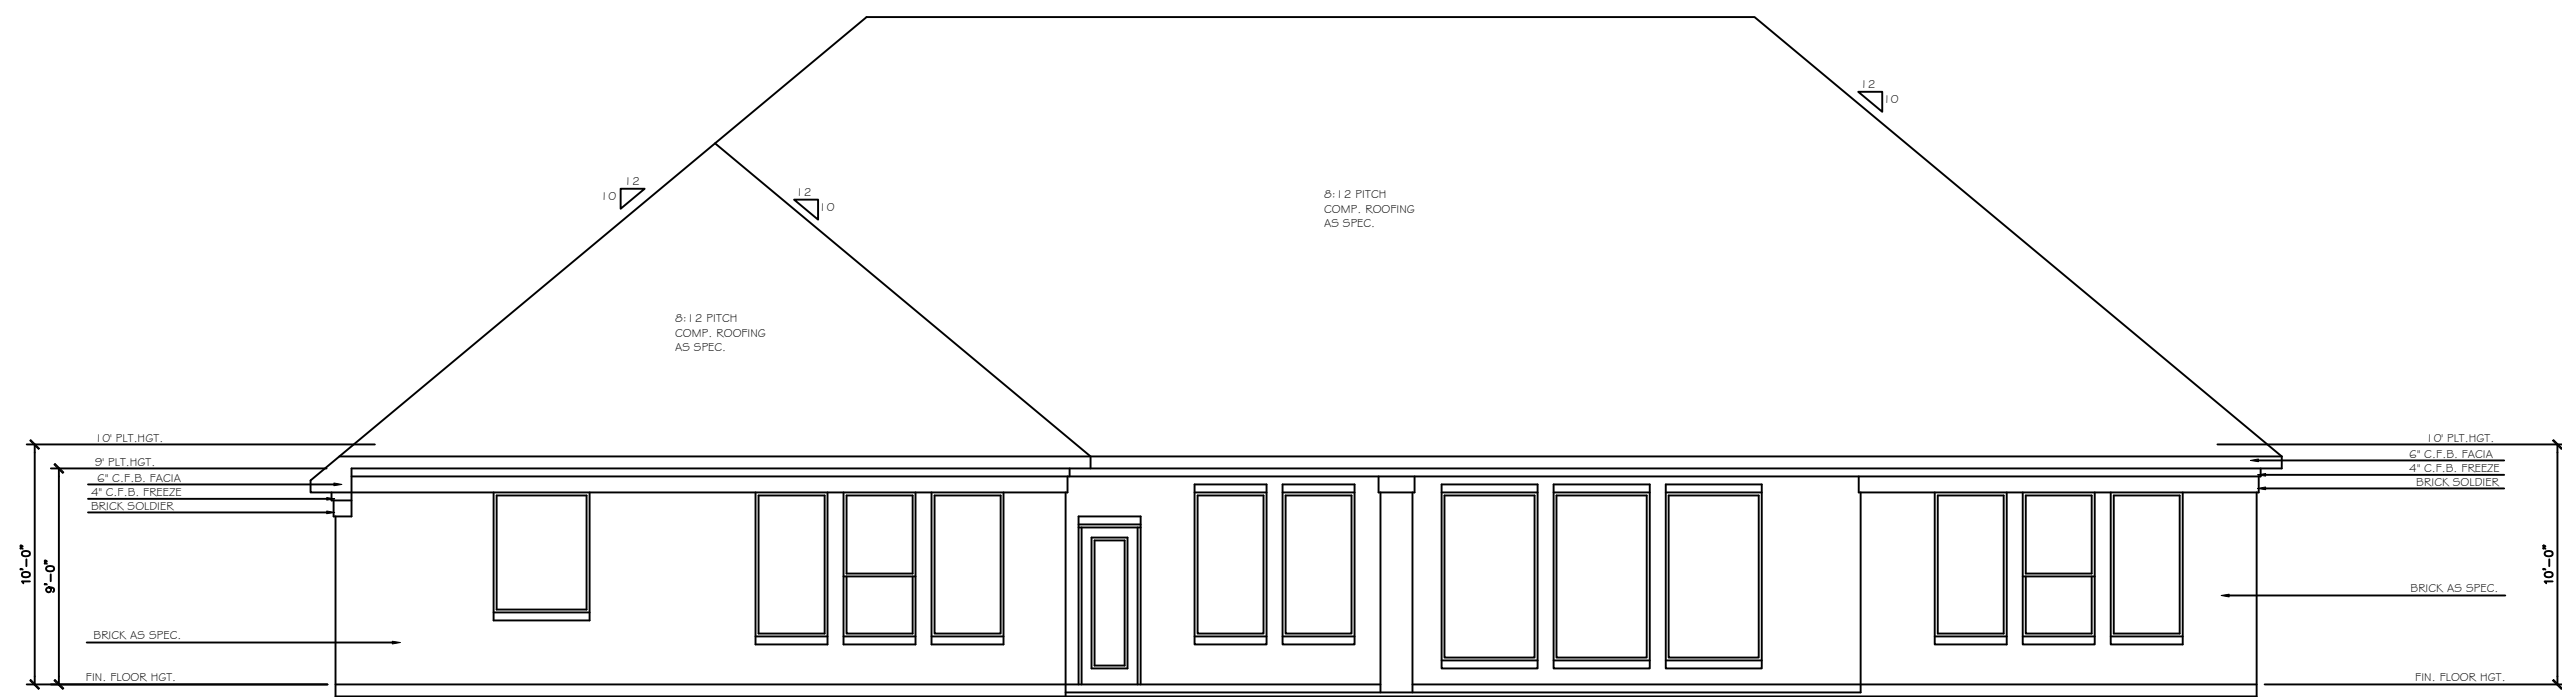

REAR ELEVATION

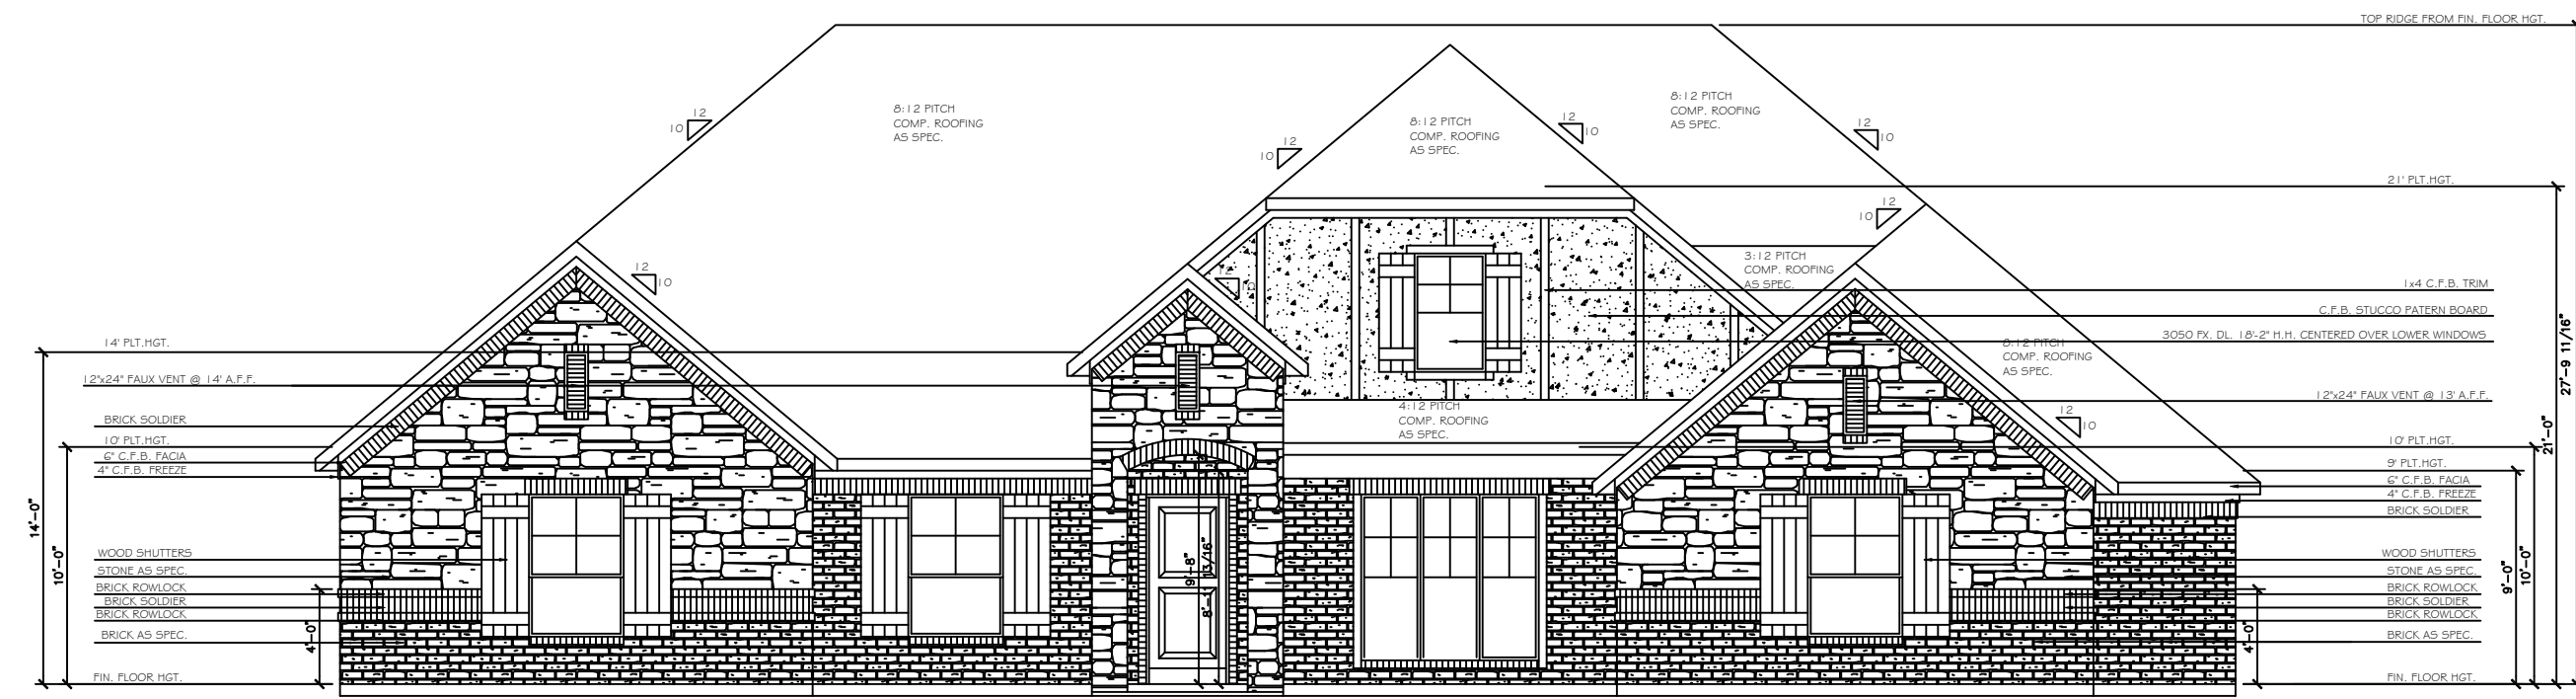

FRONT ELEVATION

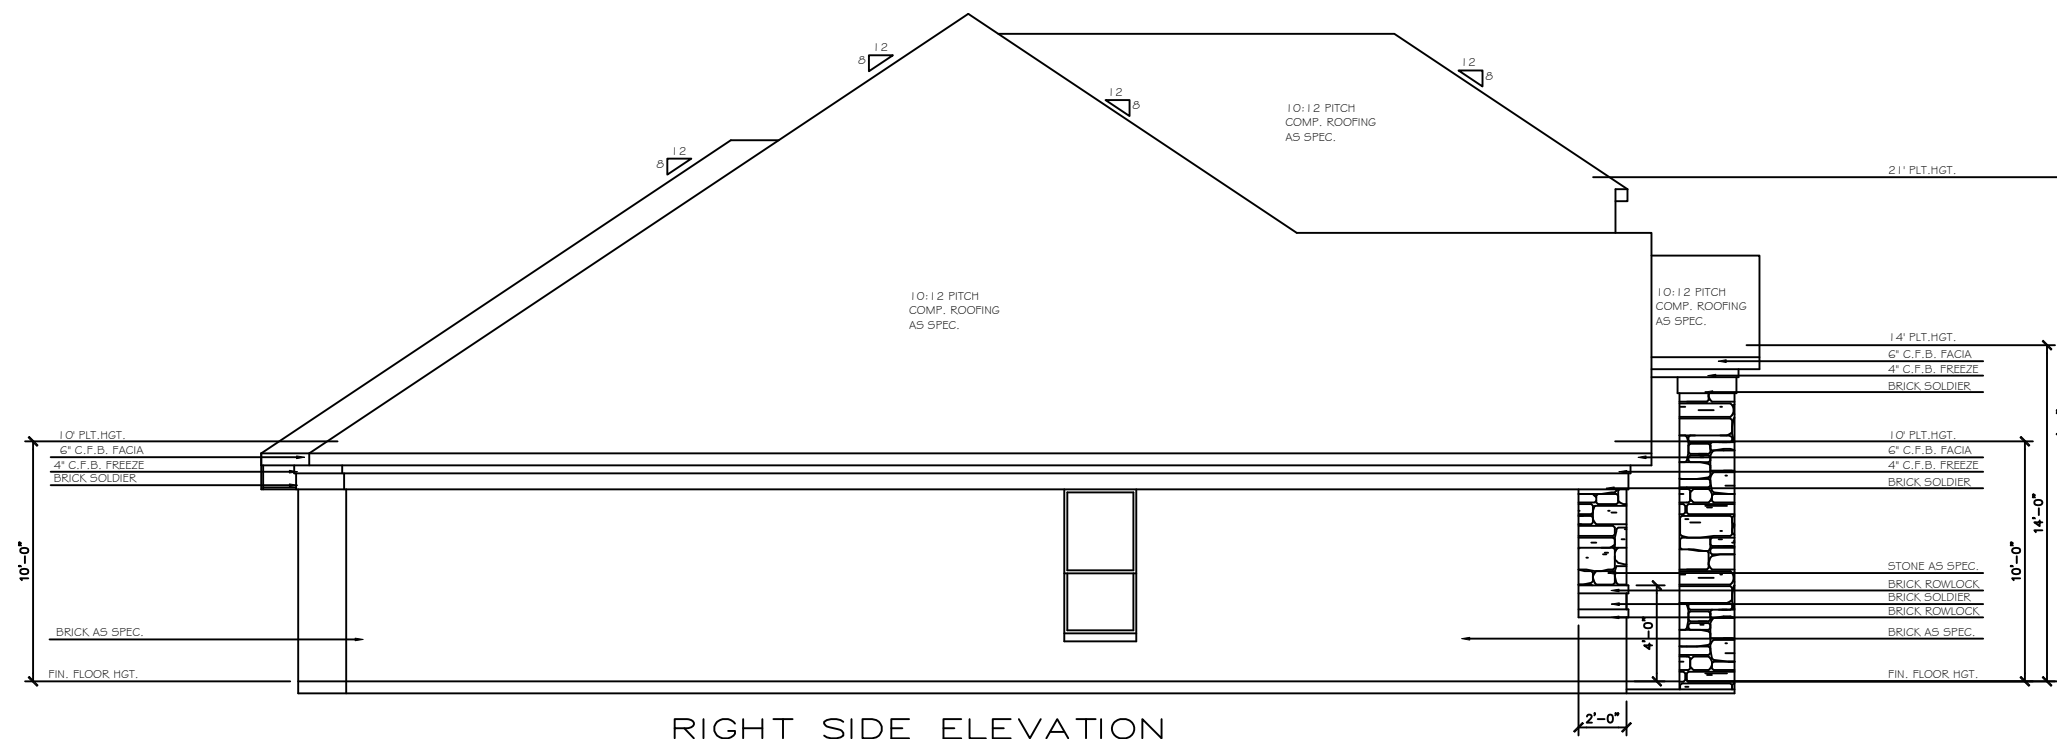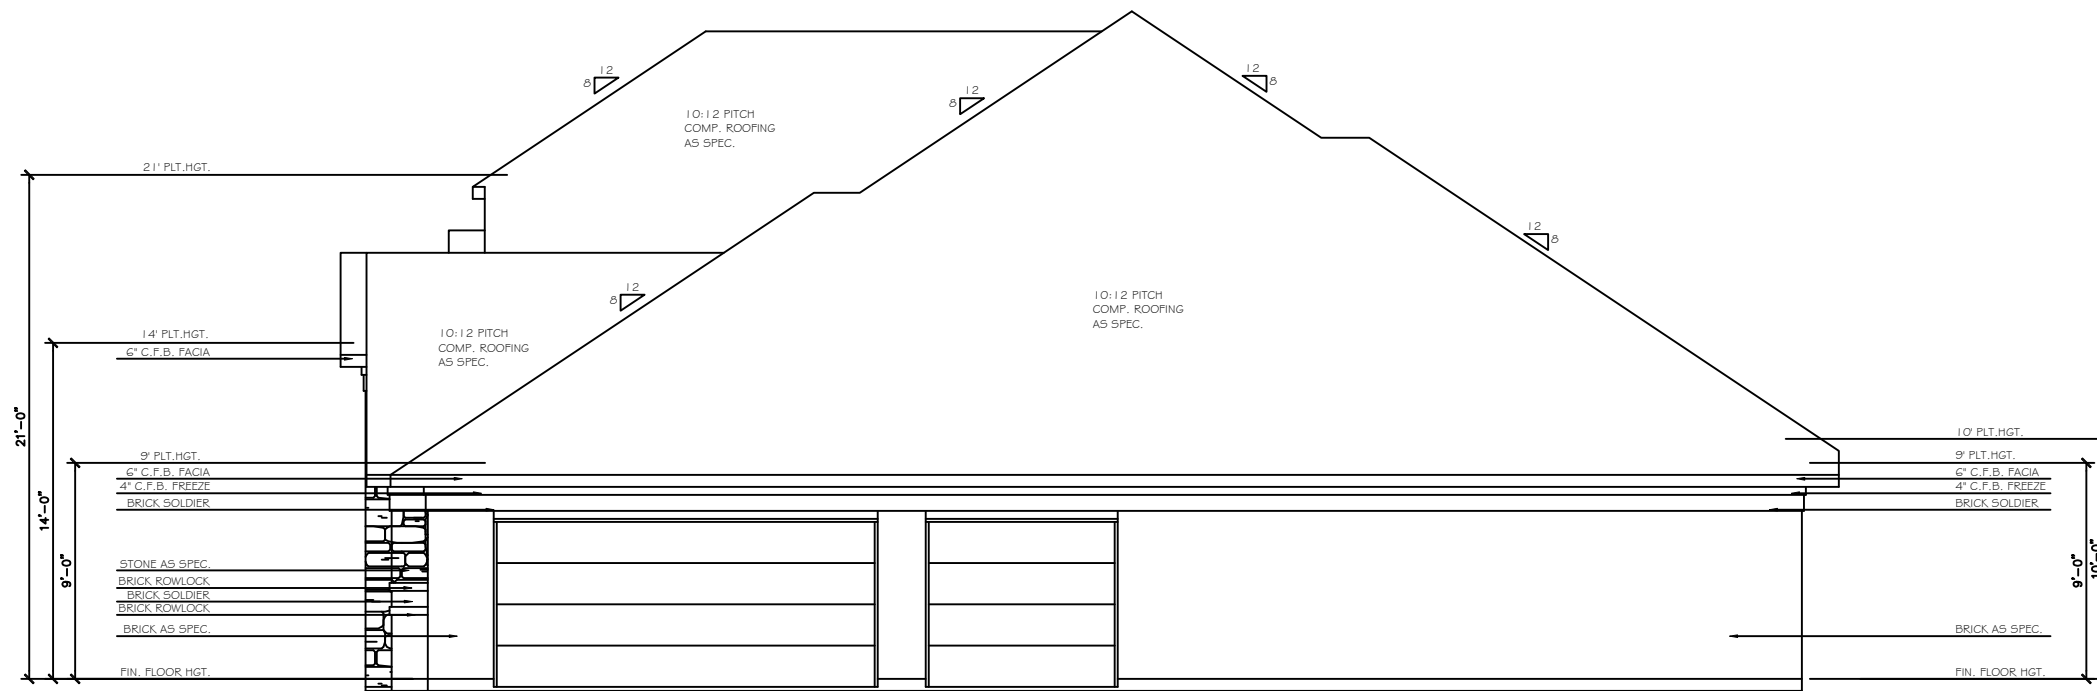

**RIGHT SIDE ELEVATION**

ALL COPY RIGHTS ARE THE SOLE PROPERTY OF HOMESTEAD DESIGNS

**Homestead Designs**

Plano, TEXAS  
214-215-1013  
e-mail: [homestead.designs@verizon.net](mailto:homestead.designs@verizon.net)

BUILDER/OWNER  
FEDASCO LLC  
6623  
PROVIDENCE  
RIVER LANE  
PARK ROW,  
TEXAS 77943

PHONE:  
832-495-5632


REVISION DATE  
11-30-2017 BLP

PROJECT ADDRESS:  
115 BIRDIE DRIVE  
HEMPSTEAD,  
TEAXS 77445

PLAN NUMBER  
2992

DESIGNED AND DRAWN BY:  
HOMESTEAD  
DESIGNS  
B.L.PHILLIPS  
FOUNDER-  
DESIGNER  
214-215-1013

SCALE:  
1/8"=1'-0" (11x17) SHEET  
1/4"=1'-0" (22x34) SHEET

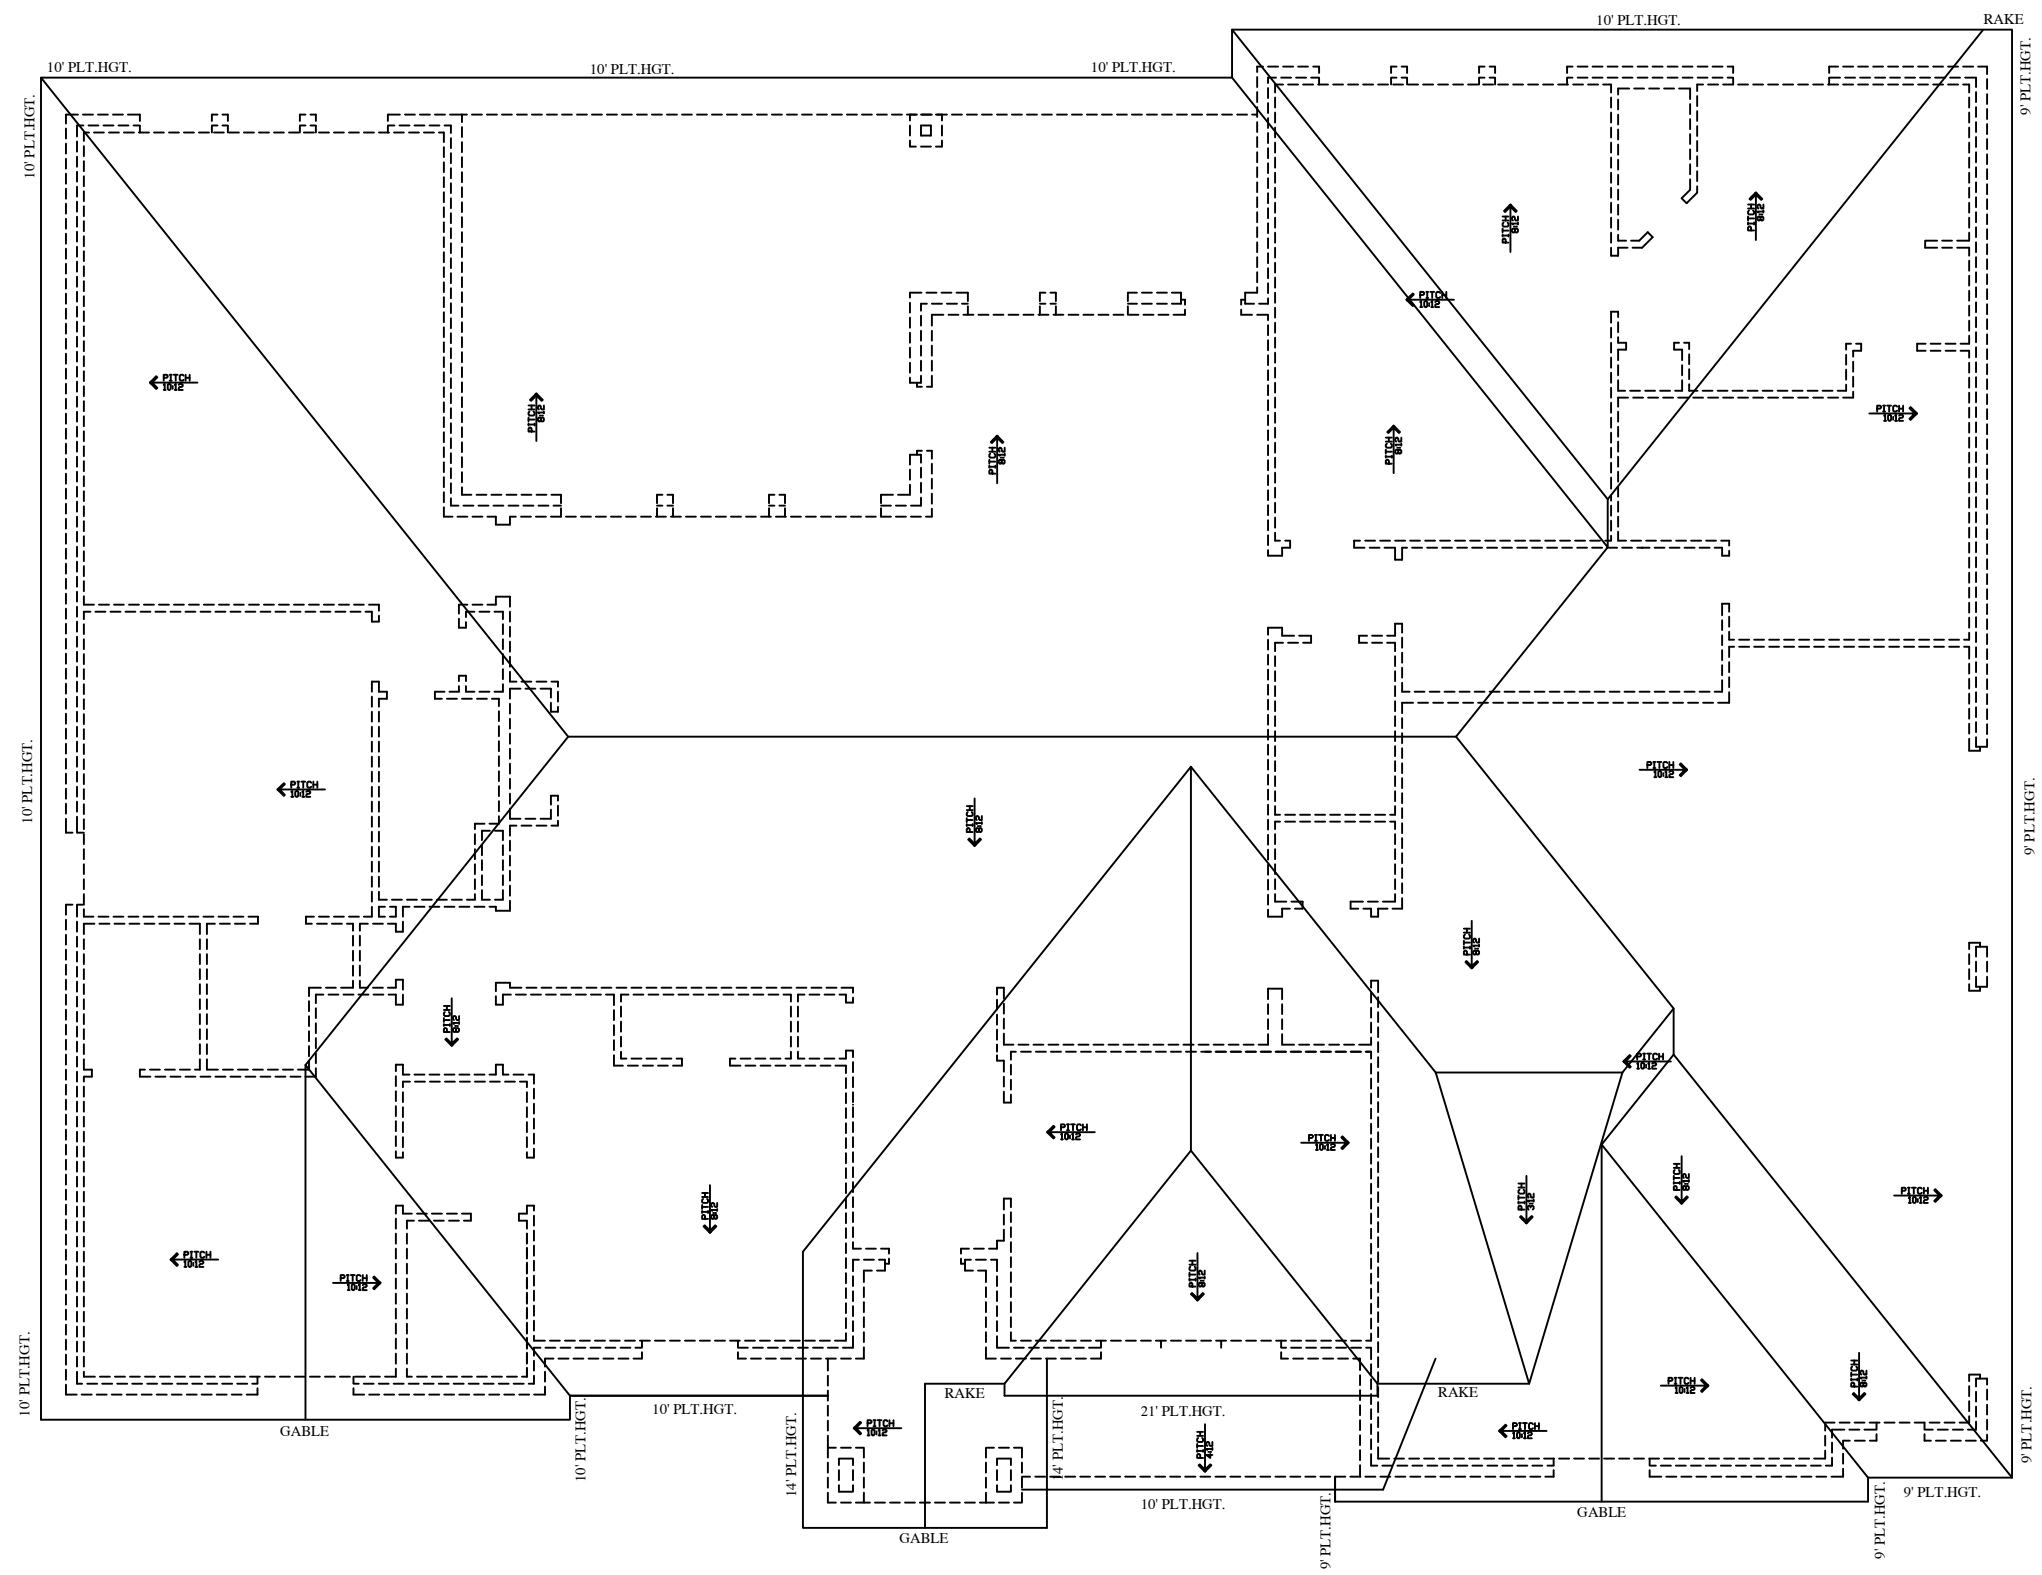

ROOF PLAN

ALL COPY RIGHTS ARE THE SOLE PROPERTY OF HOMESTEAD DESIGNS

**Homestead Designs**

Plano, TEXAS  
214-215-1013  
e-mail: [homestead.designs@verizon.net](mailto:homestead.designs@verizon.net)

BUILDER/OWNER  
FEDASCO LLC  
6623  
PROVIDENCE  
RIVER LANE  
PARK ROW,  
TEXAS 77943

PHONE:  
832-495-5632

REVISION DATE  
11-30-2017 BLP

PROJECT ADDRESS:  
115 BIRDIE DRIVE  
HEMPSTEAD,  
TEAXS 77445

PLAN NUMBER  
2992

DESIGNED AND DRAWN BY:  
HOMESTEAD  
DESIGNS  
B.L.PHILLIPS  
FOUNDER-  
DESIGNER  
214-215-1013

SCALE:  
1/8"=1'-0" (11x17) SHEET  
1/4"=1'-0" (22x34) SHEET